


**HVAC PLAN - MAIN LEVEL**  
SCALE: 1:50

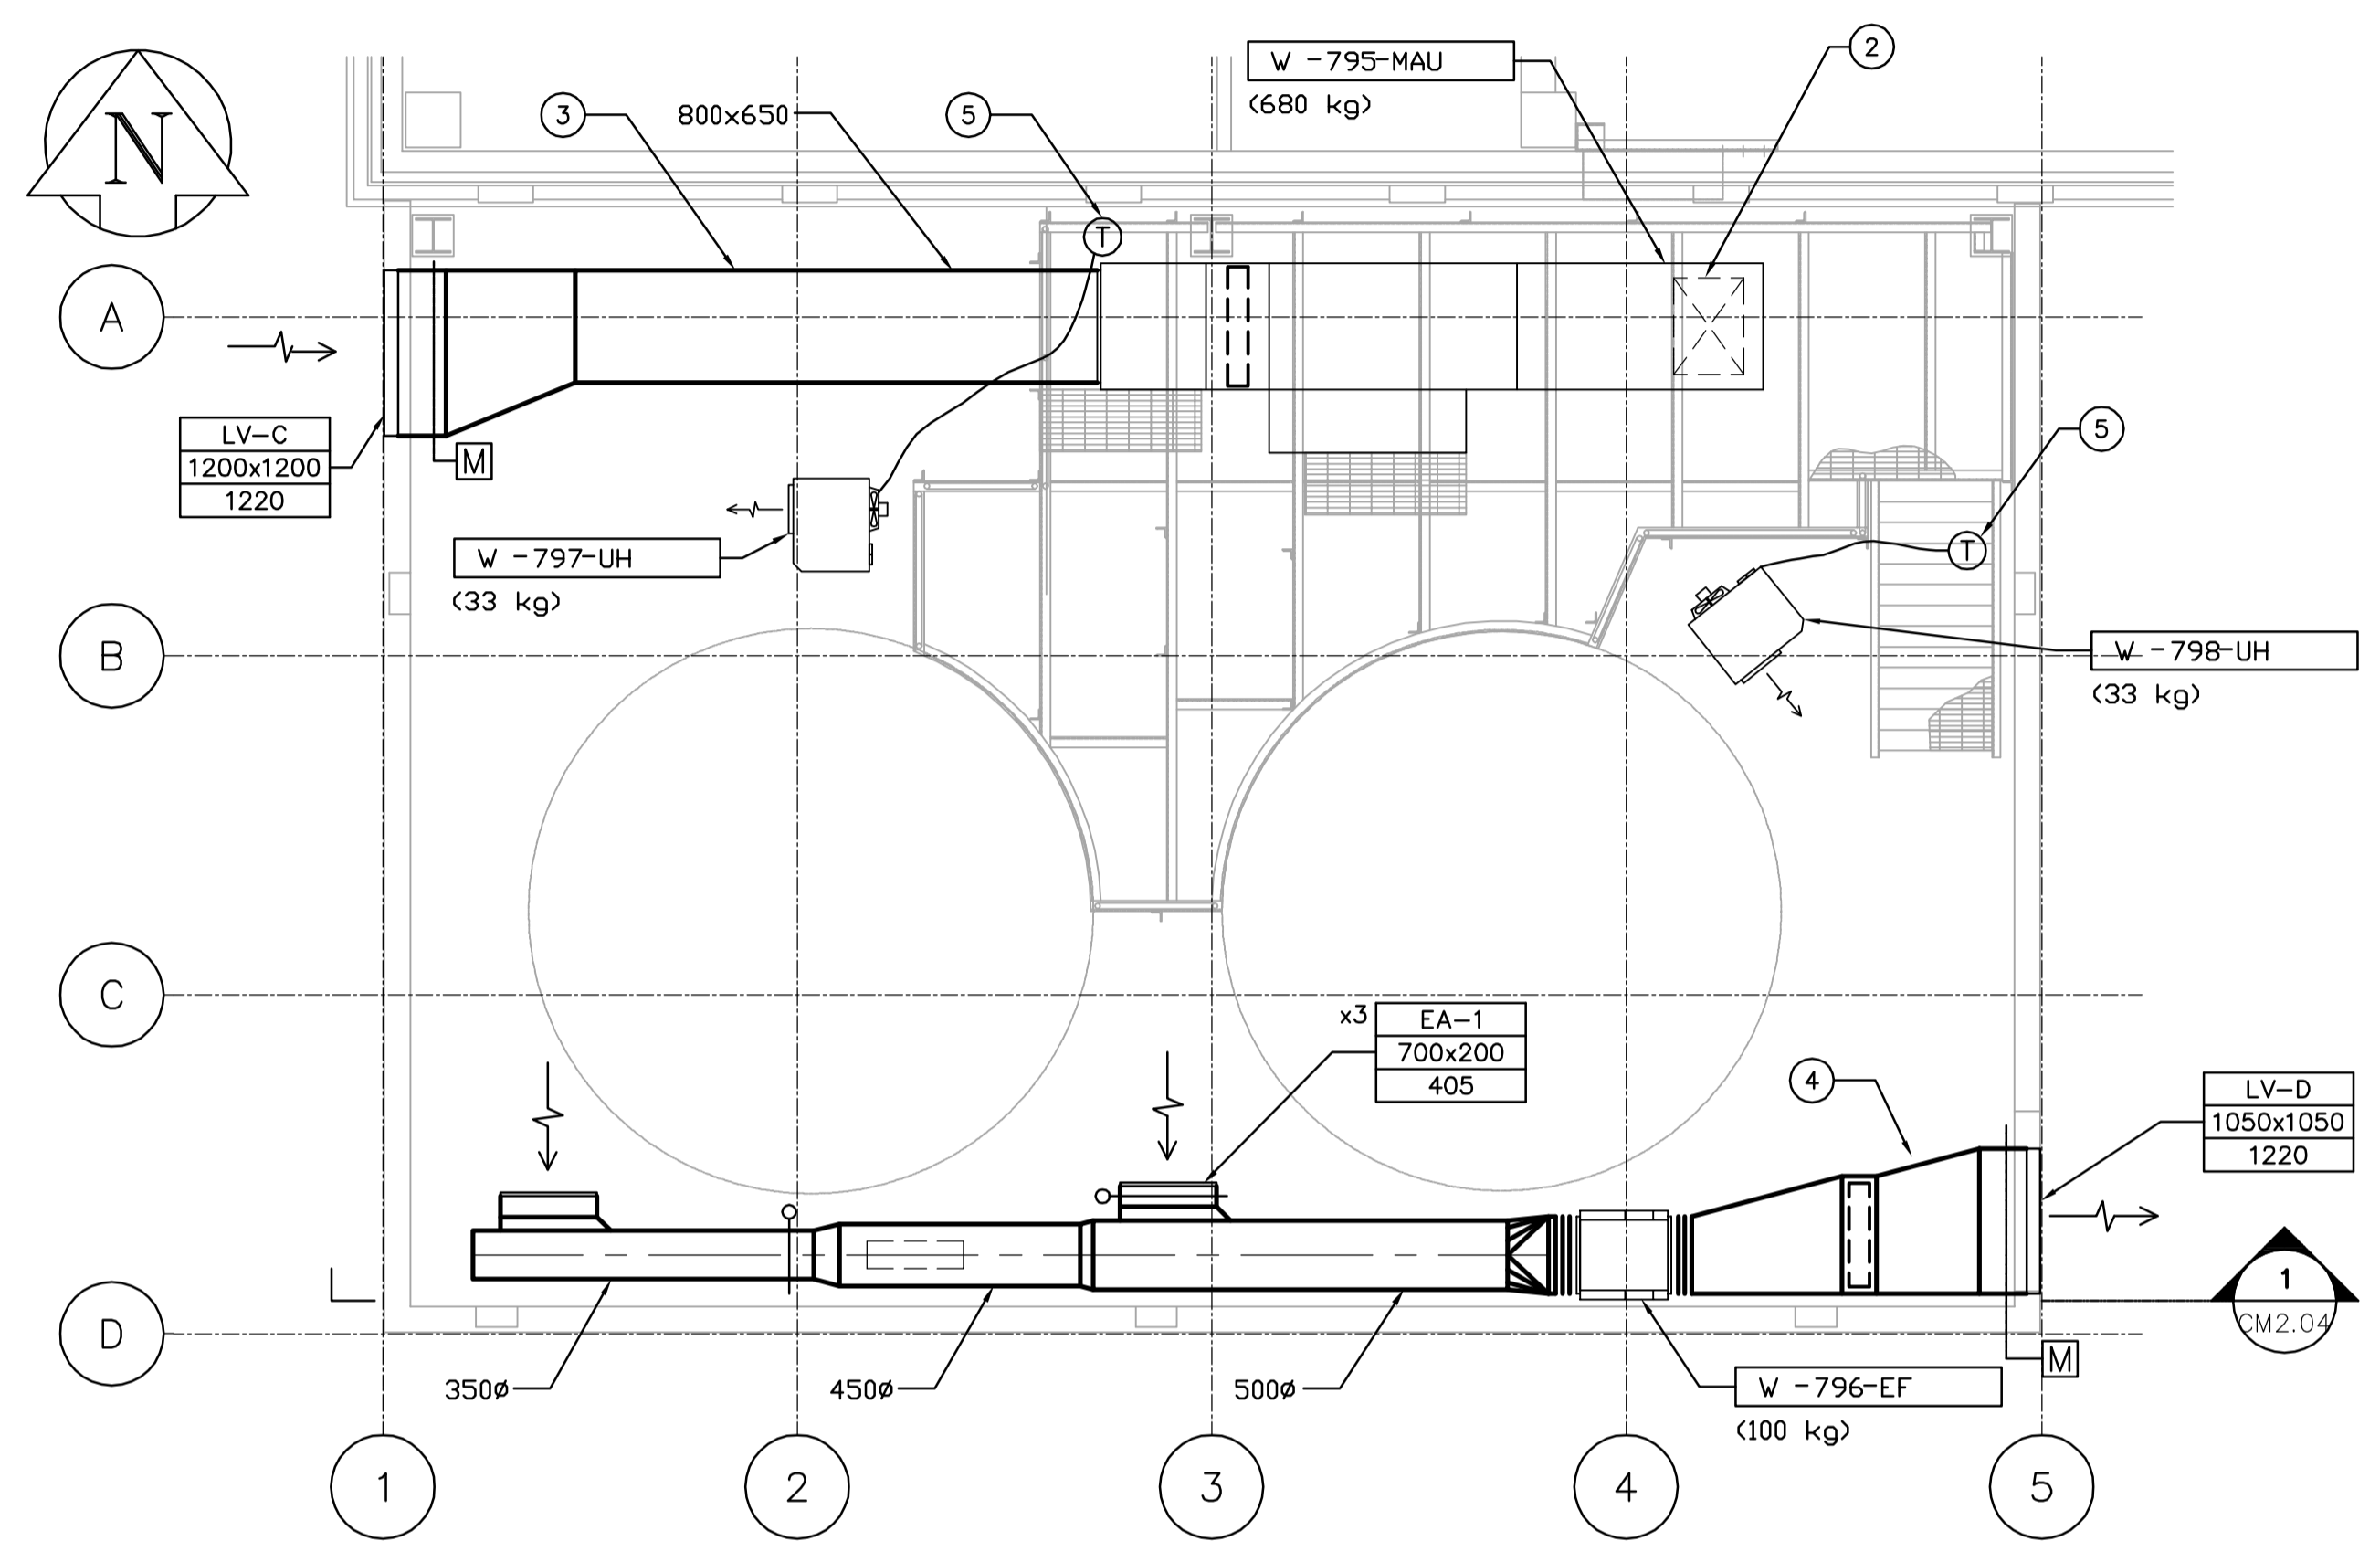

**HVAC PLAN - MEZZANINE LEVEL**  
SCALE: 1:50

**DRAWING NOTES**

- ① SUPPLY AIR DOWN FROM MAKE-UP AIR UNIT ABOVE.
- ② SUPPLY AIR DOWN THROUGH GRATING.
- ③ THERMALLY INSULATE FROM WALL TO MAKE-UP AIR UNIT.
- ④ THERMALLY INSULATE FROM WALL TO EXHAUST FAN.
- ⑤ THERMOSTATS ON MAIN LEVEL.

**GENERAL NOTES**

1. COORDINATE WITH OTHER TRADES SO AS TO PREVENT CONFLICTS.
2. PROVIDE HOUSEKEEPING PADS UNDER ALL FLOOR MOUNTED AIR HANDLING EQUIPMENT, PUMPS & TANKS. COORDINATE WITH STRUCTURAL FOR PAD HEIGHT.
3. ALL DUCTWORK SHALL BE SUPPORTED AND SUSPENDED AS PER SPECIFICATIONS AND LOCAL CODES. (SEE DETAILS)



B.M. ELEV.			
DESIGNED BY	DC	CHECKED BY	AA
DRAWN BY	DC	APPROVED BY	D. TANIGUCHI
SCALE:	1:50	RELEASED FOR CONSTRUCTION BY:	K. MARTENS
NO. REVISIONS		DATE	2005/09/21
		DATE	05/12/02



ENGINEER'S SEAL	
ORIGINAL SIGNED BY	P. TATARYN
	2005/12/02
CONSULTANT DRAWING NO.	CM2.03

<b>THE CITY OF WINNIPEG</b> <b>WATER AND WASTE DEPARTMENT</b> <b>ENGINEERING DIVISION</b>	
NEWPCC CENTRATE NUTRIENT TREATMENT PHOSPHORUS REMOVAL FACILITY CONTRACT No. 1	CITY FILE NUMBER
	SHEET OF
MECHANICAL CHEMICAL STORAGE BUILDING HVAC PLAN	CITY DRAWING NUMBER <b>1-010F-A-M0005-001-00-D</b>