




THE CITY OF WINNIPEG

PUBLIC WORKS DEPARTMENT
ENGINEERING DIVISION

KENASTON UNDERPASS PROJECT BID OPPORTUNITY No. 644-2005 PUMPING STATION

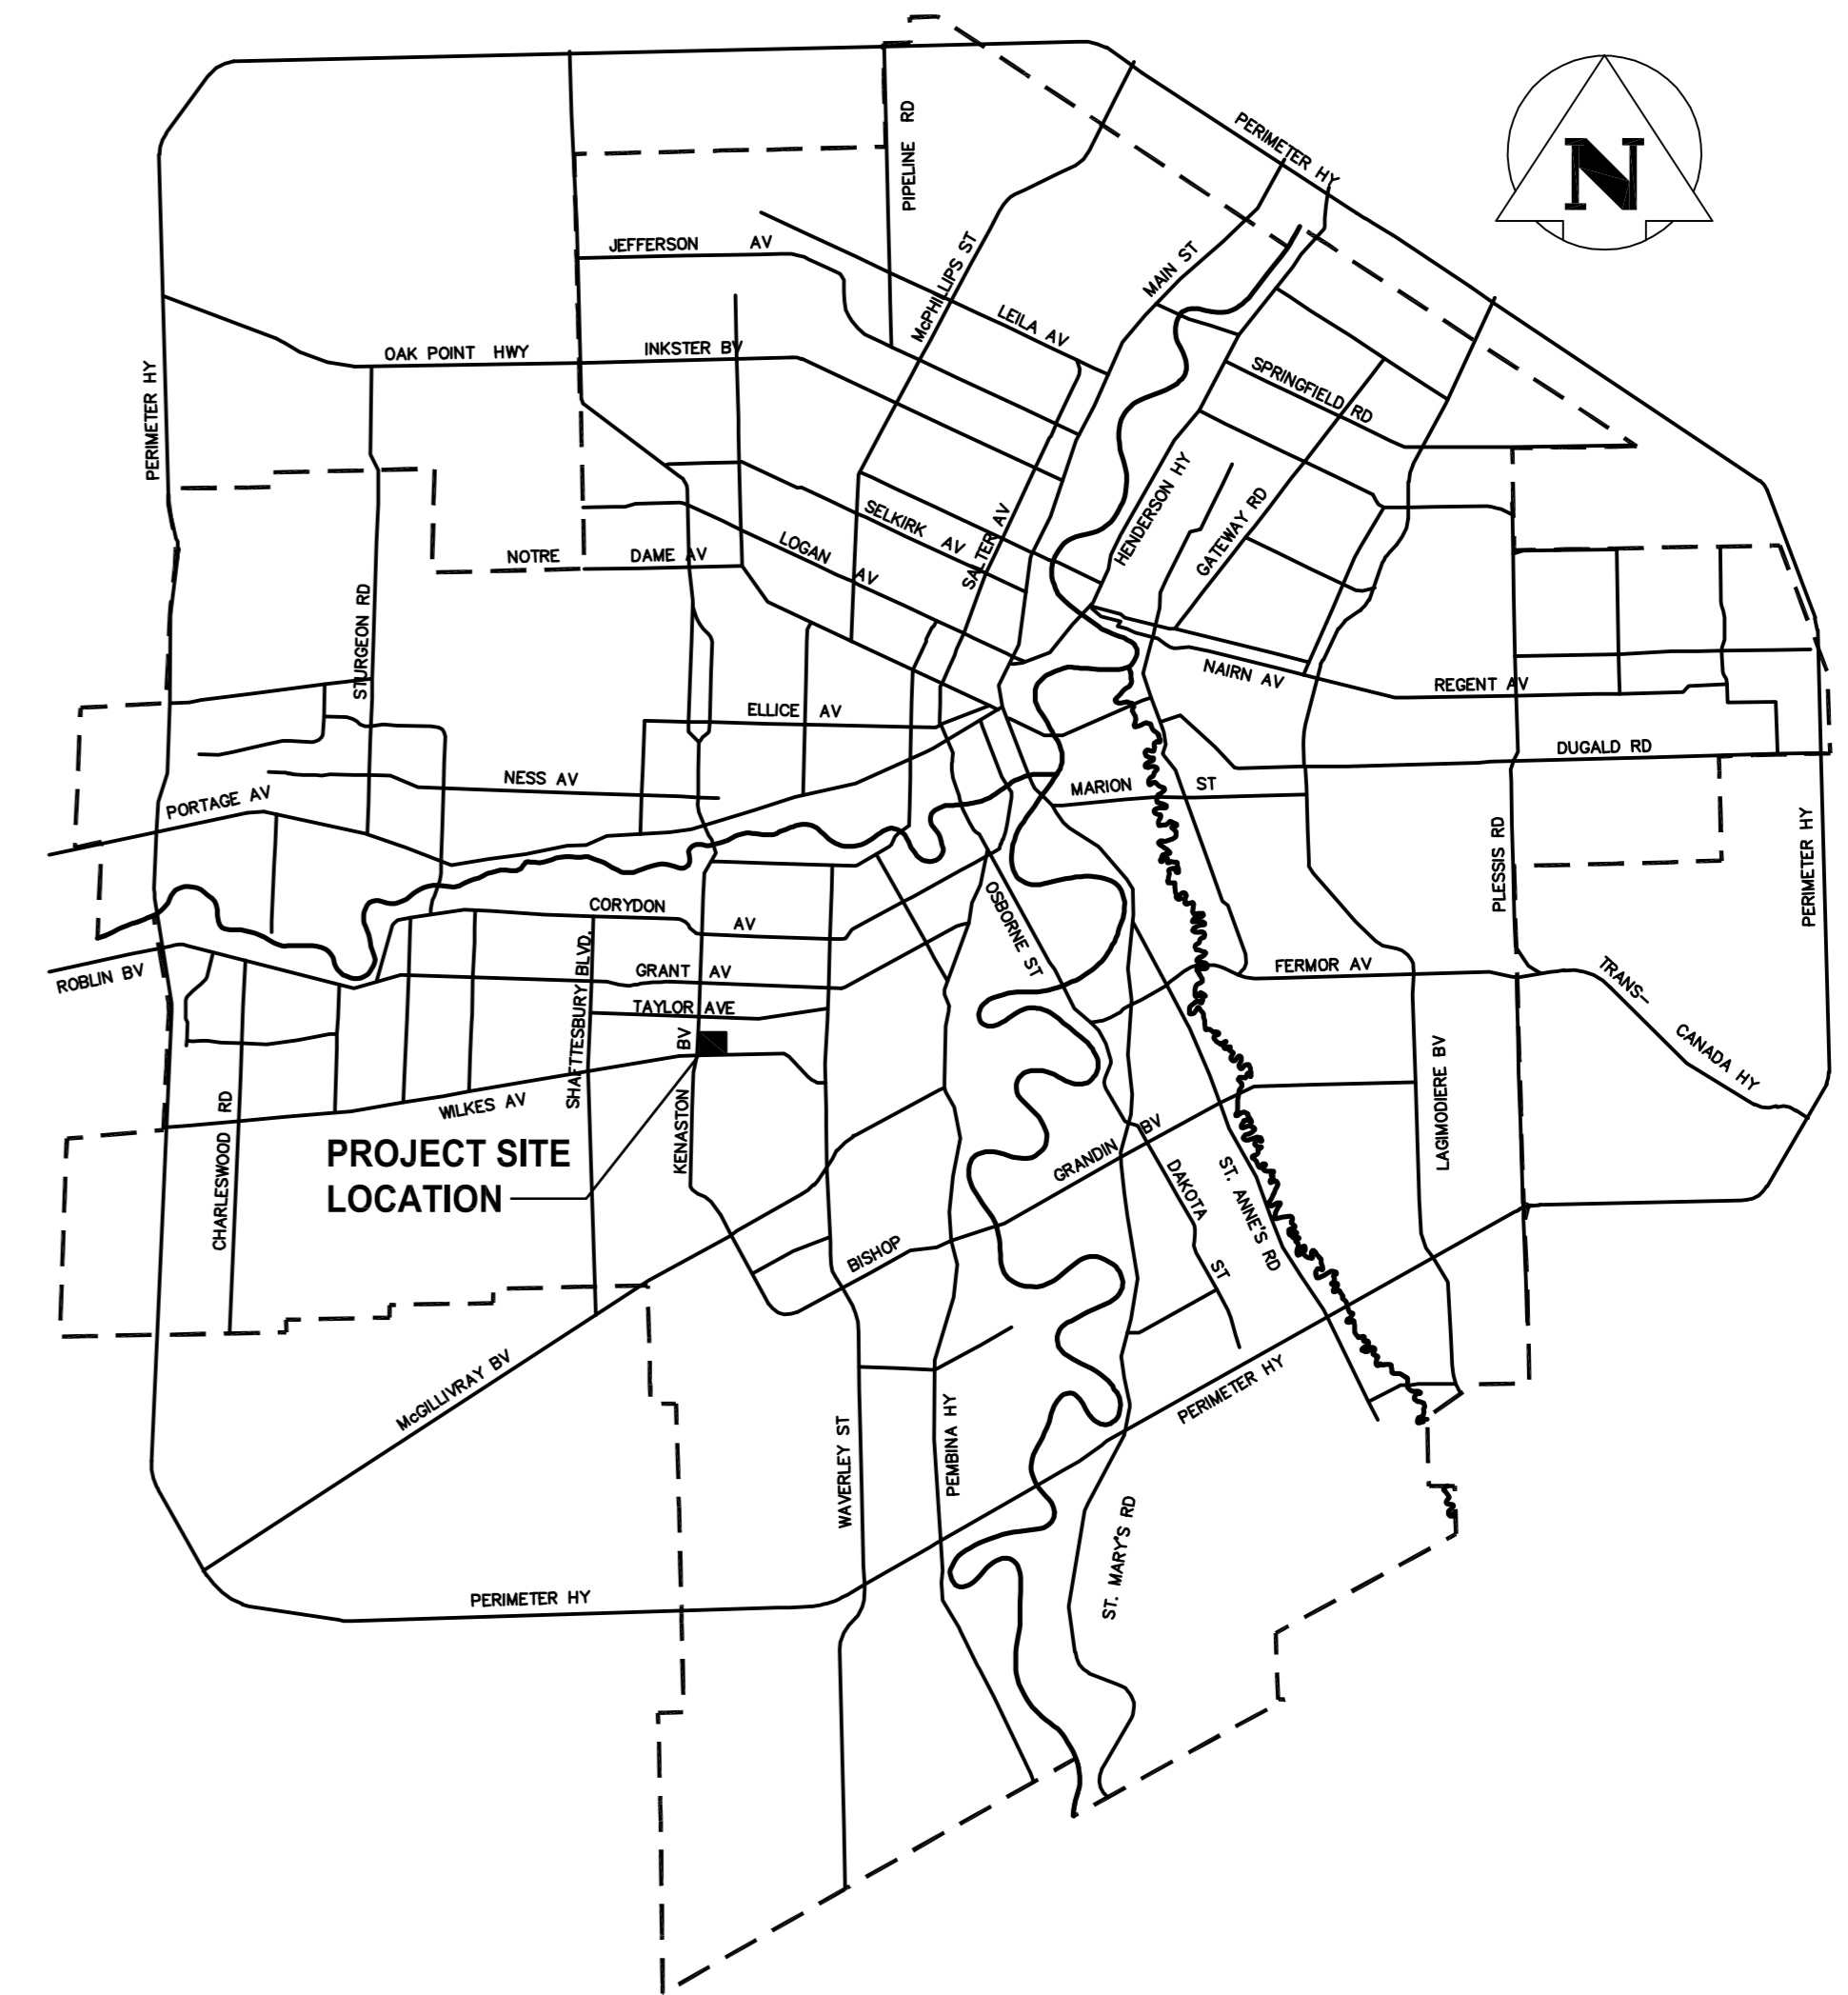

DRAWING INDEX

CITY DWG. No.	CONSULTANT DRW. No.	SHEET No.	SHEET TITLE
GENERAL			
P-3258-146	113703042-G05	1 OF 25	COVER & DRAWING LIST
CIVIL			
P-3258-147	113703042-C01	2 OF 25	SITE PLAN
05699	113703042-U23	3 OF 25	FORCEMAIN AND LAND DRAINAGE SEWER - STA. 1+250 TO PUMPING STATION
STRUCTURAL			
P-3258-148	113703042-S19	4 OF 25	STRUCTURAL - FOUNDATION PLAN, MECHANICAL & BAFFLE FLOOR FRAMING PLANS
P-3258-149	113703042-S20	5 OF 25	STRUCTURAL - MAIN FRAMING FLOOR PLAN, ROOF PLAN AND SCHEDULES
P-3258-150	113703042-S21	6 OF 25	STRUCTURAL - DETAILS, SECTIONS & GENERAL NOTES
P-3258-151	113703042-S22	7 OF 25	STRUCTURAL - BUILDING SECTIONS
P-3258-152	113703042-S23	8 OF 25	STRUCTURAL - BUILDING SECTIONS
P-3258-153	113703042-S24	9 OF 25	STRUCTURAL - DETAILS AND SECTIONS
P-3258-154	113703042-S25	10 OF 25	STRUCTURAL - DETAILS AND SECTIONS
ARCHITECTURAL			
P-3258-155	113703042-A01	11 OF 25	ARCHITECTURAL - MAIN FLOOR PLAN AND SECTION
P-3258-156	113703042-A02	12 OF 25	ARCHITECTURAL - BUILDING SECTIONS
P-3258-157	113703042-A03	13 OF 25	ARCHITECTURAL - ROOF AND WALL SECTIONS
P-3258-158	113703042-A04	14 OF 25	ARCHITECTURAL - STAIR DETAILS
P-3258-159	113703042-A05	15 OF 25	ARCHITECTURAL - ELEVATIONS
PLUMBING			
P-3258-160	113703042-P01	16 OF 25	PLUMBING - MAIN FLOOR AND BASEMENT FLOOR PLAN PLUMBING LAYOUTS AND SCHEMATICS
PROCESS			
P-3258-161	113703042-D01	17 OF 25	PROCESS - MAIN FLOOR PLAN, SECTION AND PROCESSING SCHEMATIC
P-3258-162	113703042-D02	18 OF 25	PROCESS - BASEMENT AND WET WELL FLOOR PLANS AND SECTION
P-3258-163	113703042-D03	19 OF 25	PROCESS - MISCELLANEOUS MECHANICAL DETAILS
MECHANICAL			
P-3258-164	113703042-M01	20 OF 25	HVAC - MECHANICAL FLOOR PLAN AND DETAILS
P-3258-165	113703042-M02	21 OF 25	HVAC - MECHANICAL SECTIONS
ELECTRICAL			
P-3258-166	113703042-E03	22 OF 25	ELECTRICAL - SITE PLAN AND MCC DETAILS
P-3258-167	113703042-E04	23 OF 25	ELECTRICAL - FLOOR PLANS AND DETAILS
P-3258-168	113703042-E05	24 OF 25	ELECTRICAL - MISCELLANEOUS CONTROL WIRING DIAGRAMS
P-3258-169	113703042-E06	25 OF 25	ELECTRICAL - MISCELLANEOUS CONTROL WIRING DIAGRAMS

PRELIMINARY
NOT TO BE USED FOR CONSTRUCTION



Stantec Consulting Ltd.

WINNIPEG

MANITOBA

MANITOBA

RELEASED FOR CONSTRUCTION BY:

DATE:

CONSULTANT DRAWING No.
113703042-G05

CITY DRAWING No.
P-3258-146

CAD FILE DRAWING No.
KU-COVER.dwg