
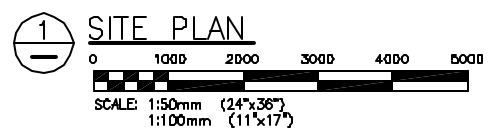
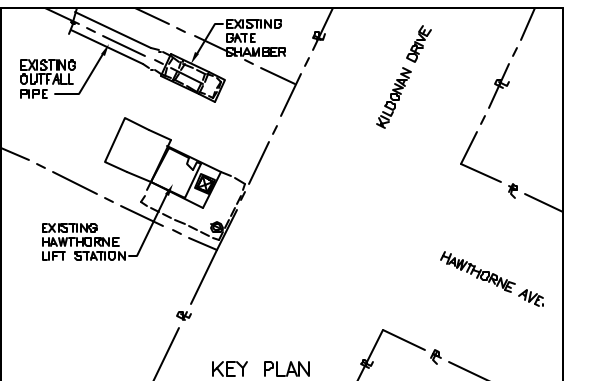


File Name: P:\Projects\2005\05-0107-13\Mech\Drawings\05-0107-13\130001.dwg Plotted By: RESCHMIDT 10/21/2005 [PLOT SCALE: 1:1]

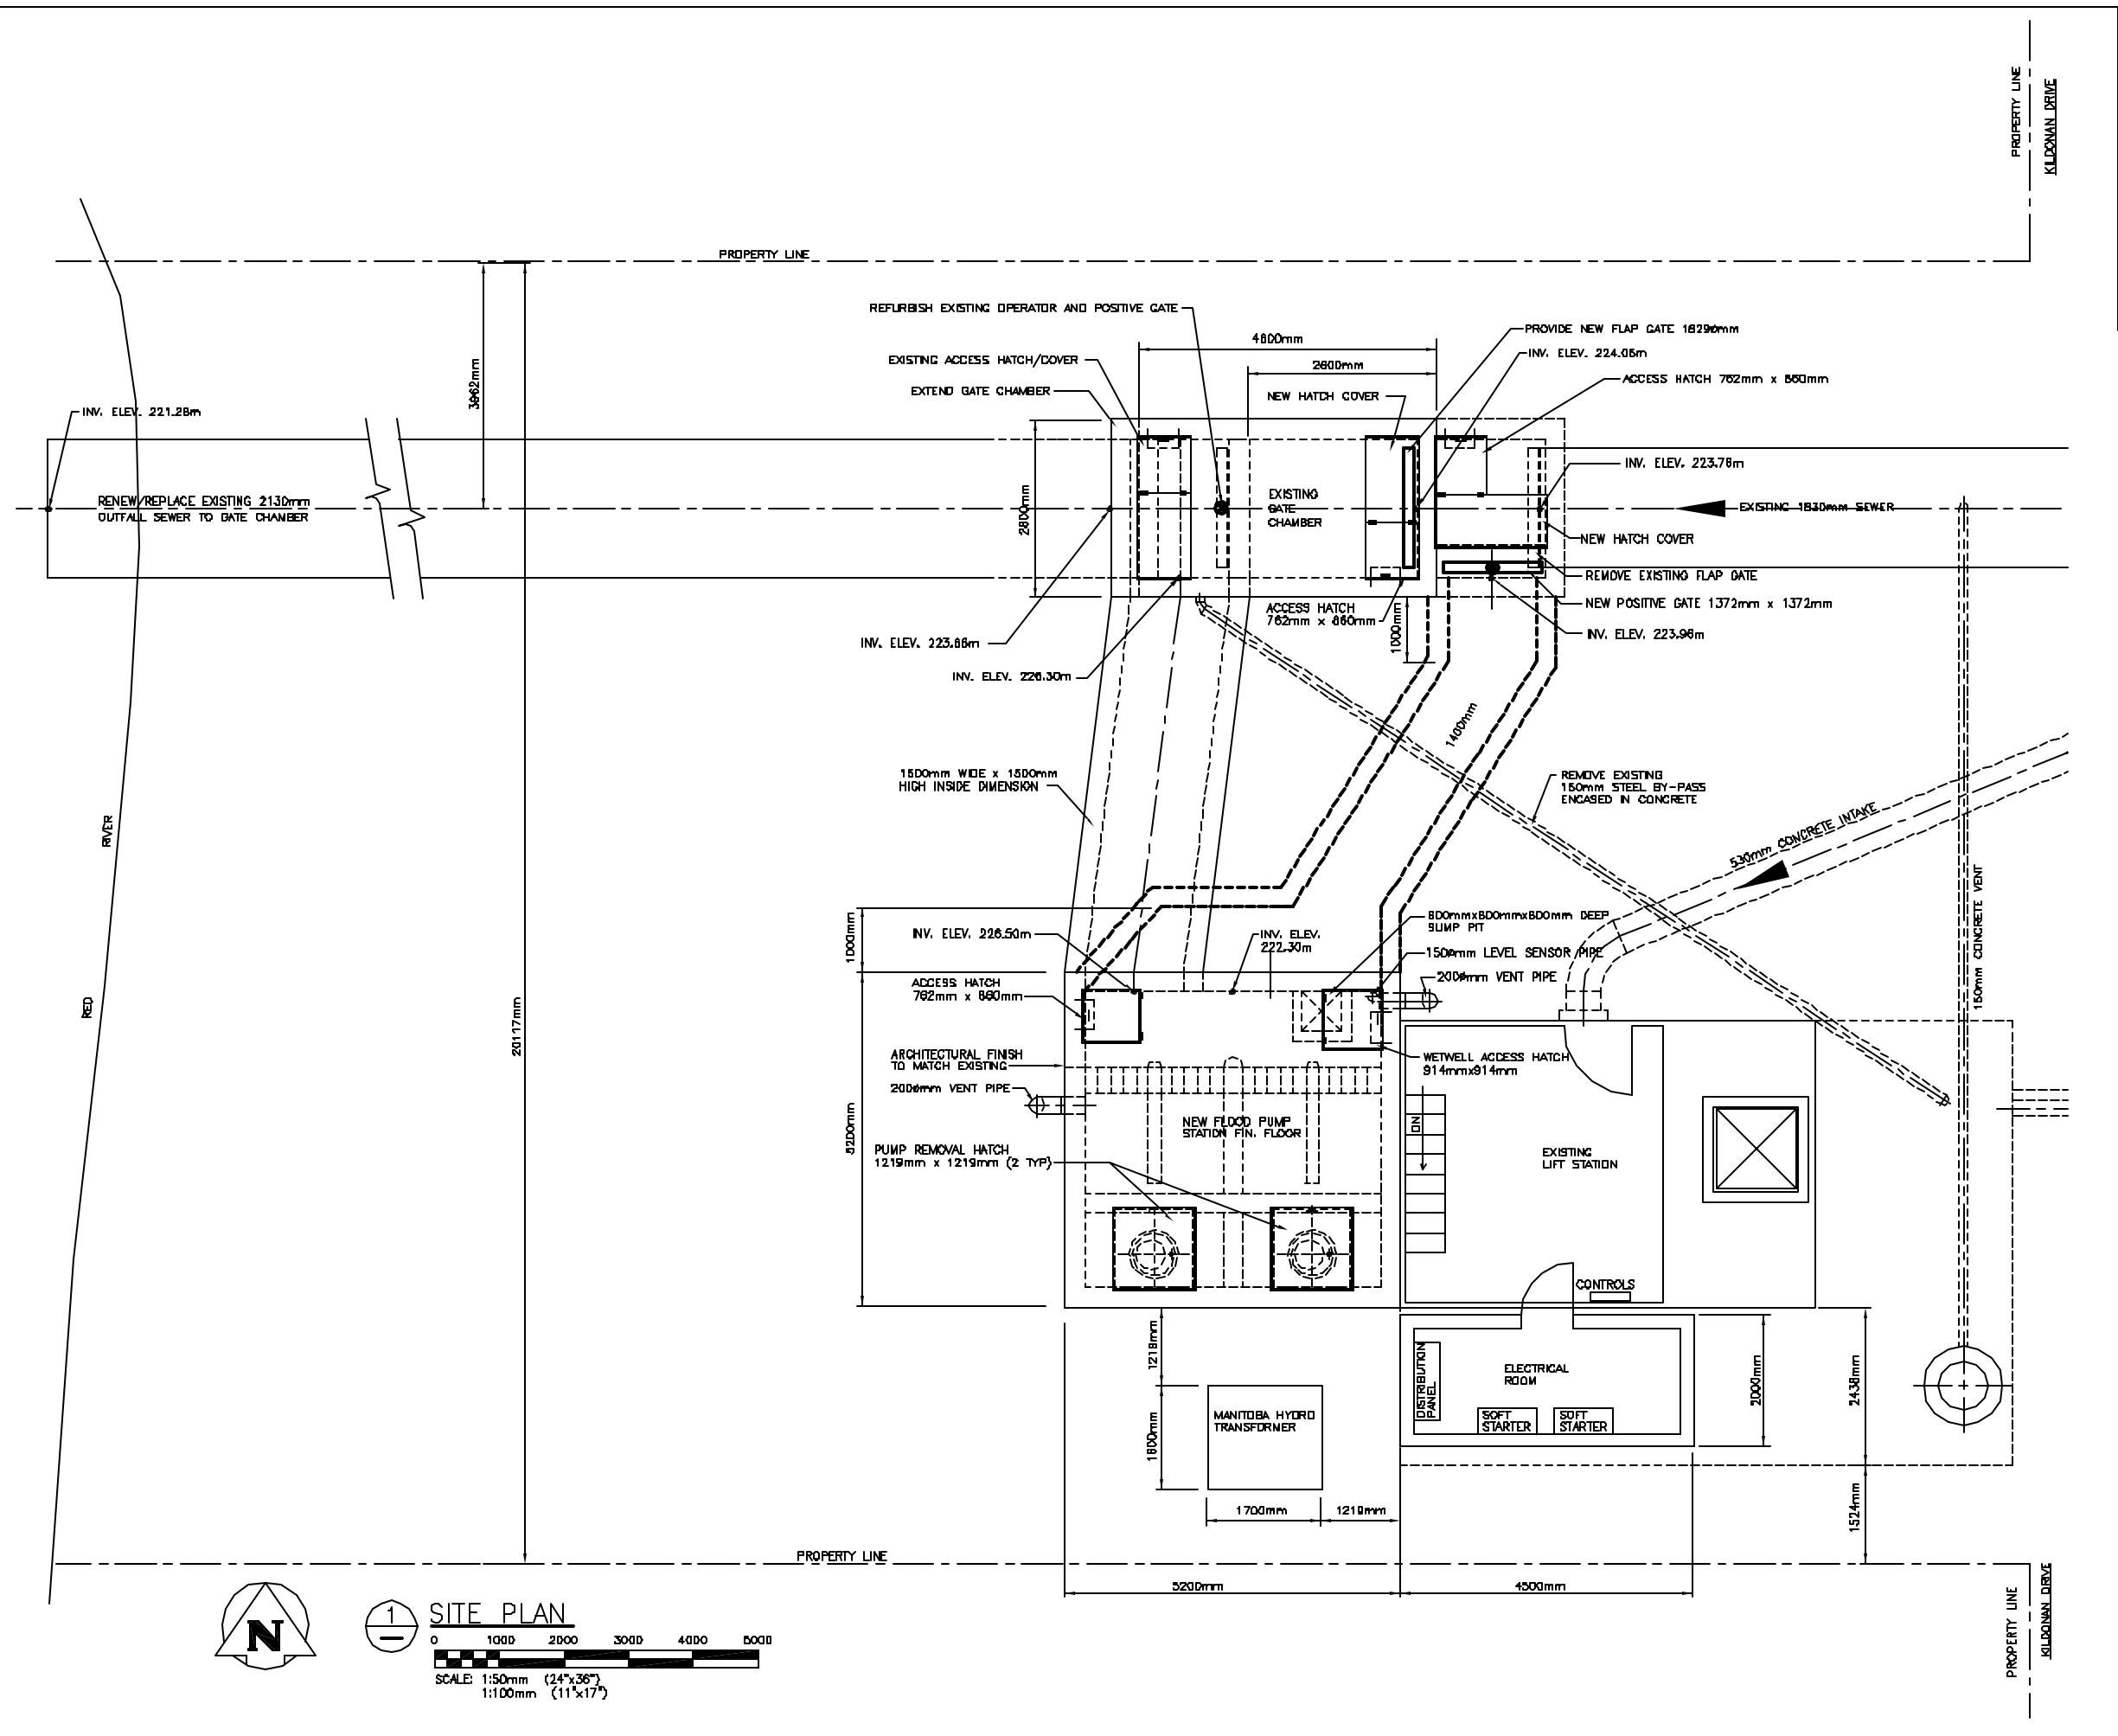

A 21/10/05 ISSUED FOR DATE SUPPLY TENDER		CS
NO.	D/M/Y	DESCRIPTION
REVISIONS / ISSUE		
A. SECTION LETTER OR DETAIL NUMBER		
B. DRAWING WHERE SECTION OR DETAIL IS DRAWN		
OR		
DRAWING WHERE SECTION OR DETAIL WAS INDICATED		
— SECTION OR DETAIL SHOWN ON SAME DRAWING		
KGS GROUP WINNIPEG (204) 868-1209 THUNDER BAY (807) 346-2233		
PROJECT		
HAWTHORNE FPS UPGRADE		
DWG. DESCRIPTION		
SITE PLAN		
DWG. STAMP		
DESIGNED BY	RED	DRAWN BY
APPROVED:	RED	VJH
SCALE:	AS NOTED	DATE:
		JUNE 2005
TIME WKS. NO.	05-0107-13 M1a	
CLIENT DWG. NO.	A	