



NOTE:
 1. FOR BEAM SCHEDULE SEE DWG WI-S0515.
 2. PROVIDE DOWELS FOR PARAPET AROUND PERIMETER OF ROOF SEE .
 NOT IN CONTRACT

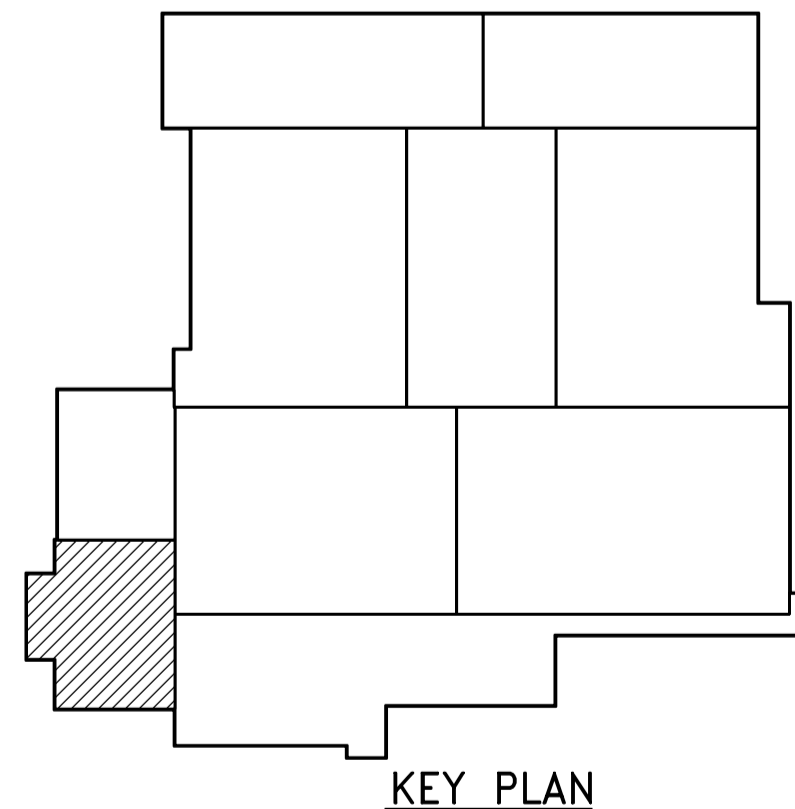

ROOF FRAMING PLAN
1:100

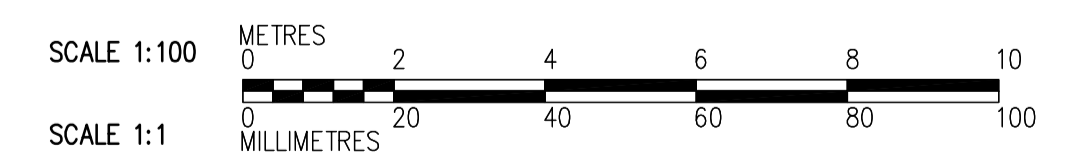

 Certificate of Authorization CH2M Hill Canada Limited (ON) No. 1441 Expiry: April 30, 2006	 Frederickson Cooper ARCHITECTS		 A Tyco International Ltd. Company		ENGINEER'S SEAL ORIGINAL SIGNED BY D. KRUGER 2005/10/28	 THE CITY OF WINNIPEG WATER AND WASTE DEPARTMENT ENGINEERING DIVISION WATER TREATMENT PLANT FOUNDATIONS AND CONCRETE STRUCTURES 1 STRUCTURAL RAW WATER PUMP STATION AREA ROOF FRAMING PLAN	CITY FILE NUMBER
	DESIGNED BY: EL	CHECKED BY: AP	CONSULTANT DRAWING NO. WI-S0141	SHEET OF			
	DRAWN BY: RL	APPROVED BY: AHL		CITY DRAWING NUMBER 1-0601-A-80141-001-02D			
	SCALE: 1:100	RELEASED FOR CONSTRUCTION BY: R. SOROKOWSKI					
NO. REVISIONS DATE BY		DATE: 2005/07/08	DATE: 2005/10/28				