


THIRD FLOOR PLAN
1:300

FOUNDATIONS AND CONCRETE STRUCTURES 1 CONTRACT

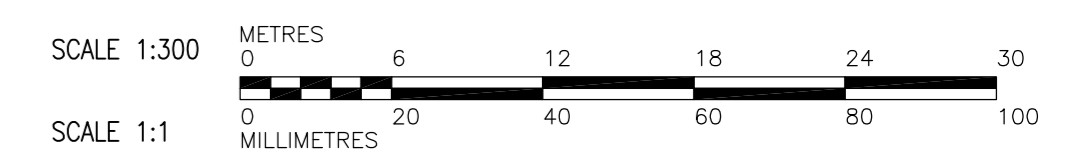

 Certificate of Authorization CH2M Hill Canada Limited (ON) No. 1441 Expiry: April 30, 2006	B.M. ELEV.	 Frederickson Cooper ARCHITECTS	 A Tyco International Ltd. Company	ENGINEER'S SEAL	 THE CITY OF WINNIPEG WATER AND WASTE DEPARTMENT ENGINEERING DIVISION WATER TREATMENT PLANT FOUNDATIONS AND CONCRETE STRUCTURES 1 STRUCTURAL OVERALL BUILDING THIRD FLOOR AND CONTRACT LIMIT PLAN	CITY FILE NUMBER
	DESIGNED BY: JC			CHECKED BY: AP		ORIGINAL SIGNED BY: D. KRUGER
	DRAWN BY: MS	APPROVED BY: DJT	2005/10/28	CITY DRAWING NUMBER		
	SCALE: 1:300	RELEASED FOR CONSTRUCTION BY: R. SOROKOWSKI	CONSULTANT DRAWING NO. WB-SB130	1-060B-A-58130-001-000		
00 ISSUED FOR TENDER	05/10/28 JC	DATE: 2005/09/21	DATE: 2005/10/28			
NO. REVISIONS	DATE BY					