
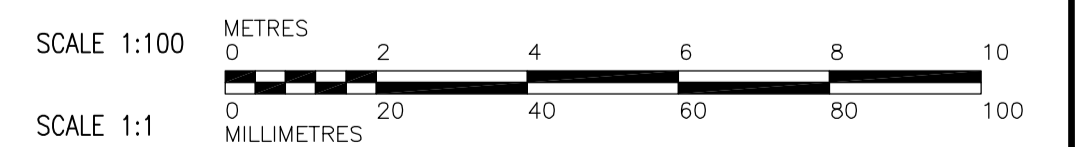


THIRD FLOOR PLAN
1:100

LEGEND

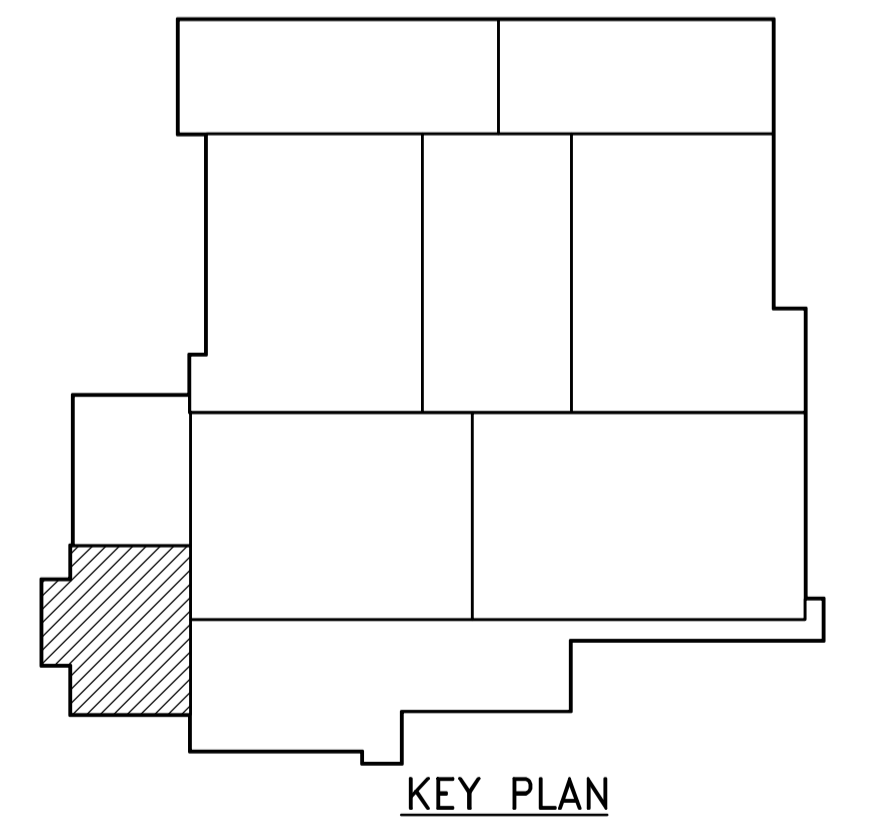

<p>Certificate of Authorization Earth Tech Canada Inc. No. 730 Expiry: April 30, 2006</p>	B.M. ELEV.	<p>Frederickson Cooper ARCHITECTS</p>	<p>A Tyco International Ltd. Company</p>	ENGINEER'S SEAL	<p>THE CITY OF WINNIPEG WATER AND WASTE DEPARTMENT ENGINEERING DIVISION</p>	<p>WATER TREATMENT PLANT INLET WORKS AND RAW WATER PUMPING FOUNDATIONS AND CONCRETE STRUCTURES 1</p>	CITY FILE NUMBER
				DESIGNED BY SBW			CHECKED BY SRB
		DRAWN BY JBC	APPROVED BY DJT	2005/10/28			
	0 ISSUED FOR TENDER 05/10/28 JBC	SCALE: 1:100	RELEASED FOR CONSTRUCTION BY: R. SOROKOWSKI	CONSULTANT DRAWING NO. WI-M9131			PIPE EMBEDS RAW WATER PUMP STATION AREA THIRD FLOOR PLAN
	NO. REVISIONS	DATE	BY	DATE			
		2005/08/19		2005/10/28			