



- NOTES:**
- FOR CORNER REINF SEE **4** WB-S0442
  - CENTERLINE OF PIPE OPNG:  
NORTHING: 5524036.069  
EASTING: 647835.819
  - CENTERLINE OF PIPE OPNG:  
NORTHING: 5524029.071  
EASTING: 647831.455
  - REFER TO DRAWING WI-0515 FOR COLUMN SCHEDULE.

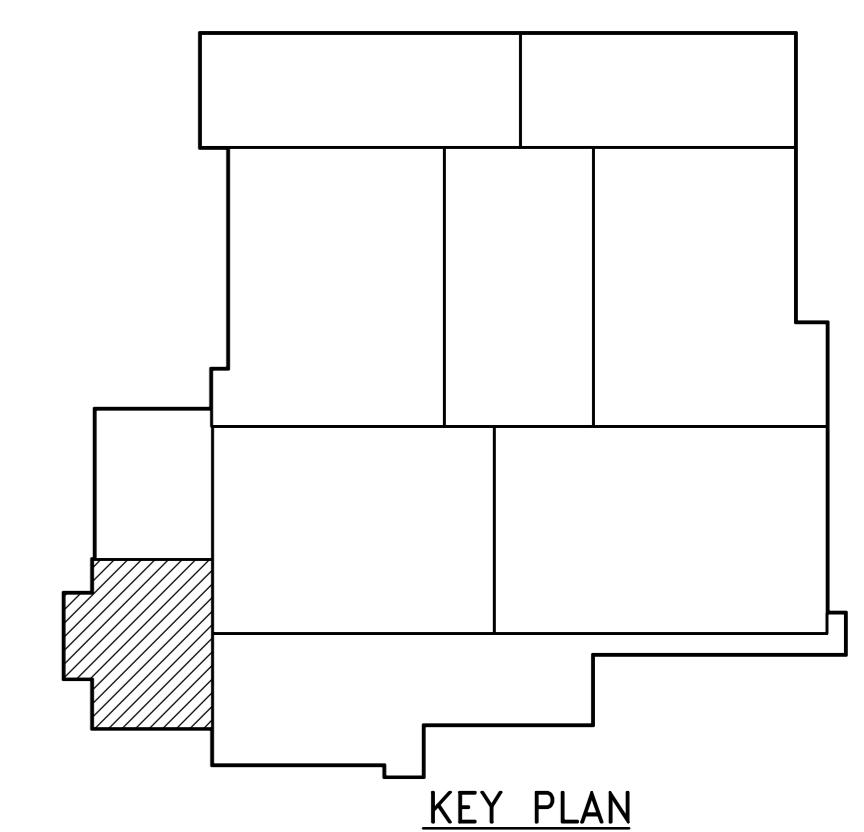

- REBARS LEGEND:**
- TOP BARS
  - BOTTOM BARS
  - DRAIN PIPE CENTERLINE



LOWER LEVEL PLAN  
1:100

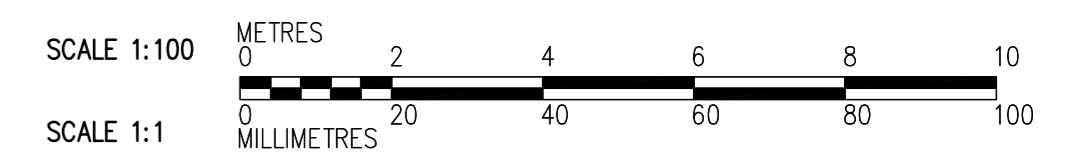

**APEGM**  
Certificate of Authorization  
CH2M Hill Canada Limited (ON)  
No. 1441 Expiry: April 30, 2006

B.M. ELEV.			
00	ISSUED FOR TENDER	05/10/28	EL
NO.	REVISIONS	DATE	BY
		2005/07/06	

<b>CH2MHILL</b> Frederickson Cooper ARCHITECTS		<b>EarthTech</b> A Tyco International Ltd. Company	
DESIGNED BY: EL	CHECKED BY: AP	ENGINEER'S SEAL	
DRAWN BY: RL	APPROVED BY: DJT	ORIGINAL SIGNED BY: D. KRUGER	
SCALE: 1:100	RELEASED FOR CONSTRUCTION BY: R. SOROKOWSKI	2005/10/28	
DATE: 2005/07/06	DATE: 2005/10/28	CONSULTANT DRAWING NO. WI-S0101	

**THE CITY OF WINNIPEG**  
WATER AND WASTE DEPARTMENT  
ENGINEERING DIVISION

WATER TREATMENT PLANT

FOUNDATIONS AND CONCRETE STRUCTURES 1

STRUCTURAL  
RAW WATER PUMP STATION AREA  
LOWER LEVEL PLAN

CITY FILE NUMBER  
SHEET OF  
CITY DRAWING NUMBER  
**1-0601-A-S0101-001-000**