

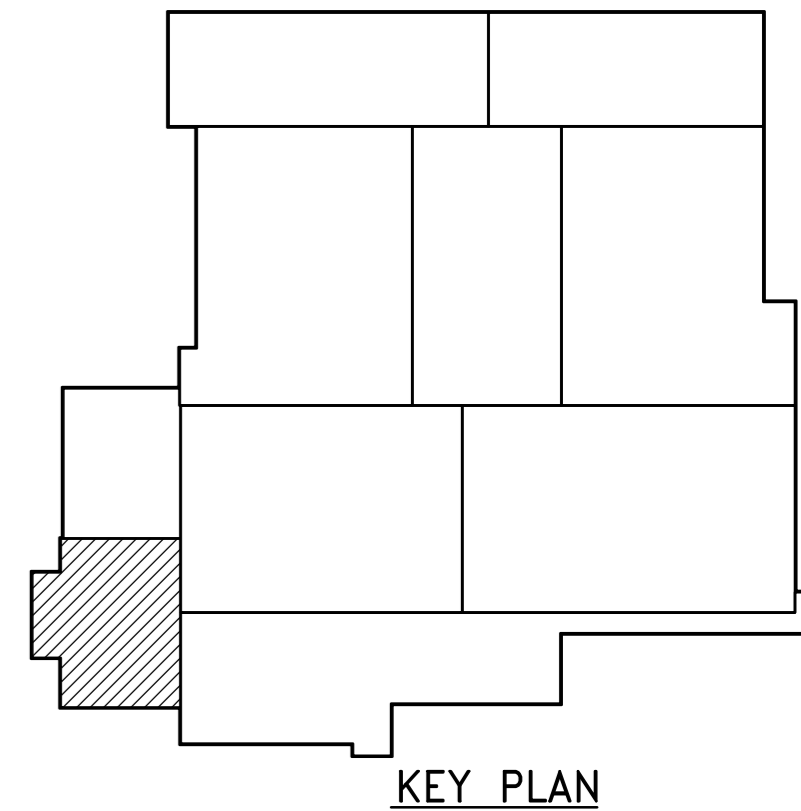
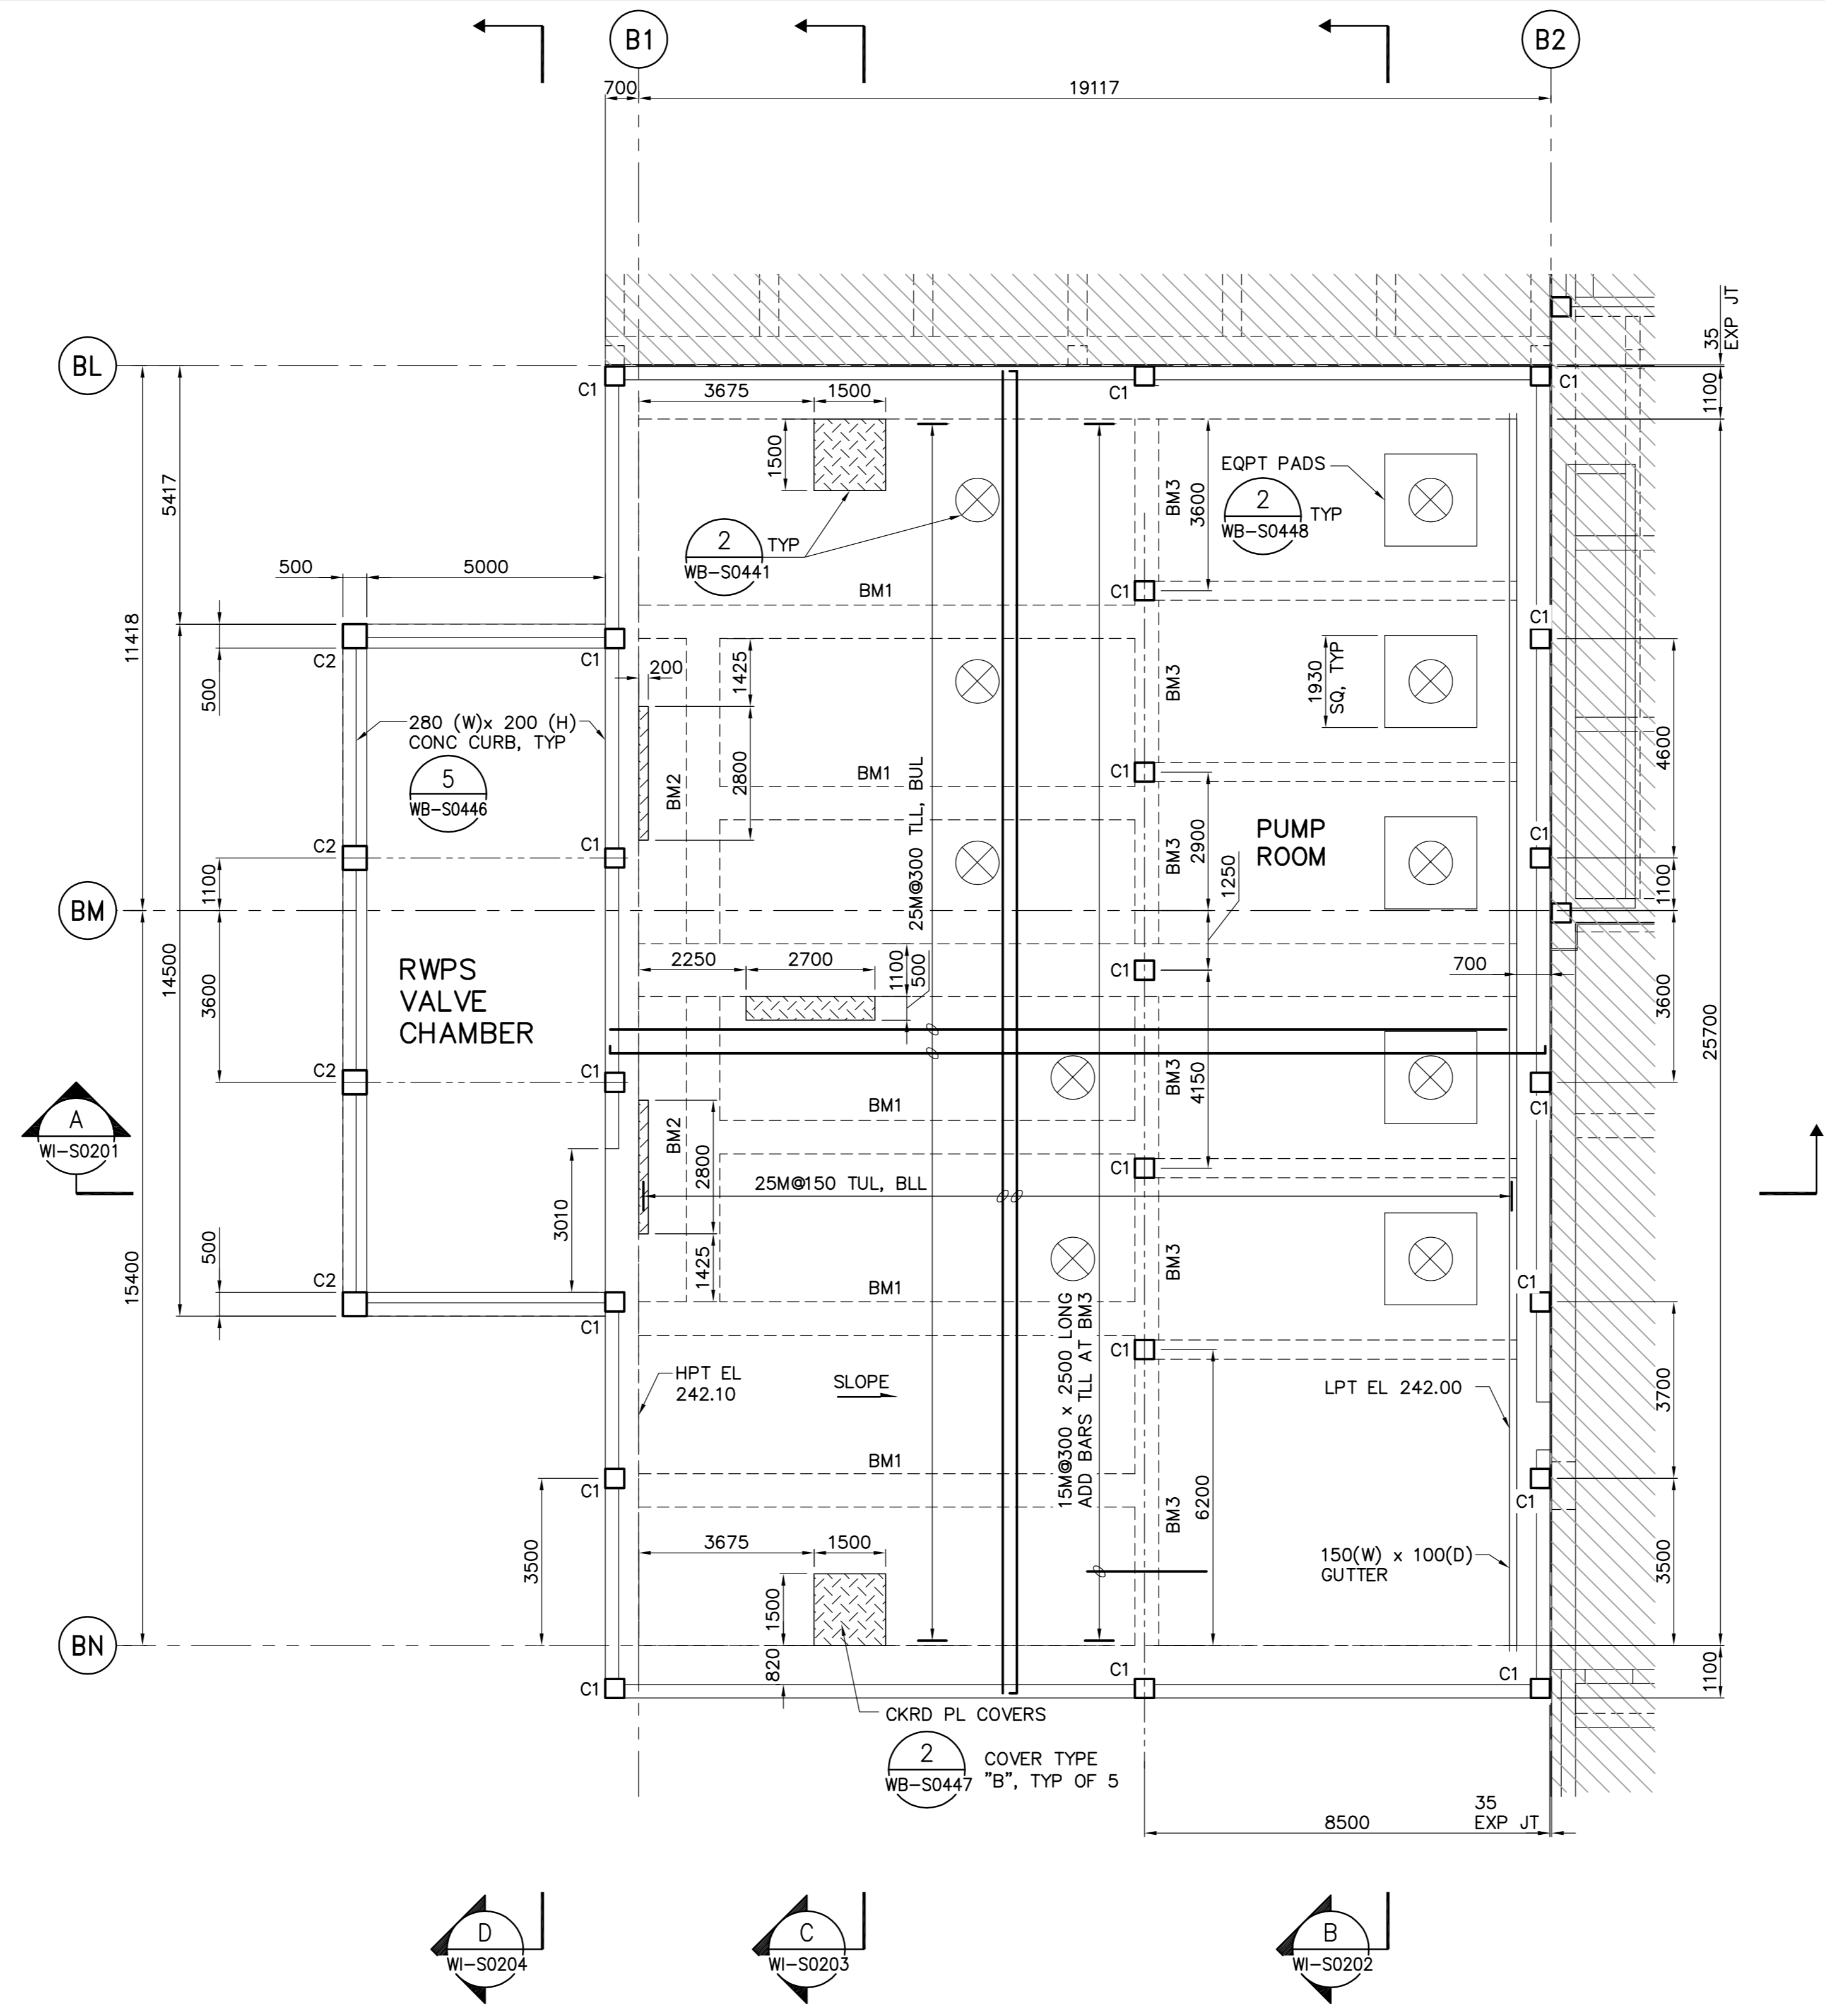


- NOTES:**
- DESIGN LIVE LOAD IS 14.4 kPa.
 - FOR BEAM AND COLUMN SCHEDULE SEE DWG WI-S0515.

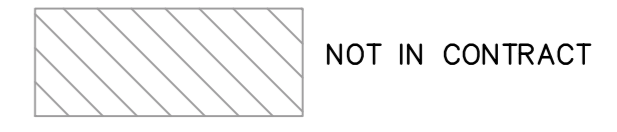

THIRD FLOOR PLAN
1:100

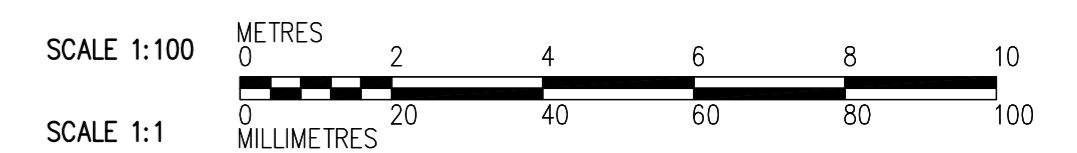

<p>APEGM Certificate of Authorization CH2M Hill Canada Limited (ON) No. 1441 Expiry: April 30, 2006</p>	<p>Frederickson Cooper ARCHITECTS</p>		<p>A Tyco International Ltd. Company</p>		ENGINEER'S SEAL ORIGINAL SIGNED BY D. KRUGER 2005/10/28	<p>THE CITY OF WINNIPEG WATER AND WASTE DEPARTMENT ENGINEERING DIVISION</p>
	DESIGNED BY: EL DRAWN BY: RL SCALE: 1:100		CHECKED BY: AP APPROVED BY: DJT RELEASED FOR CONSTRUCTION BY: R. SOROKOWSKI		CITY FILE NUMBER SHEET OF	
	NO. 00 ISSUED FOR TENDER DATE: 05/10/28 BY: EL		DATE: 2005/07/08 DATE: 2005/10/28		CONSULTANT DRAWING NO. WI-S0131	
	FOUNDATIONS AND CONCRETE STRUCTURES 1		STRUCTURAL RAW WATER PUMP STATION AREA THIRD FLOOR PLAN		CITY DRAWING NUMBER 1-0601-A-S031-001-00D	