



**NOTE:**  
1. FOR BEAM SCHEDULE SEE DWG WI-S0515.

NOT IN CONTRACT

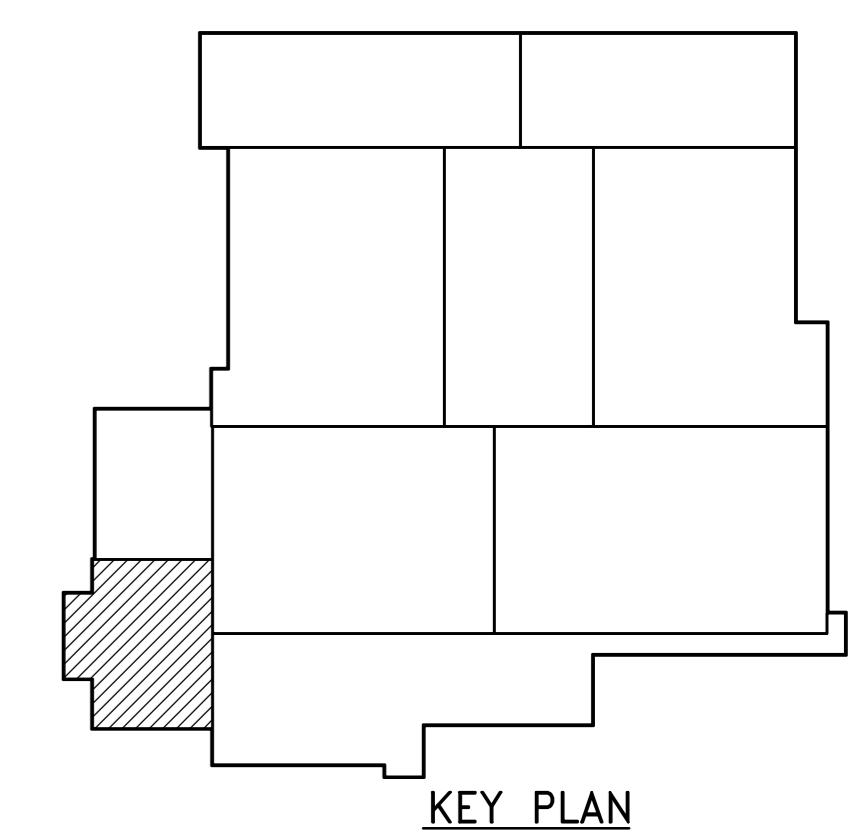

**ROOF FRAMING PLAN**  
1:100

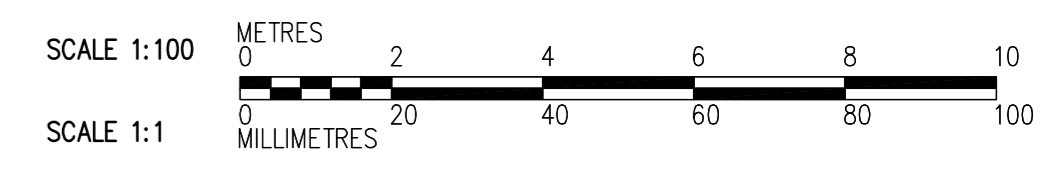

 <b>Certificate of Authorization</b> CH2M Hill Canada Limited (ON) No. 1441 Expiry: April 30, 2006	B.M. ELEV.	 Frederickson Cooper ARCHITECTS  A Tyco International Ltd. Company	ENGINEER'S SEAL	 <b>THE CITY OF WINNIPEG</b> WATER AND WASTE DEPARTMENT ENGINEERING DIVISION WATER TREATMENT PLANT FOUNDATIONS AND CONCRETE STRUCTURES 1 STRUCTURAL RAW WATER PUMP STATION AREA ROOF FRAMING PLAN	CITY FILE NUMBER	
	DESIGNED BY: EL		CHECKED BY: AP		ORIGINAL SIGNED BY: D. KRUGER	SHEET OF
	DRAWN BY: RL		APPROVED BY: DJT		2005/10/28	CITY DRAWING NUMBER
	SCALE: 1:100		RELEASED FOR CONSTRUCTION BY: R. SOROKOWSKI		CONSULTANT DRAWING NO. WI-S0141	<b>1-0601-A-S0141-001-00D</b>
00 ISSUED FOR TENDER	05/10/28 EL	DATE: 2005/07/08	DATE: 2005/10/28			
NO. REVISIONS	DATE BY					