




# THE CITY OF WINNIPEG

WATER AND WASTE DEPARTMENT  
ENGINEERING DIVISION

## WINNIPEG WATER TREATMENT PROGRAM FOUNDATIONS AND CONCRETE STRUCTURES 1 RAW WATER PUMP STATION AREA

BID OPPORTUNITY No. 650-2005

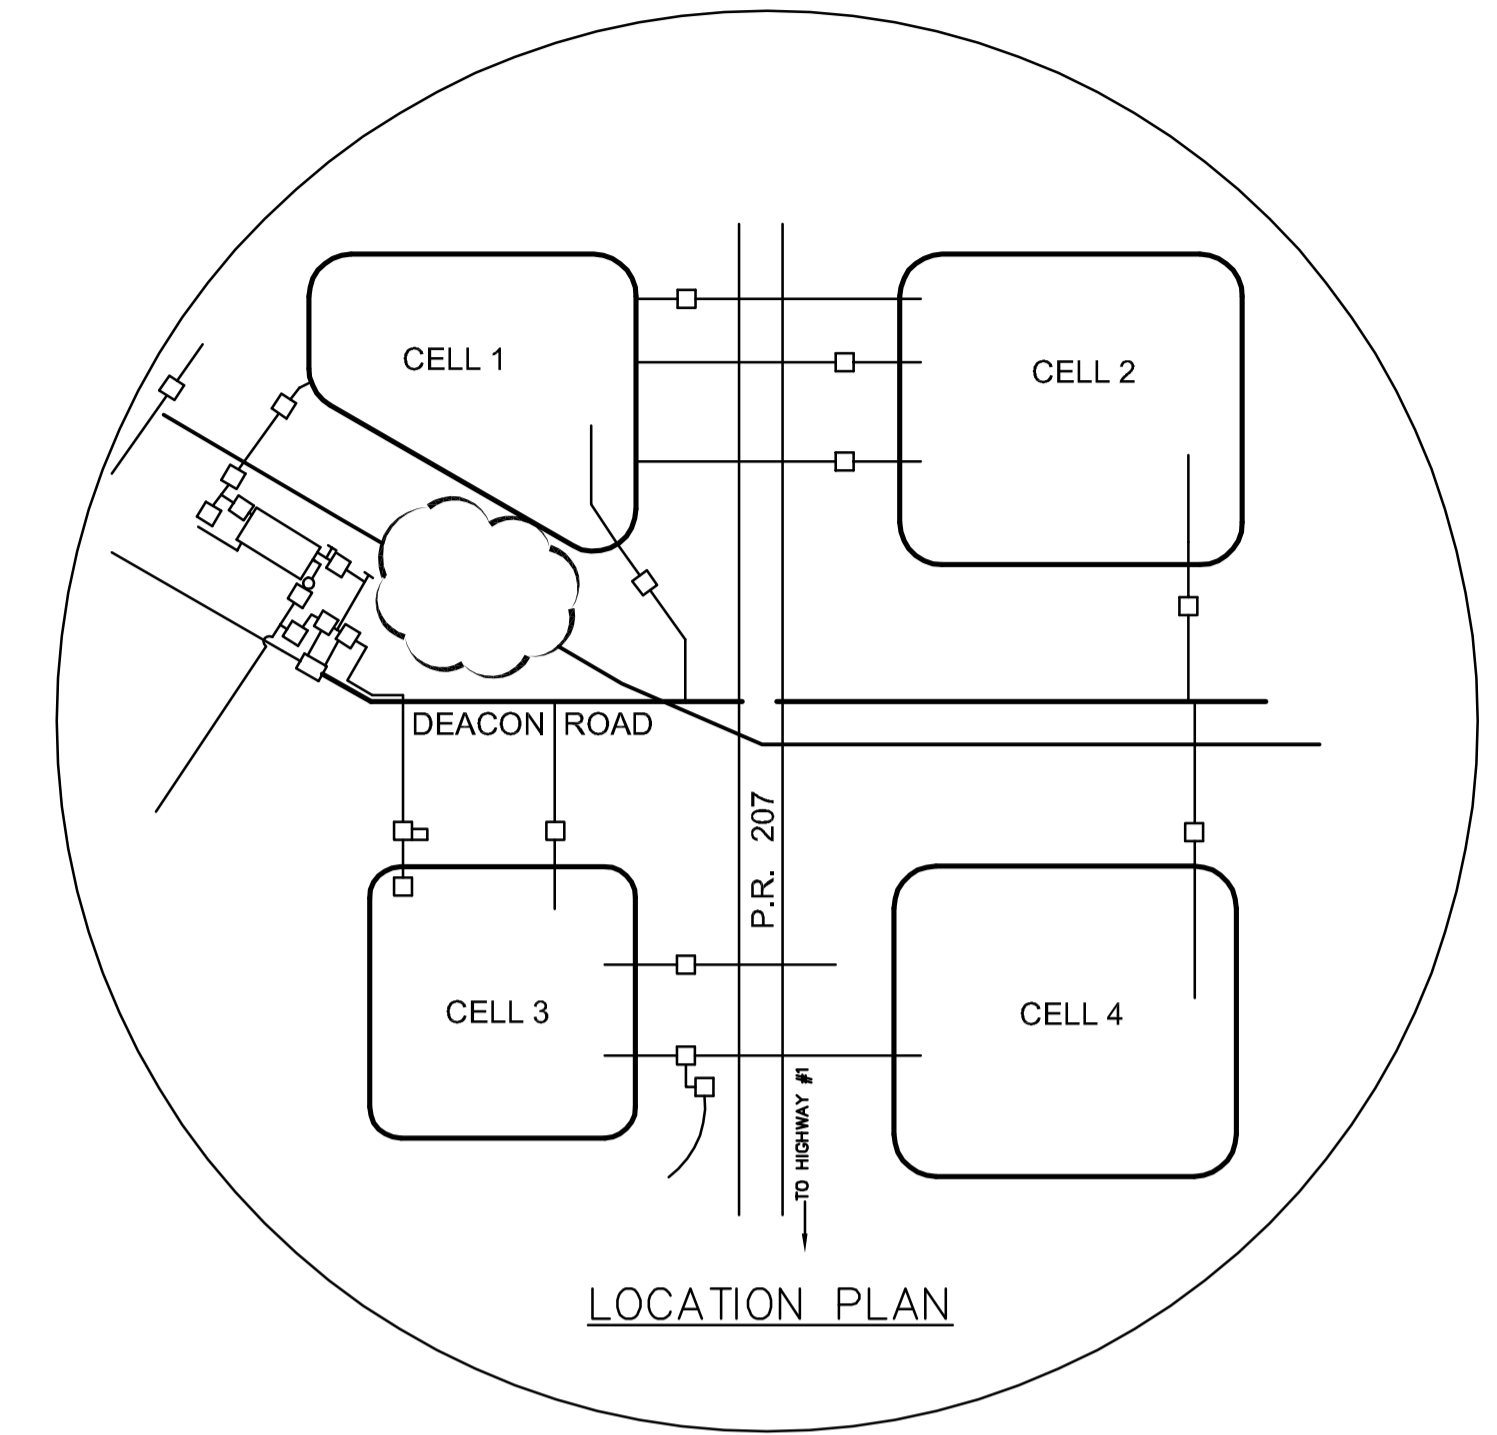

DRAWING INDEX

CITY DRAWING NUMBER	CONSULTANT DRAWING NUMBER	DRAWING TITLE
<u>CIVIL</u>		
	WM-C0165	EXISTING SITE PLAN AND SURVEY PLAN (NIC)
<u>STRUCTURAL</u>		
1-0601M-D-S9001-001-000	WM-S9001	LEGEND, GENERAL NOTES AND ABBREVIATIONS
1-0601B-B-F8105-001-000	WB-F8105	OVERALL BUILDING PILING AND CONTRACT LIMIT PLAN
1-0601B-A-S8100-001-000	WB-S8100	OVERALL BUILDING LOWER LEVEL AND CONTRACT LIMIT PLAN
1-0601B-A-S8110-001-000	WB-S8110	OVERALL BUILDING FIRST FLOOR AND CONTRACT LIMIT PLAN
1-0601B-A-S8130-001-000	WB-S8130	OVERALL BUILDING THIRD FLOOR AND CONTRACT LIMIT PLAN
1-0601B-A-S8140-001-000	WB-S8140	OVERALL BUILDING ROOF FRAMING AND CONTRACT LIMIT PLAN
1-0601B-B-F0105-001-000	WI-F0105	RAW WATER PUMP STATION AREA - PILING PLAN
1-0601I-A-S0101-001-000	WI-S0101	RAW WATER PUMP STATION AREA - LOWER LEVEL PLAN
1-0601I-A-S0111-001-000	WI-S0111	RAW WATER PUMP STATION AREA - FIRST FLOOR PLAN
1-0601I-A-S0131-001-000	WI-S0131	RAW WATER PUMP STATION AREA - THIRD FLOOR PLAN
1-0601I-A-S0141-001-000	WI-S0141	RAW WATER PUMP STATION AREA - ROOF FRAMING PLAN
1-0601I-A-S0201-001-000	WI-S0201	RAW WATER PUMP STATION AREA - SECTION
1-0601I-A-S0202-001-000	WI-S0202	RAW WATER PUMP STATION AREA - SECTION
1-0601I-A-S0203-001-000	WI-S0203	RAW WATER PUMP STATION AREA - SECTION
1-0601I-A-S0204-001-000	WI-S0204	RAW WATER PUMP STATION AREA - SECTION
1-0601B-D-S0441-001-000	WB-S0441	STANDARD DETAILS
1-0601B-D-S0442-001-000	WB-S0442	STANDARD DETAILS
1-0601B-D-S0443-001-000	WB-S0443	STANDARD DETAILS
1-0601B-D-S0444-001-000	WB-S0444	STANDARD DETAILS
1-0601B-D-S0445-001-000	WB-S0445	STANDARD DETAILS
1-0601B-D-S0446-001-000	WB-S0446	STANDARD DETAILS
1-0601B-D-S0447-001-000	WB-S0447	STANDARD DETAILS
1-0601B-D-S0448-001-000	WB-S0448	STANDARD DETAILS
1-0601I-D-S0505-001-000	WI-S0505	RAW WATER PUMP STATION AREA - PILING SCHEDULE
1-0601I-D-S0515-001-000	WI-S0515	RAW WATER PUMP STATION AREA - COLUMN AND BEAM SCHEDULES
<u>PROCESS MECHANICAL</u>		
1-0601B-D-M9441-001-000	WB-M9441	STANDARD DETAILS
<u>PIPE EMBEDS</u>		
1-0601I-A-M9101-001-000	WI-M9101	RAW WATER PUMP STATION AREA - LOWER LEVEL PLAN
1-0601I-A-M9131-001-000	WI-M9131	RAW WATER PUMP STATION AREA - THIRD FLOOR PLAN
1-0601I-A-M9202-001-000	WI-M9202	RAW WATER PUMP STATION AREA - SECTION
<u>PLUMBING</u>		
1-0601I-A-H9122-001-000	WI-H9122	PIPE EMBEDS - RAW WATER PUMP STATION AREA PLANS

