




**ROOF PLAN**  
SCALE 1:100

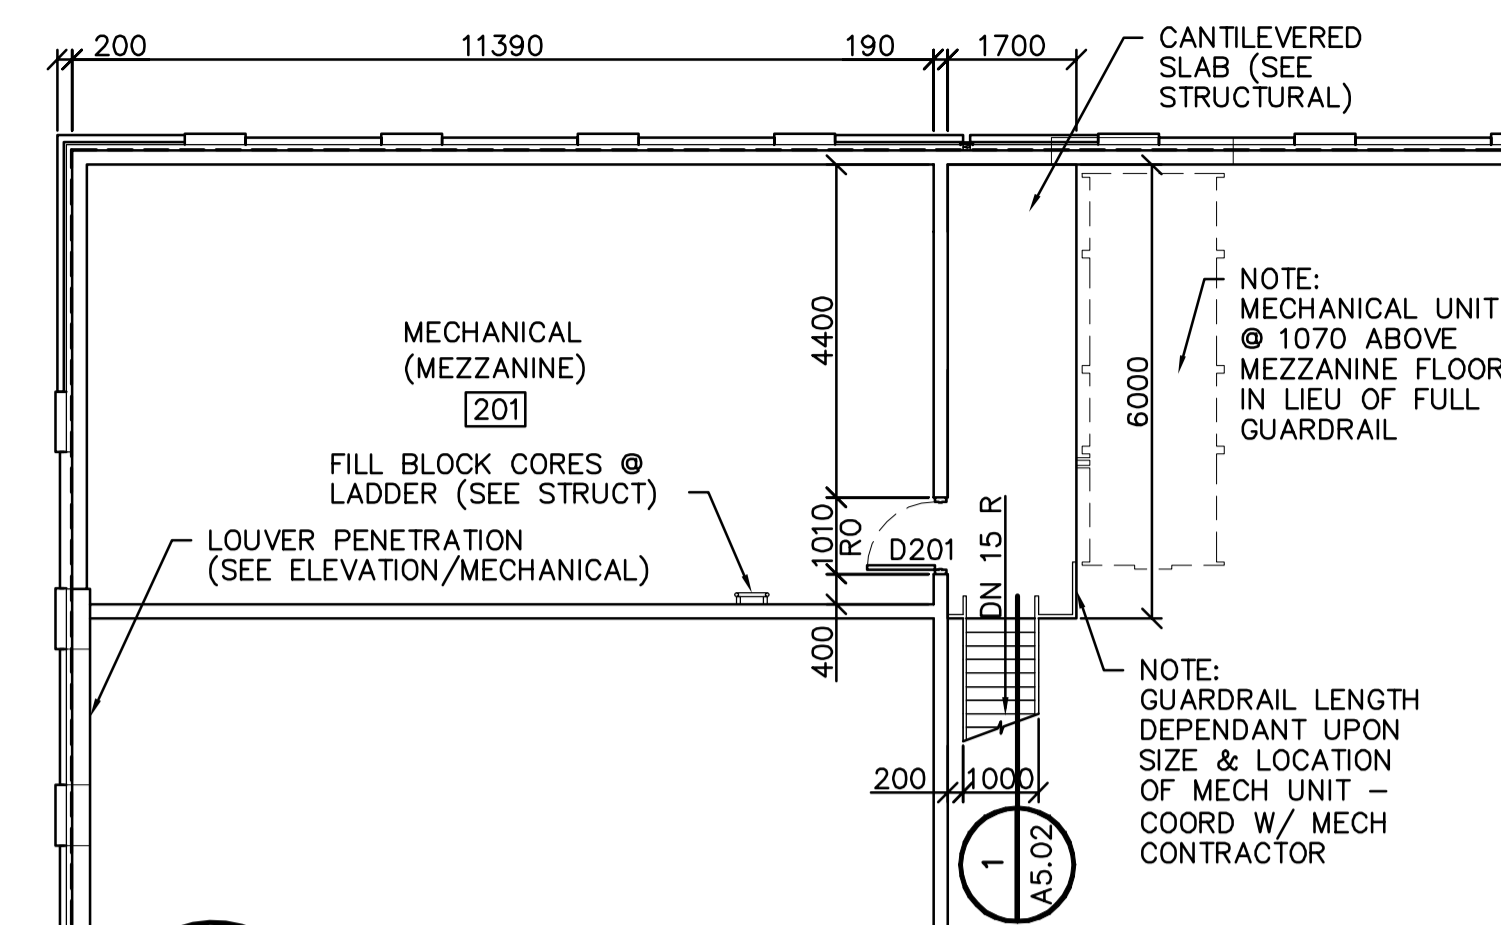


**MEZZANINE FLOOR PLAN**  
SCALE 1:100

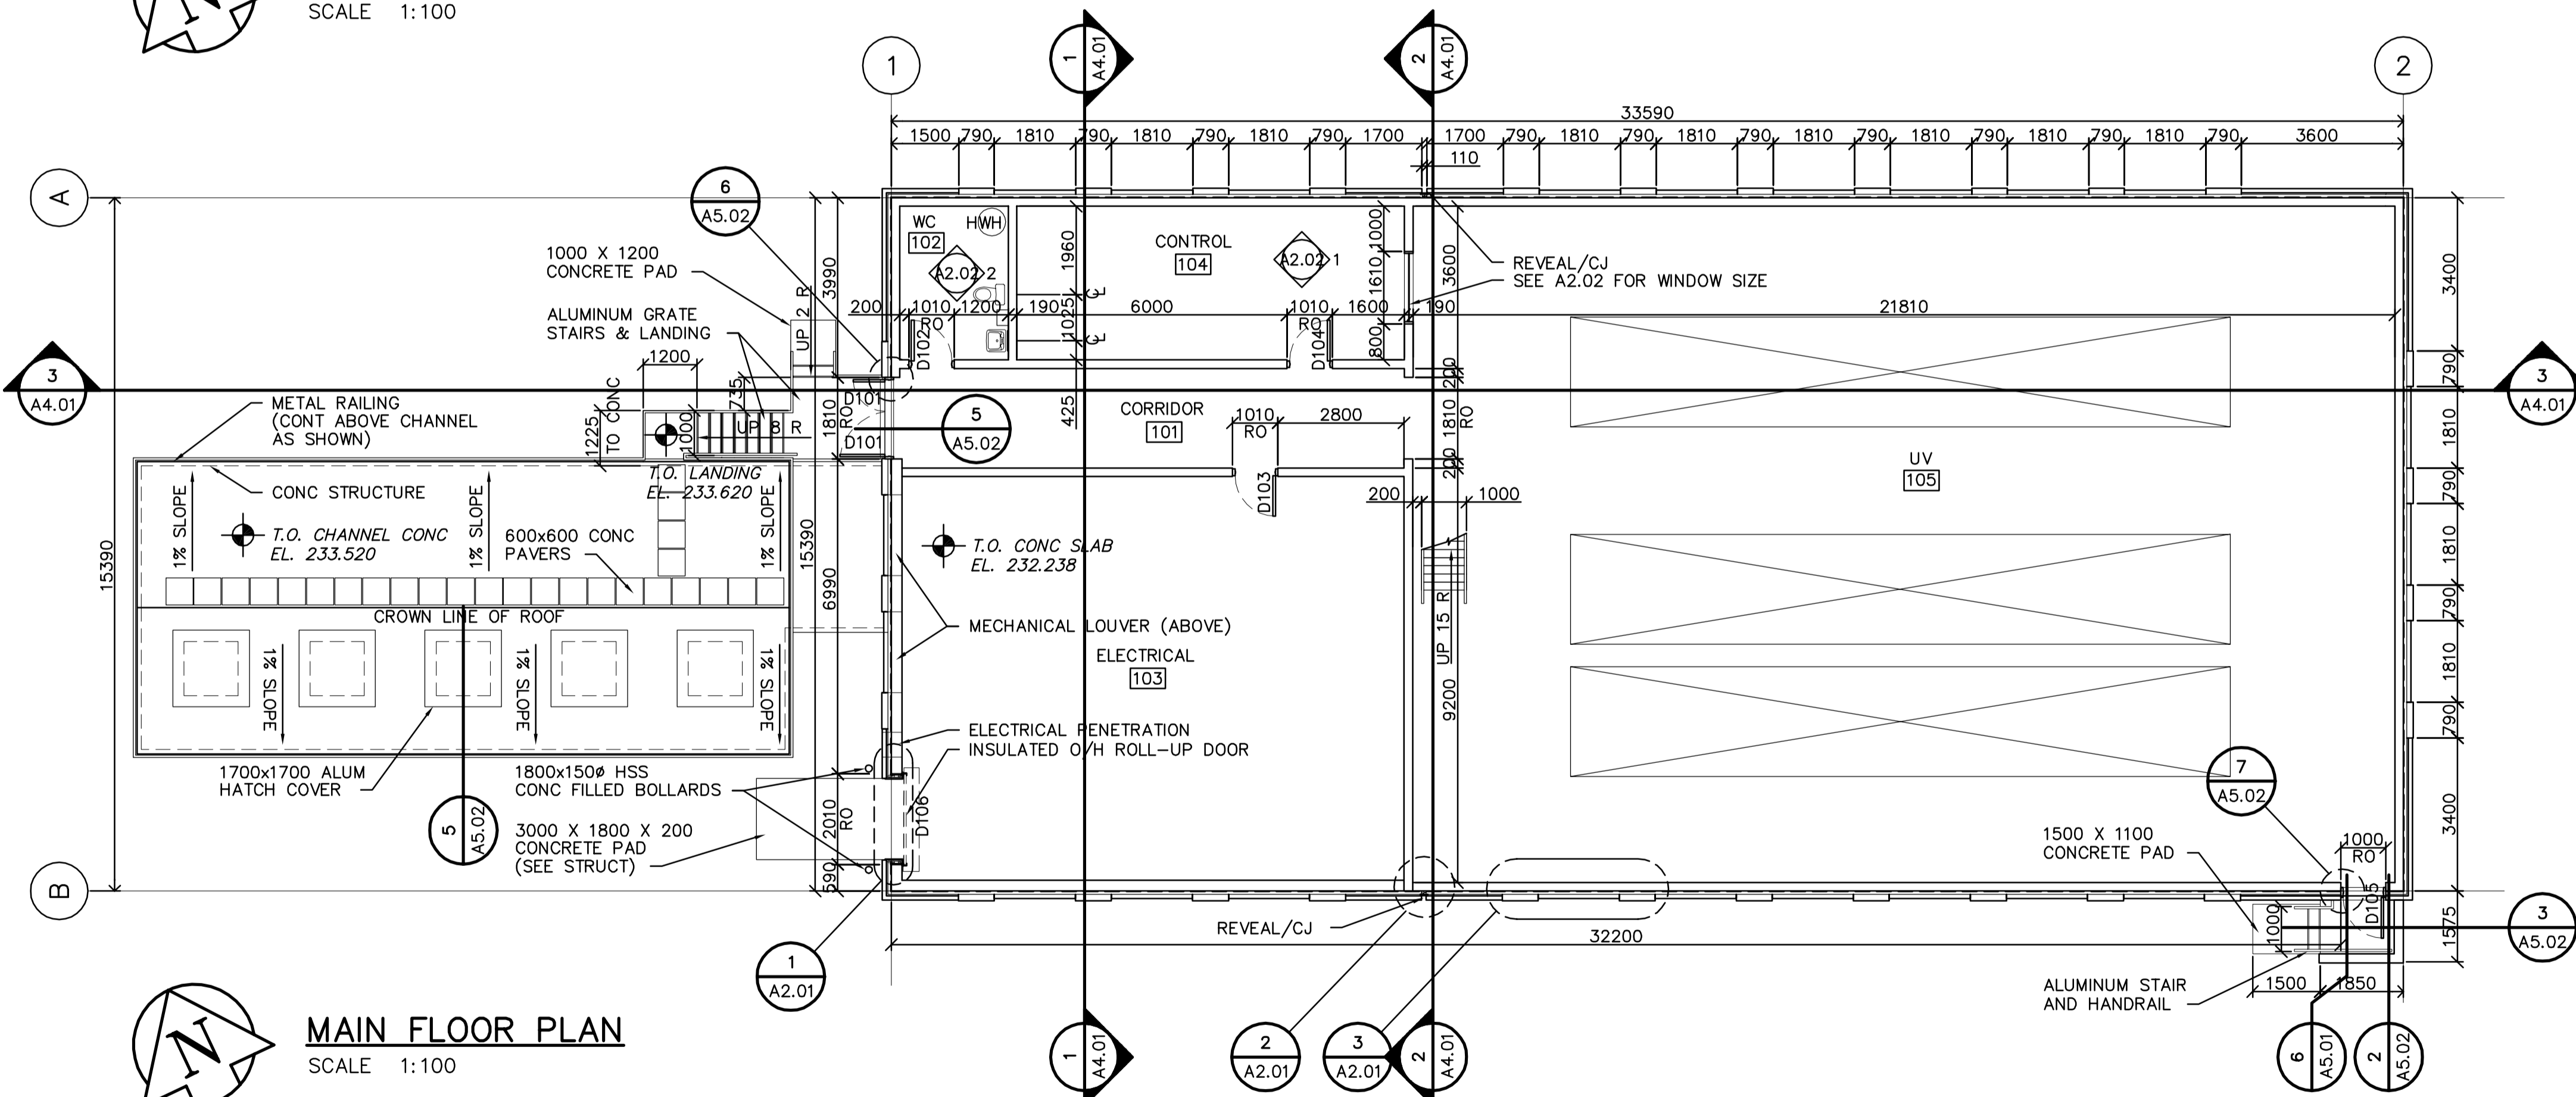


**MAIN FLOOR PLAN**  
SCALE 1:100

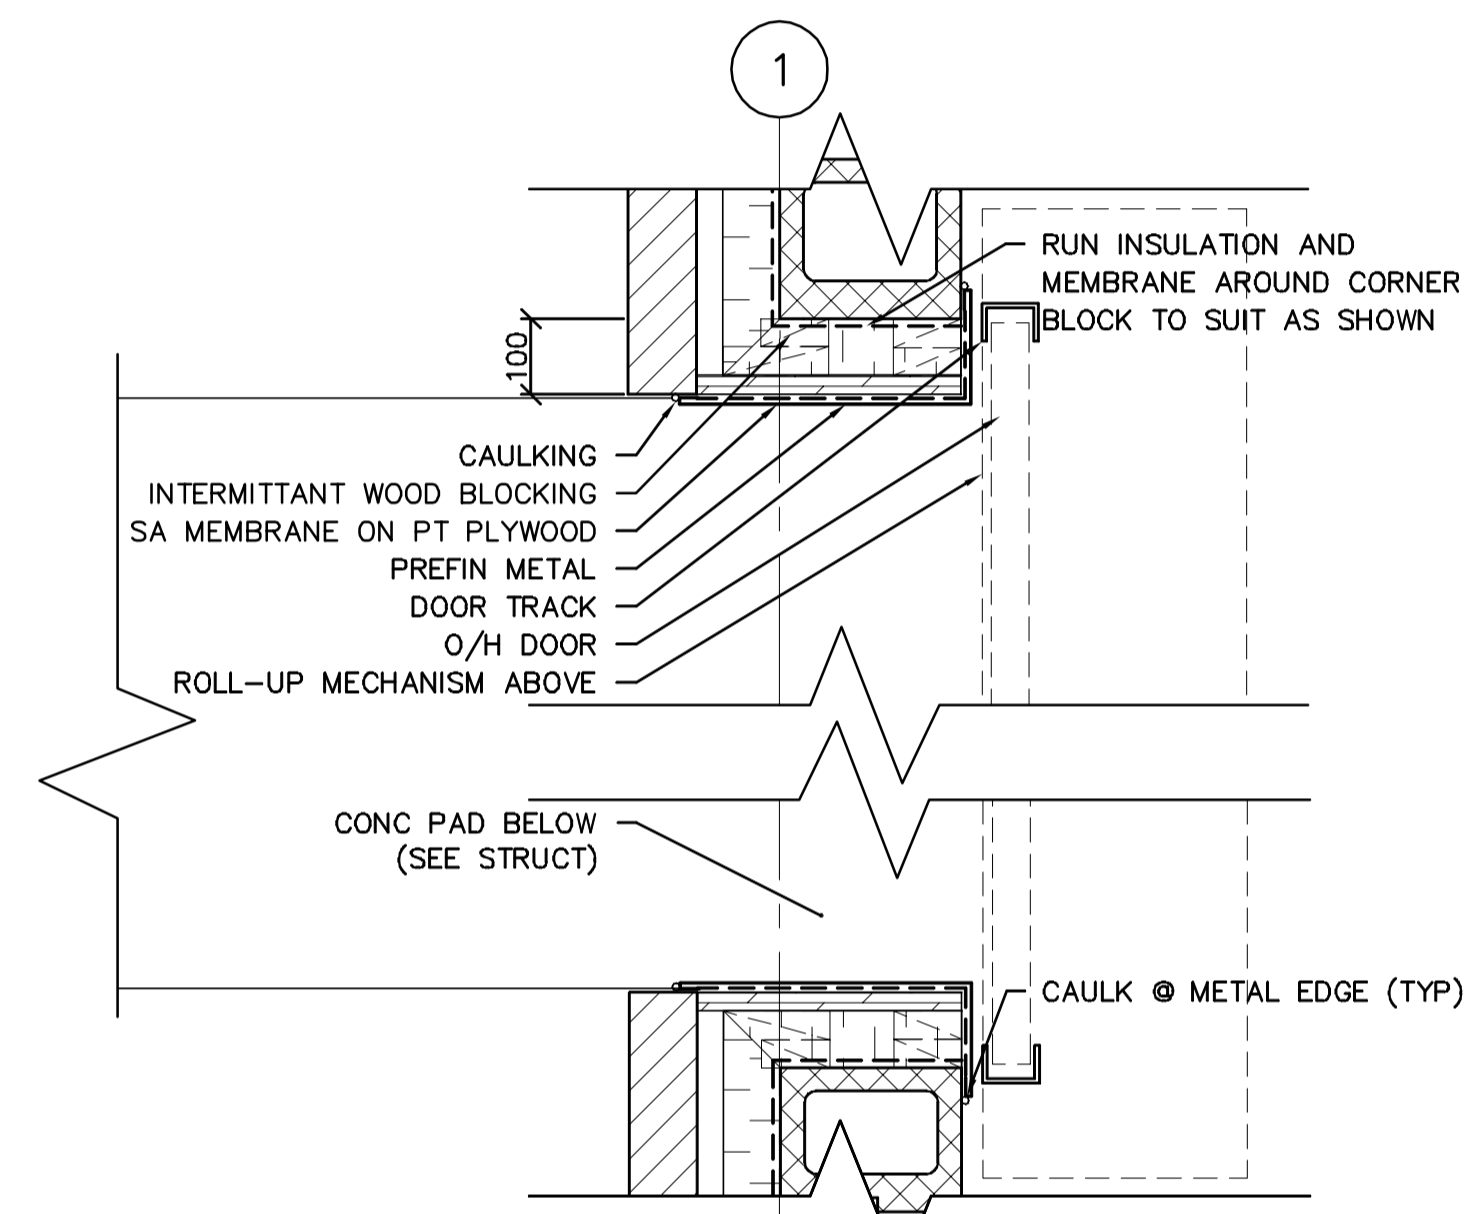

**1 PLAN DETAIL @ LOADING DOOR**  
SCALE 1:10

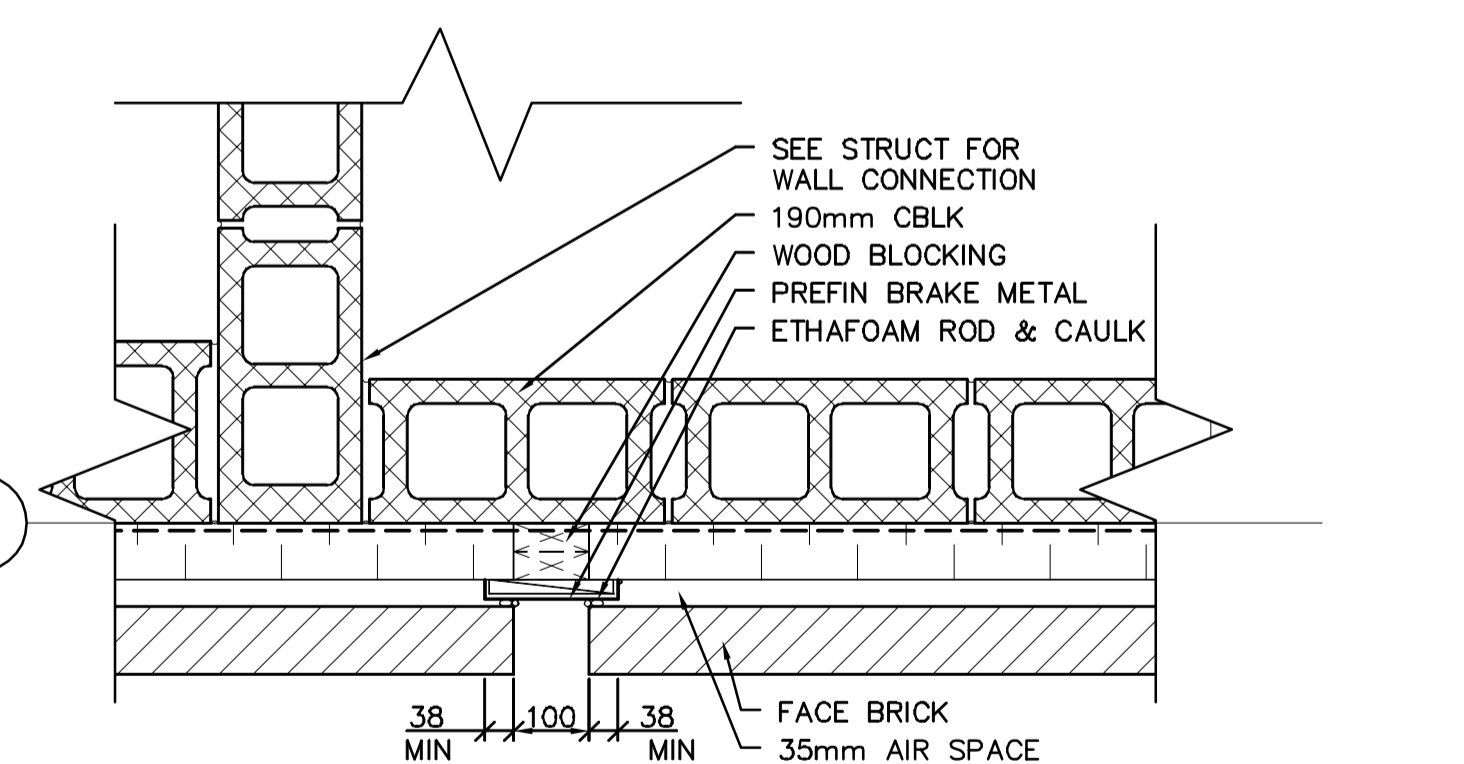

**2 PLAN DETAIL @ REVEAL/CONTROL JOINT**  
SCALE 1:10

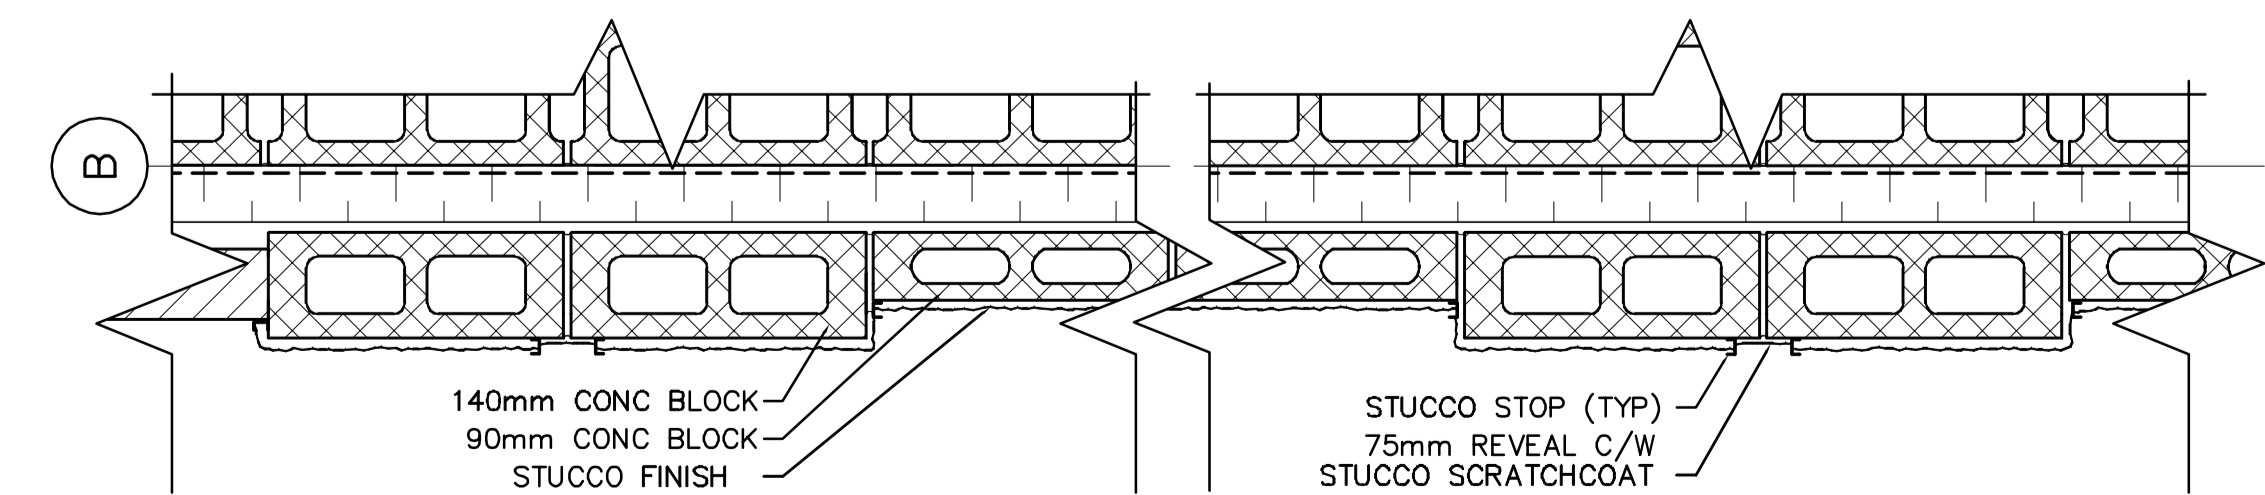

**3 TYPICAL PLAN DETAIL @ STUCCO REVEAL**  
SCALE 1:10

**APCGM**  
Certificate of Authorization  
Earth Tech Canada Inc.  
No. 730 Expiry: April 30, 2005

B.M. ELEV.	<b>EARTH TECH</b>		ENGINEER'S SEAL	<b>THE CITY OF WINNIPEG</b> Winnipeg WATER AND WASTE DEPARTMENT
	<small>Earth Tech (Canada) Inc. Winnipeg, Manitoba 204.477.5581</small>		ORIGINAL SIGNED BY NEIL COOPER FEB. 18/05	
DESIGNED BY NC	CHECKED BY NC, GGP	CONCULTANT DRAWING NO. 66303D-CA2.01	<b>NEWPCC</b> <b>UV DISINFECTION FACILITY</b> ARCHITECTURAL PLAN ABOVE ELEVATION 233.520, MEZZANINE & ROOF PLAN AND DETAILS	
DRAWN BY LK	APPROVED BY DT	RELEASED FOR CONSTRUCTION BY: T. KJARTANSON		
HOR. SCALE: AS NOTED VERTICAL SCALE: AS NOTED		DATE 02004/12/08	CITY FILE NUMBER SHEET 2 OF 8 CITY DRAWING NUMBER	
ISSUED FOR TENDER 05/02/18 LK		DATE 2005-02-18		