


**DRAWING NOTES**

- ① SUPPLY AND INSTALL BIRD SCREEN WITH GRAVITY HOOD.
- ② VENT STACK RISING THROUGH ROOF. SIZE OF RISER SHOWN. INCREASE RISER SIZE BY MINIMUM OF 1 PIPE SIZE AT ROOF PENETRATION. INSULATE RISER 1M DOWN FROM ROOF PENETRATION.
- ③ COORDINATE LOCATION WITH ARCHITECTURAL. REFER TO ARCHITECTURAL DRAWINGS. SEE DETAIL ON DRAWING M7.02.
- ④ REFER TO: 

3
M7.05

**GENERAL NOTES**

- 1. COORDINATE WITH OTHER TRADES SO AS TO PREVENT CONFLICTS.
- 2. SEE ROOF DETAIL ON DRAWING CM7.05.

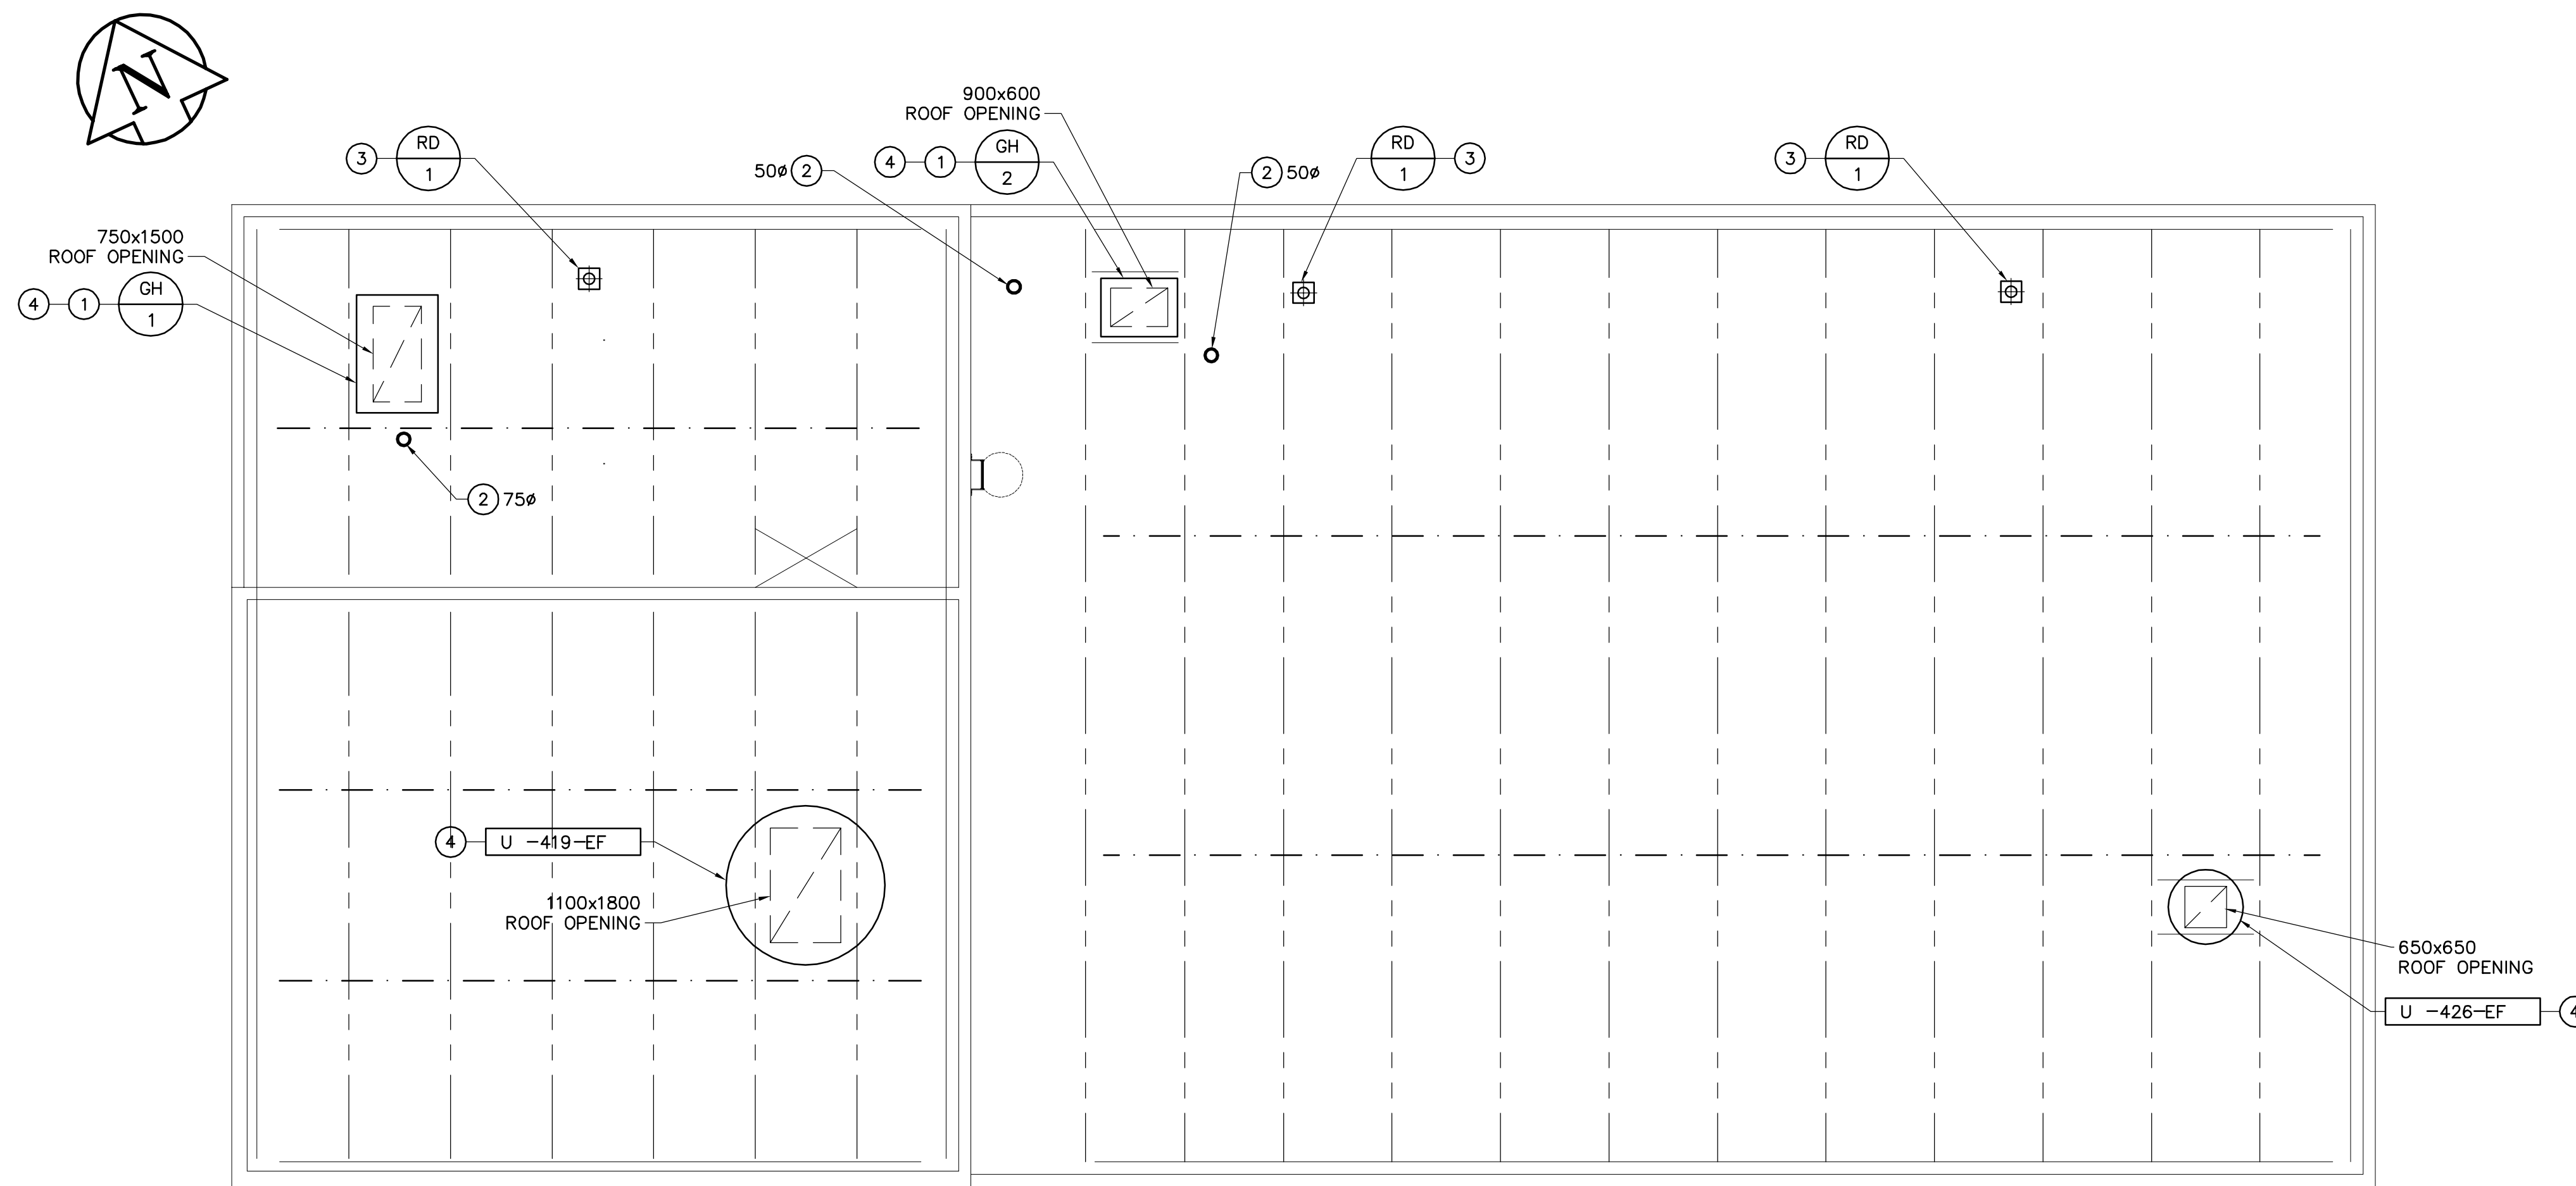

① **PLAN VIEW – ROOF**  
M4.02 SCALE 1:75



B.M. ELEV.	<b>EARTH TECH</b> <small>Earth Tech (Canada) Inc. Winnipeg, Manitoba 204.477.5381</small>			ENGINEER'S SEAL  ORIGINAL SIGNED BY P.V. LAITINEN FEB. 18/05	<b>THE CITY OF WINNIPEG</b> WATER AND WASTE DEPARTMENT	
	DESIGNED BY: PL DRAWN BY: DC, DL	CHECKED BY: AMA APPROVED BY: DT	RELEASED FOR CONSTRUCTION BY: T. KJARTANSON		CONSULTANT DRAWING NO. 66303D-CM4.02	
	HOR. SCALE: AS NOTED VERTICAL SCALE: AS NOTED		NO. REVISIONS DATE BY DATE		NEWPCC - SECONDARY EFFLUENT UV DISINFECTION FACILITY	
	0 ISSUED FOR TENDER 05/02/18 JEH		2004/12/08 2005-02-18		MECHANICAL ROOF PLAN MECHANICAL PLAN	
				CITY FILE NUMBER SHEET 6 OF 18 CITY DRAWING NUMBER		