



SECOND FLOOR PLAN
1:100

NOTES:

1. BM1= HSS 406x203x13
BM2= HSS 254x152x8
2. COORDINATE BM1 AND BM2 LOCATIONS AND TOP OF STEEL ELEVATIONS WITH DRAWINGS WI-M0131, WI-M0201 AND WI-M0202.
3. ATTACH HANGERS FOR BM2 TO CONCRETE BM1 SHOWN ON DRAWING WI-S0131 UNDER CONTRACT B0650-2005.

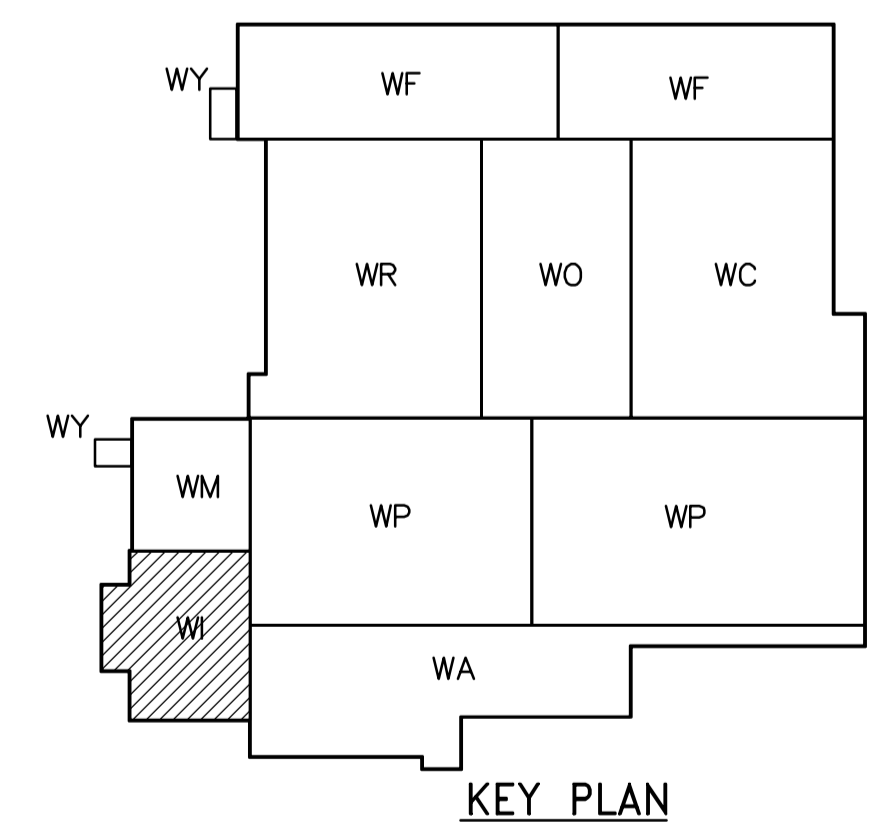

KEY PLAN

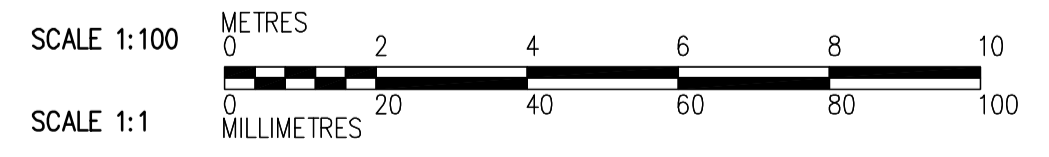

<p>APEGN Certificate of Authorization CH2M HILL Canada Ltd. No. 1441 Expiry: April 30, 2006</p>	<p>Frederickson Cooper ARCHITECTS</p>		<p>EarthTech A Tyco International Ltd. Company</p>		ENGINEER'S SEAL ORIGINAL SIGNED BY D. KRUGER 2006/04/21	<p>THE CITY OF WINNIPEG WATER AND WASTE DEPARTMENT ENGINEERING DIVISION</p>	WATER TREATMENT PLANT INLET WORKS AND RAW WATER PUMPING MECHANICAL AND ELECTRICAL	CITY FILE NUMBER SHEET OF
	DESIGNED BY: EL CHECKED BY: AP		DRAWN BY: RL/CA APPROVED BY: AHL		CONSULTANT DRAWING NO. WI-S7121		STRUCTURAL RAW WATER PUMP STATION AREA SECOND FLOOR PLAN	CITY DRAWING NUMBER 1-06011-A-S7121-001-000
	SCALE: 1:100 RELEASED FOR CONSTRUCTION BY: R. SOROKOWSKI		DATE: 2005/12/13 DATE: 2006/04/21					
	B.M. ELEV.							
NO. REVISIONS		DATE BY						