
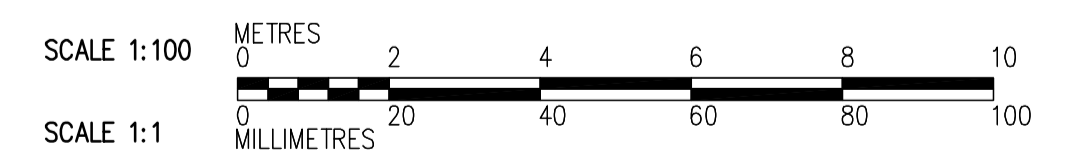


THIRD FLOOR PLAN
1:100

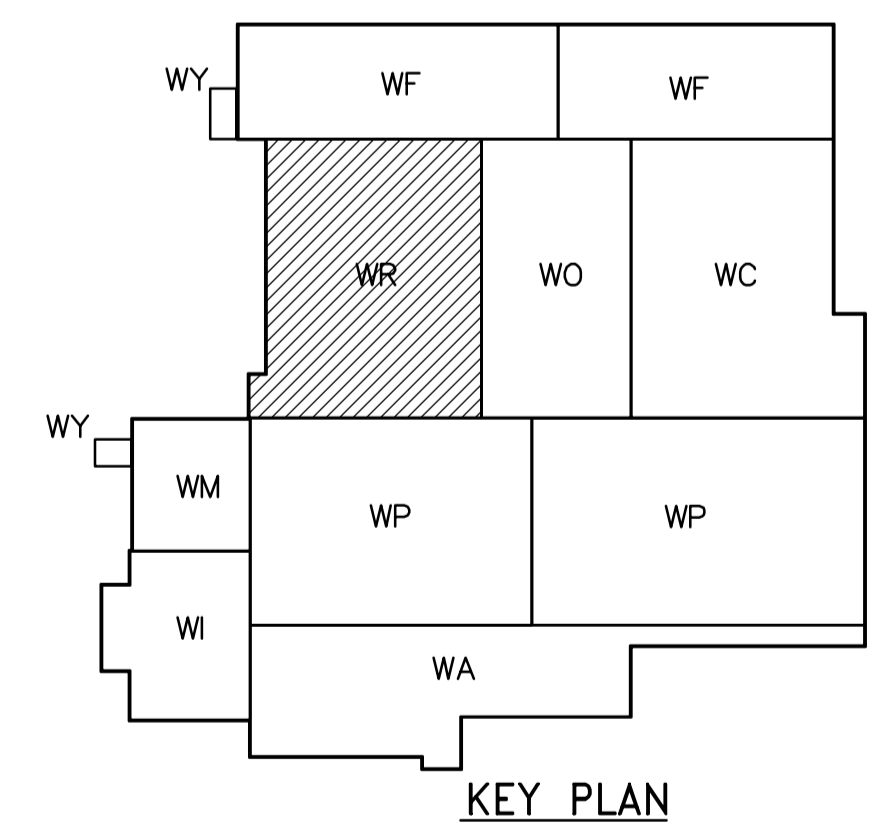

 Certificate of Authorization CH2M HILL Canada Ltd. No. 1441 Expiry: April 30, 2006	B.M. ELEV.	 Frederickson Cooper ARCHITECTS	 A Tetra International Ltd. Company	ENGINEER'S SEAL ORIGINAL SIGNED BY D. KRUGER 2006/04/21	 THE CITY OF WINNIPEG WATER AND WASTE DEPARTMENT ENGINEERING DIVISION WATER TREATMENT PLANT RESIDUALS HANDLING MECHANICAL AND ELECTRICAL
	DESIGNED BY EL CHECKED BY AP			CONSULTANT DRAWING NO. WR-S7131	
	DRAWN BY CA APPROVED BY AHL				
	SCALE: 1:100 RELEASED FOR CONSTRUCTION BY: R. SOROKOWSKI				
NO. REVISIONS DATE BY	DATE 2005/12/13 DATE 2006/04/21	CITY FILE NUMBER SHEET OF CITY DRAWING NUMBER 1-0601R-A-S7131-001-000			