



- NOTES:**
1. ALL 120V AND 208V LOADS ARE FED FROM LP-M11.
 2. EMERGENCY LIGHTING EM-X-1 ARE FED FROM BATTERY PACK EM-X.
 3. MOUNT TYPE A LUMINAIRE AT 3.0m ABOVE THE FLOOR.
 4. SEE DWG-WB-E0401 FOR LIGHT MOUNTING DETAIL

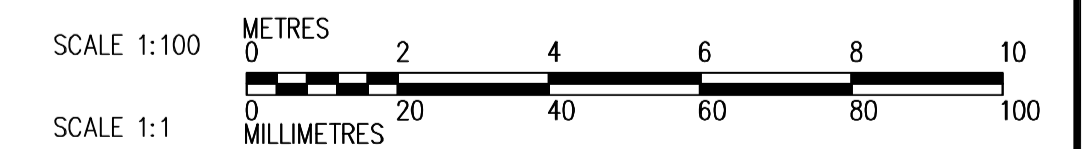

THIRD FLOOR POWER AND LIGHTING PLAN
1:100

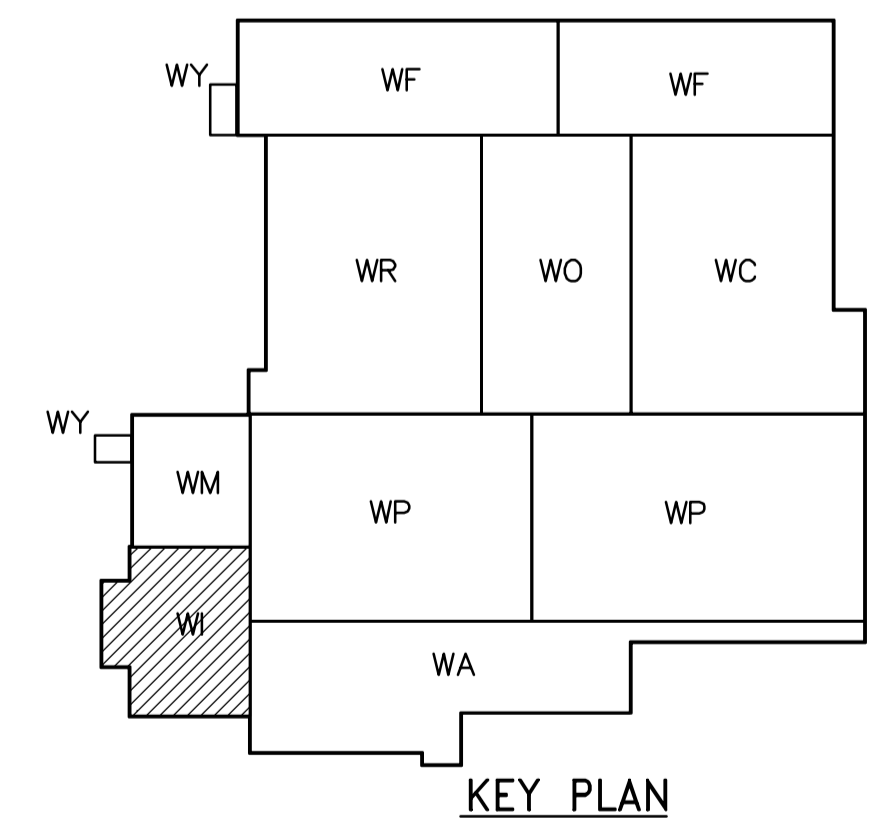

<p>APEGN Certificate of Authorization CH2M HILL Canada Ltd. No. 1441 Expiry: April 30, 2007</p>	<p>Frederickson Cooper ARCHITECTS</p>		<p>A You International Ltd. Company</p>		ENGINEER'S SEAL ORIGINAL SIGNED BY L.D. LLEWELLYN 2006/03/29	<p>THE CITY OF WINNIPEG WATER AND WASTE DEPARTMENT ENGINEERING DIVISION</p>	WATER TREATMENT PLANT INLET WORKS AND RAW WATER PUMPING MECHANICAL AND ELECTRICAL	CITY FILE NUMBER SHEET OF	
	DESIGNED BY LL CHECKED BY ND DRAWN BY TL APPROVED BY AHL		SCALE: 1:100 RELEASED FOR CONSTRUCTION BY: R. SOROKOWSKI		CONSULTANT DRAWING NO. WI-E0133		ELECTRICAL RAW WATER PUMPING STATION AREA THIRD FLOOR POWER AND LIGHTING PLAN	CITY DRAWING NUMBER 1-06011-A-E0133-001-030	
	NO. REVISIONS DATE BY DATE 2005/07/13 DATE 2006/03/29		REVISIONS: 03 742-2005 ADDENDUM 12 06/06/23 PF 02 742-2005 ADDENDUM 5 06/05/19 LL 01 742-2005 ADDENDUM 3 06/05/05 LL 00 ISSUED FOR TENDER 06/03/29 LL		B.M. ELEV.				