

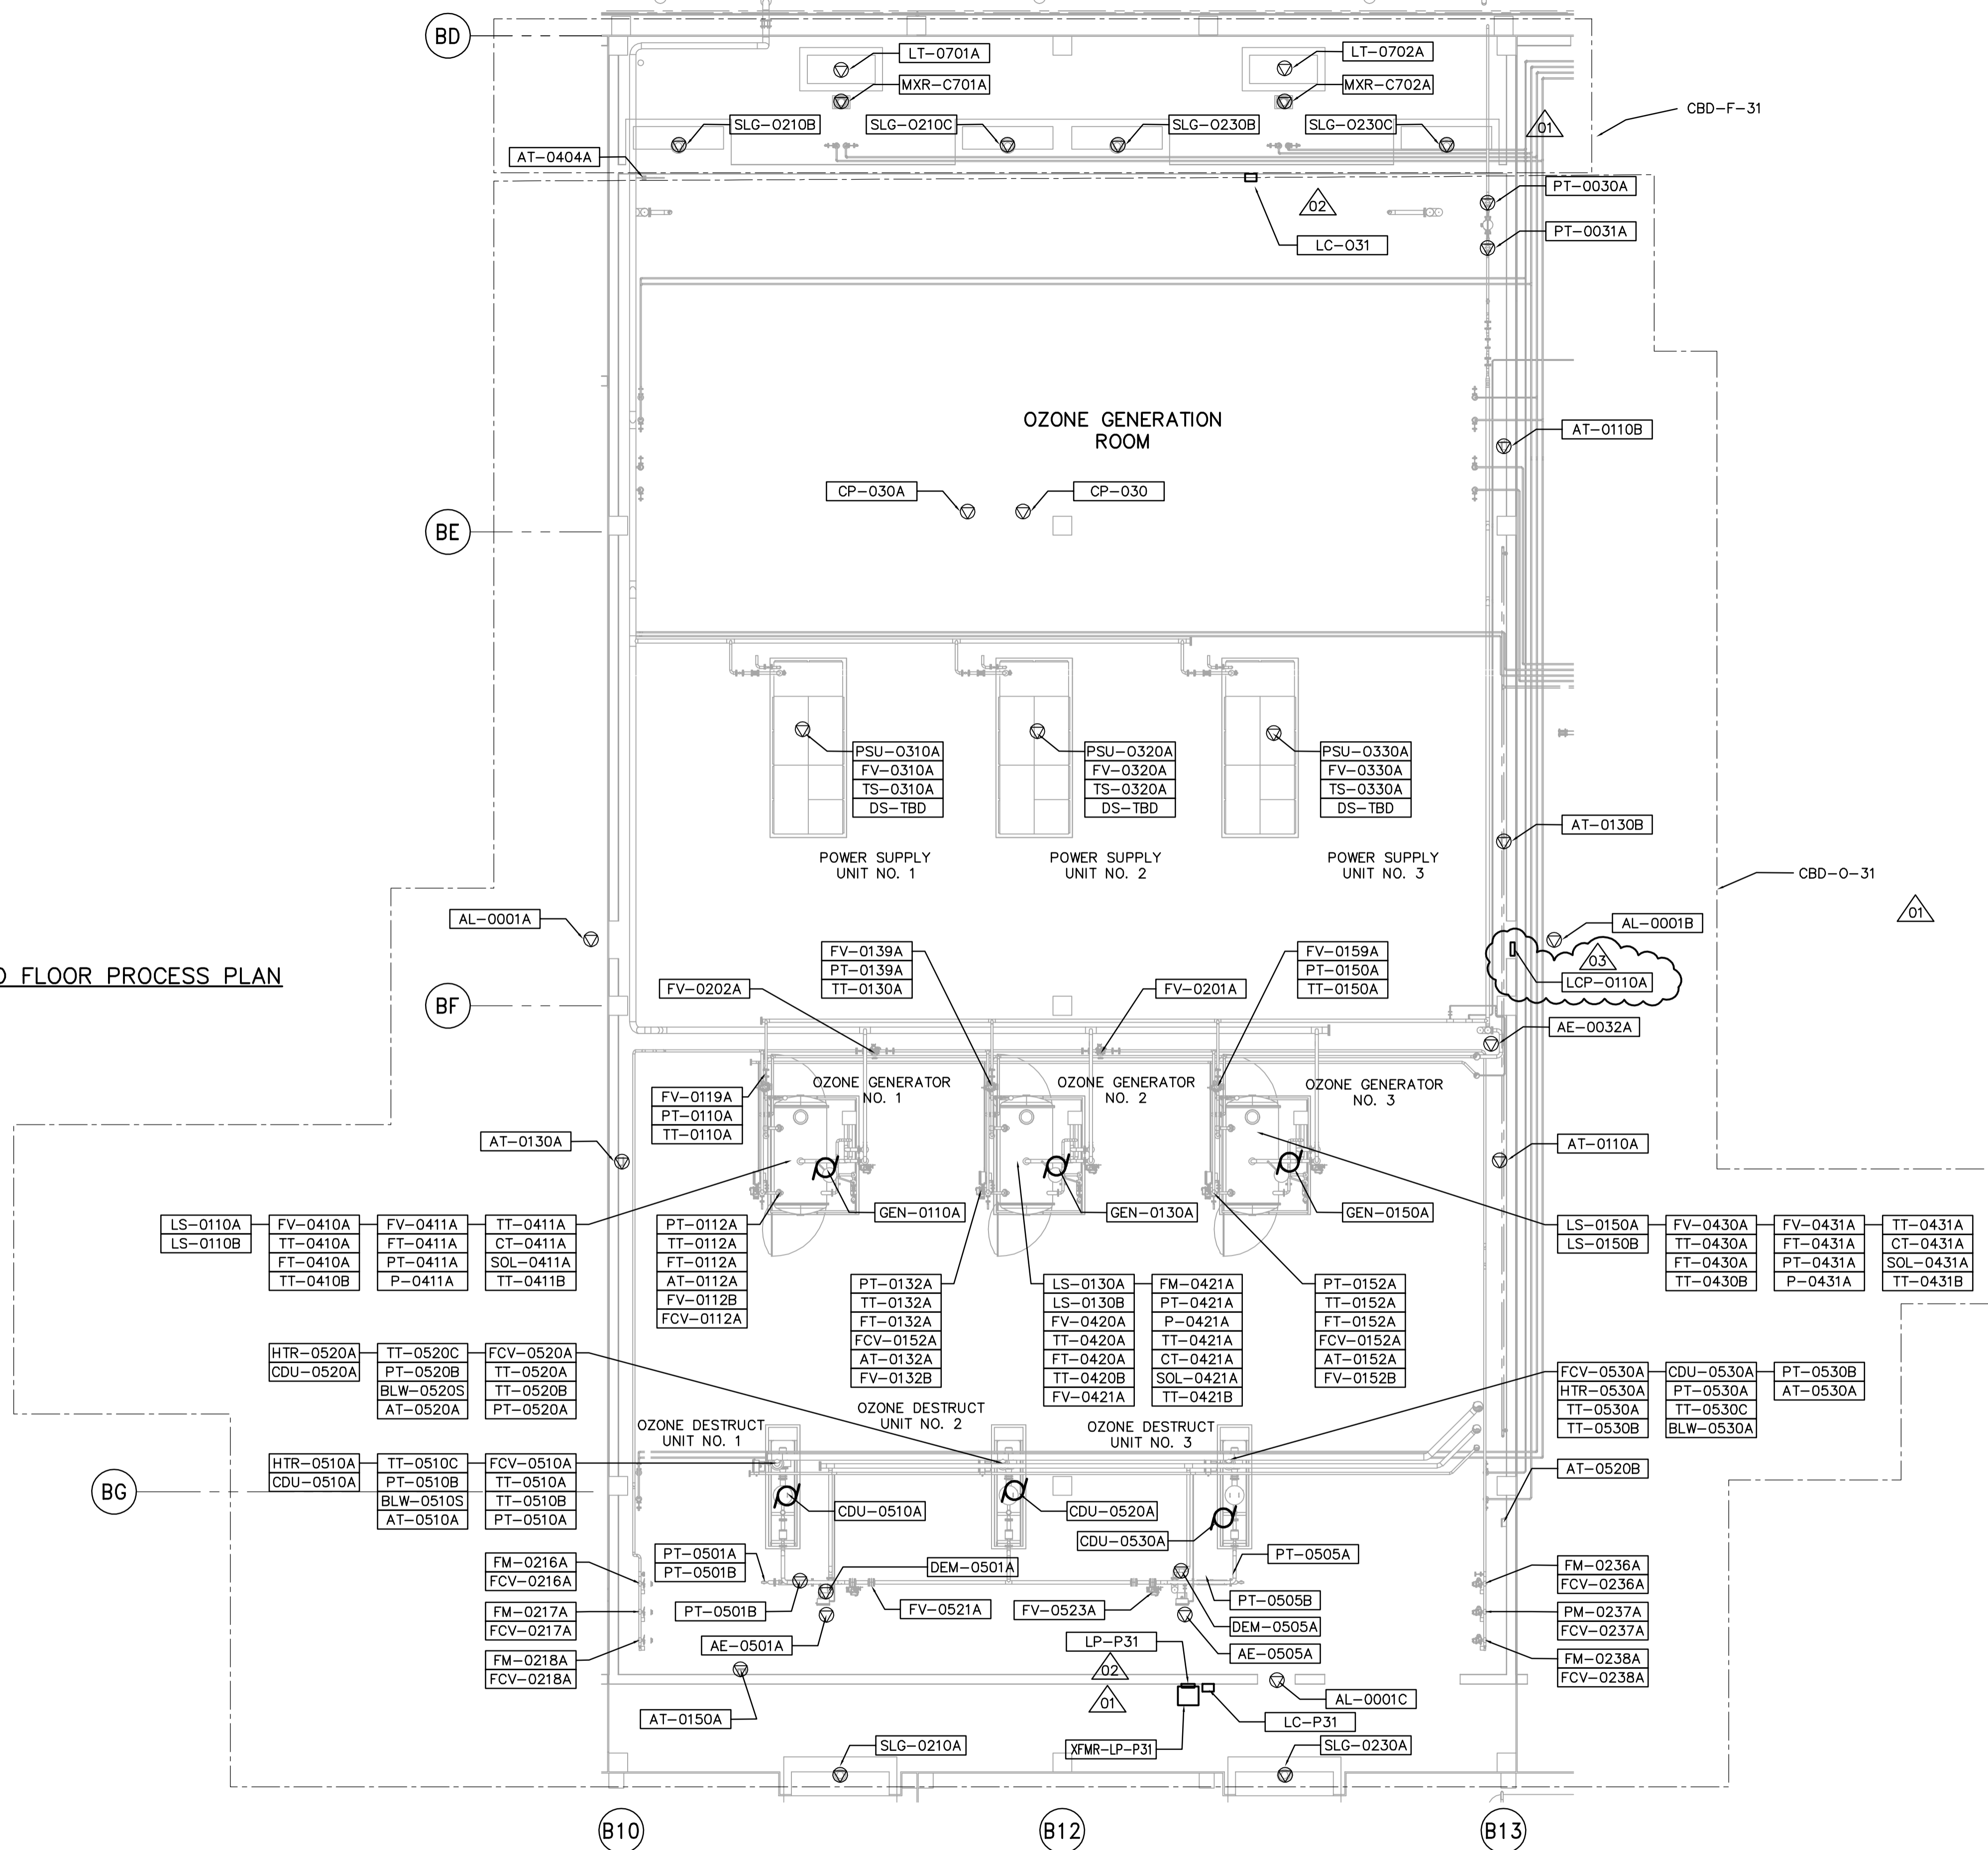


THIRD FLOOR PROCESS PLAN  
1:100

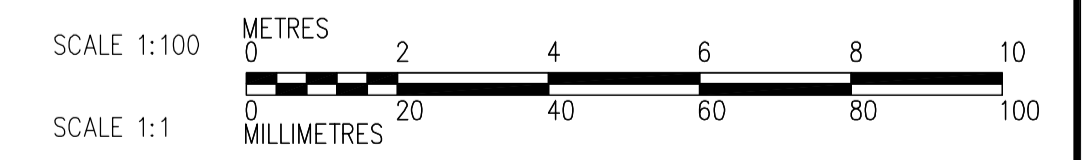

NOTES:  
1. SEE MCC 4A & 4B SINGLE LINE DIAGRAMS AND PANEL SCHEDULES DP-H31 & DP-H32 FOR 600V POWER DISTRIBUTION.

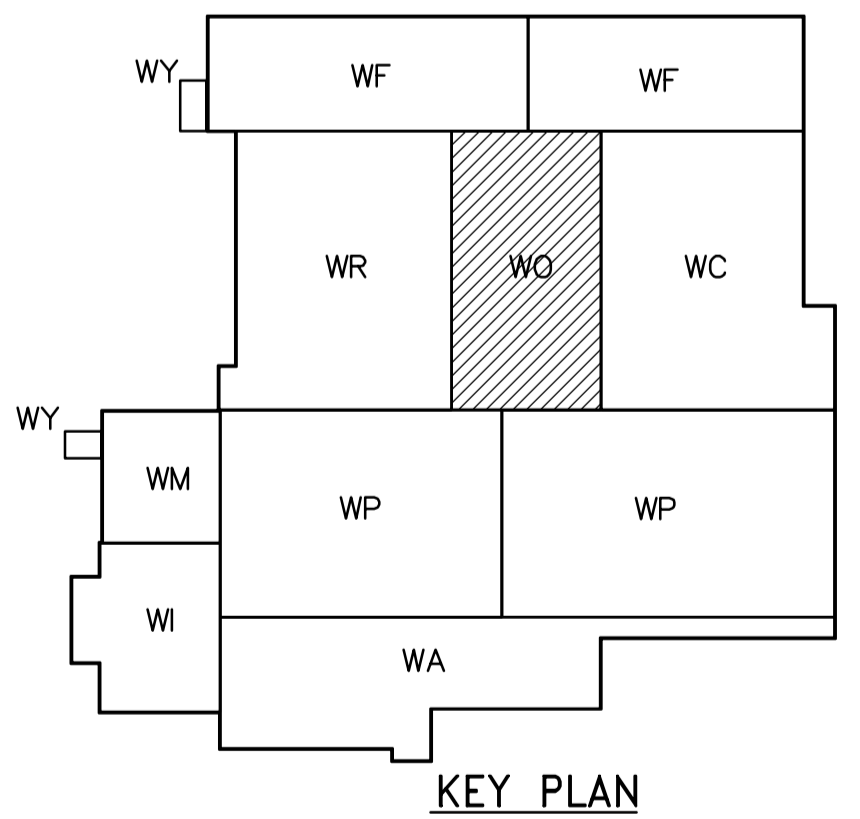

<p>Certificate of Authorization CH2M HILL Canada Ltd. No. 1441 Expiry: April 30, 2007</p>	<table border="1"> <tr><th>NO.</th><th>REVISIONS</th><th>DATE</th><th>BY</th></tr> <tr><td>03</td><td>742-2005 ADDENDUM 12</td><td>06/06/23</td><td>PF</td></tr> <tr><td>02</td><td>742-2005 ADDENDUM 5</td><td>06/05/19</td><td>LL</td></tr> <tr><td>01</td><td>742-2005 ADDENDUM 3</td><td>06/05/05</td><td>LL</td></tr> <tr><td>00</td><td>ISSUED FOR TENDER</td><td>06/03/29</td><td>LL</td></tr> </table>	NO.	REVISIONS	DATE	BY	03	742-2005 ADDENDUM 12	06/06/23	PF	02	742-2005 ADDENDUM 5	06/05/19	LL	01	742-2005 ADDENDUM 3	06/05/05	LL	00	ISSUED FOR TENDER	06/03/29	LL	<p>Frederickson Cooper ARCHITECTS</p>	<p>A Terra International Ltd. Company</p>	ENGINEER'S SEAL ORIGINAL SIGNED BY L.D. LLEWELLYN 2006/03/29	<p>THE CITY OF WINNIPEG WATER AND WASTE DEPARTMENT ENGINEERING DIVISION</p>
		NO.	REVISIONS	DATE	BY																				
03	742-2005 ADDENDUM 12	06/06/23	PF																						
02	742-2005 ADDENDUM 5	06/05/19	LL																						
01	742-2005 ADDENDUM 3	06/05/05	LL																						
00	ISSUED FOR TENDER	06/03/29	LL																						
DESIGNED BY: LL CHECKED BY: ND DRAWN BY: TL APPROVED BY: AHL SCALE: 1:100 RELEASED FOR CONSTRUCTION BY: R. SOROKOWSKI DATE: 2005/07/13 DATE: 2006/03/29	CONSULTANT DRAWING NO. WO-E0132	WATER TREATMENT PLANT OZONE MECHANICAL AND ELECTRICAL ELECTRICAL OZONATION AREA THIRD FLOOR PROCESS PLAN	CITY FILE NUMBER SHEET OF CITY DRAWING NUMBER 1-06010-A-E0132-001-03D																						