


NOTES:


1. SEE MCC 4A & 4B SINGLE LINE DIAGRAMS AND PANEL SCHEDULES DP-H31 AND DP-H32 FOR 600V POWER DISTRIBUTION.
2. SEE DRAWINGS WB-E0402 AND WB-E0403 FOR FLOCCULATION TANK EQUIPMENT WIRING DETAILS.
3. SEE CABLE BLOCK DIAGRAMS CBD-P-31 THROUGH CBD-P-39 FOR DAF EQUIPMENT AND INSTRUMENT INTERCONNECTION WIRING REQUIREMENTS.

THIRD FLOOR PROCESS PLAN (AREA 1)

1:100

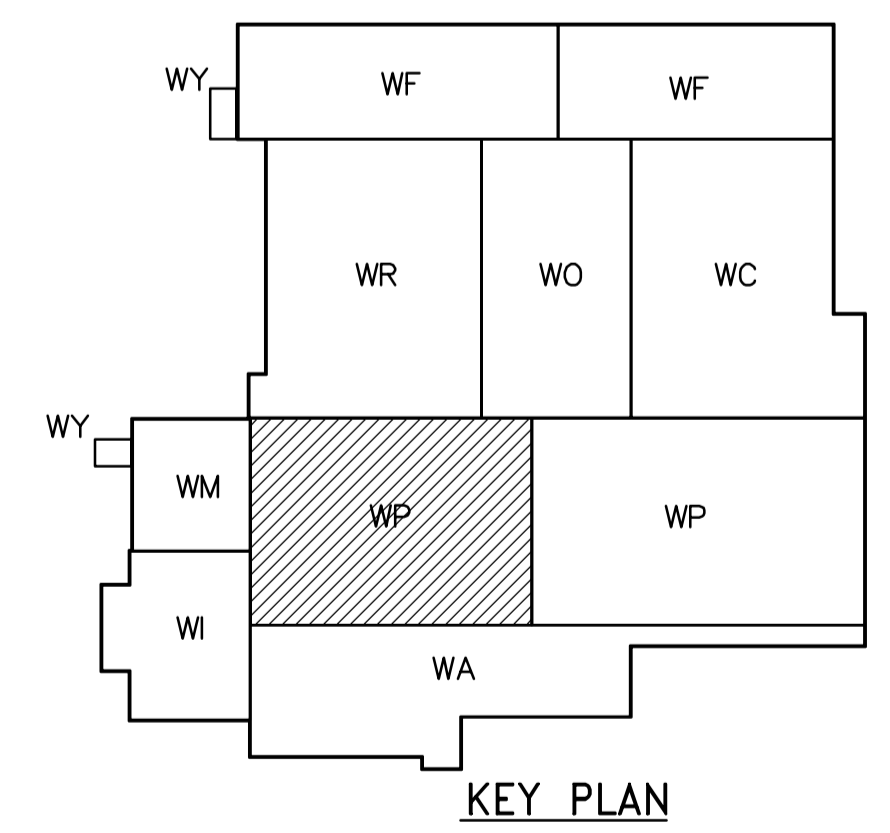

KEY PLAN

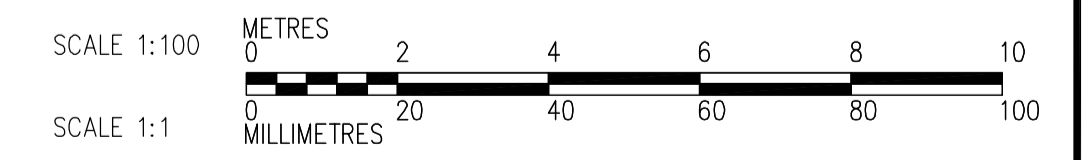

<p>Certificate of Authorization CH2M HILL Canada Ltd. No. 1441 Expiry: April 30, 2007</p>	B.M. ELEV.	<p>Frederickson Cooper ARCHITECTS</p>	<p>A You International Ltd. Company</p>	ENGINEER'S SEAL	<p>THE CITY OF WINNIPEG WATER AND WASTE DEPARTMENT ENGINEERING DIVISION</p>																					
				DESIGNED BY LL		CHECKED BY ND	ORIGINAL SIGNED BY L.D. LLEWELLYN																			
		DRAWN BY TL	APPROVED BY AHL	2006/03/29		WATER TREATMENT PLANT FLOCCULATION AND DAF MECHANICAL AND ELECTRICAL																				
	<table border="1"> <tr> <td>02</td> <td>742-2005 ADDENDUM 12</td> <td>06/06/23</td> <td>PF</td> </tr> <tr> <td>01</td> <td>742-2005 ADDENDUM 5</td> <td>06/05/19</td> <td>LL</td> </tr> <tr> <td>00</td> <td>ISSUED FOR TENDER</td> <td>06/03/29</td> <td>LL</td> </tr> <tr> <td>NO.</td> <td>REVISIONS</td> <td>DATE</td> <td>BY</td> </tr> </table>	02	742-2005 ADDENDUM 12	06/06/23		PF	01	742-2005 ADDENDUM 5	06/05/19	LL	00	ISSUED FOR TENDER	06/03/29	LL	NO.	REVISIONS	DATE	BY	SCALE: 1:100	RELEASED FOR CONSTRUCTION BY: R. SOROKOWSKI	CONSULTANT DRAWING NO. WP-E0133	<table border="1"> <tr> <td>CITY FILE NUMBER</td> <td></td> </tr> <tr> <td>SHEET OF</td> <td></td> </tr> <tr> <td>CITY DRAWING NUMBER</td> <td>1-0601P-A-E0133-001-020</td> </tr> </table>	CITY FILE NUMBER		SHEET OF	
02	742-2005 ADDENDUM 12	06/06/23	PF																							
01	742-2005 ADDENDUM 5	06/05/19	LL																							
00	ISSUED FOR TENDER	06/03/29	LL																							
NO.	REVISIONS	DATE	BY																							
CITY FILE NUMBER																										
SHEET OF																										
CITY DRAWING NUMBER	1-0601P-A-E0133-001-020																									
	DATE 2005/07/12	DATE 2006/03/29		ELECTRICAL FLOC/DAF AREA 1 THIRD FLOOR PROCESS PLAN																						