

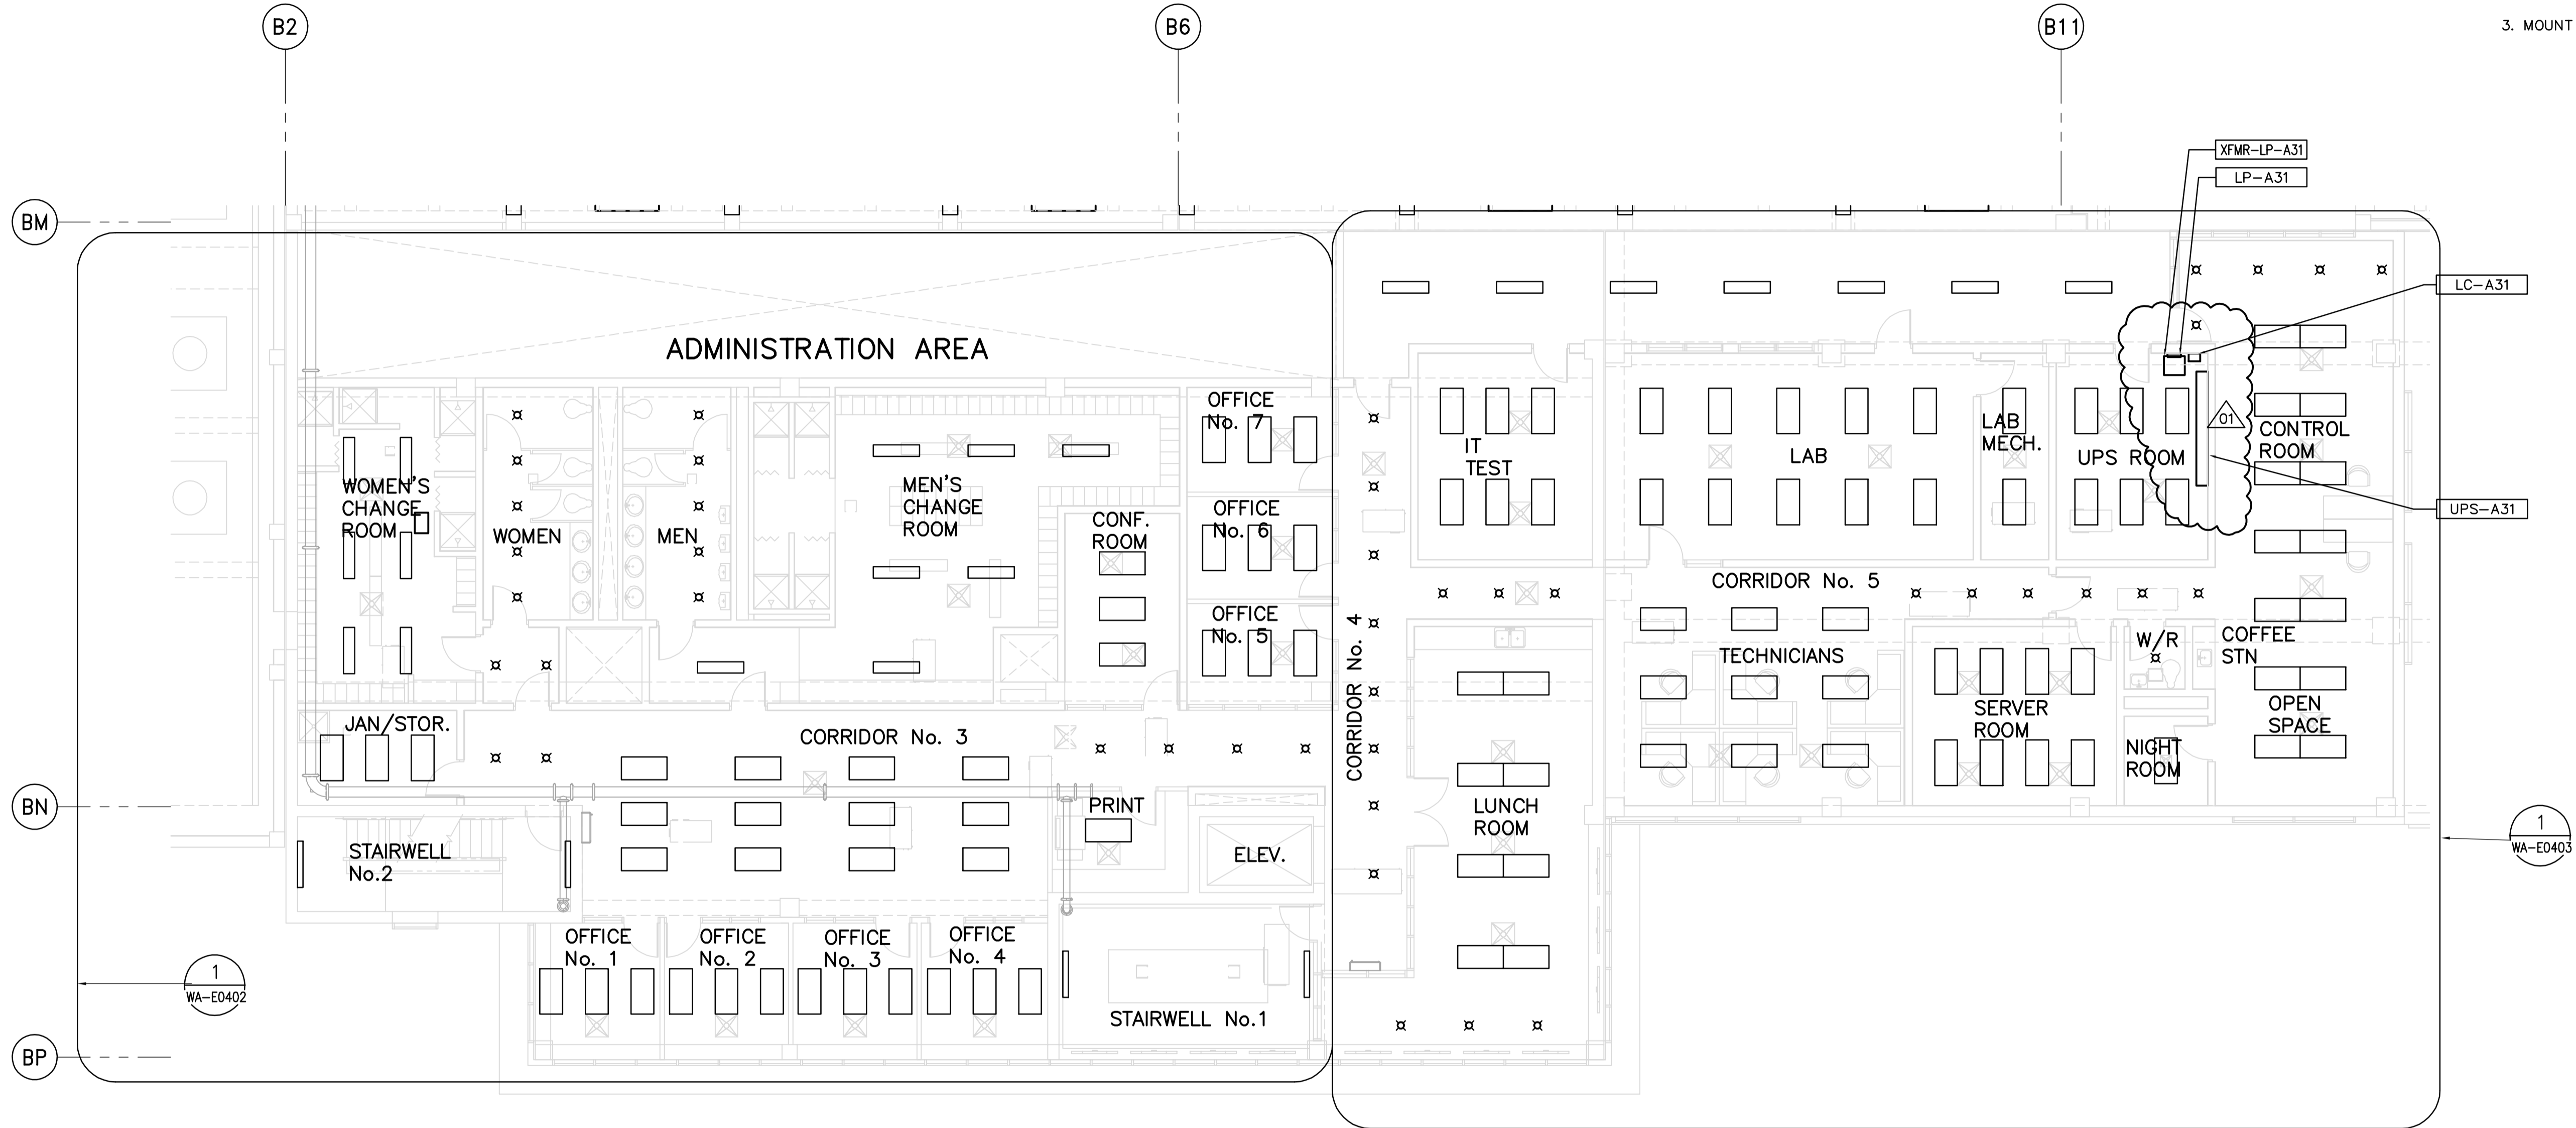


NOTES:

1. ALL 120V AND 208V LOADS ARE FED FROM LP-A31.
2. EMERGENCY LIGHTING EM-X-1 ARE FED FROM BATTERY PACK EM-X.
3. MOUNT TYPE LUMINARIES T-BAR.

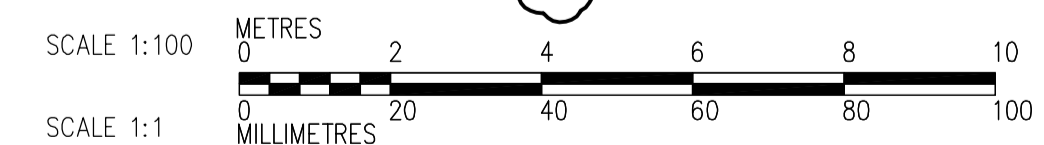

THIRD FLOOR POWER AND LIGHTING PLAN
1:100

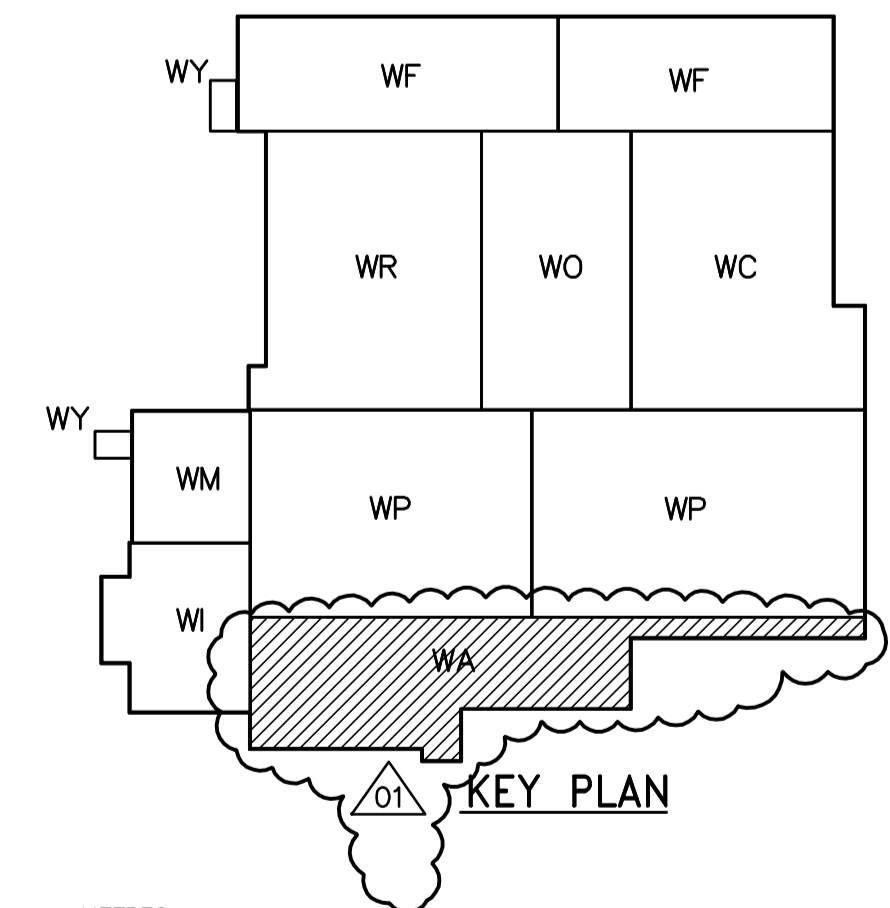

 Certificate of Authorization CH2M HILL Canada Ltd. No. 1441 Expiry: April 30, 2007	 Frederickson Cooper ARCHITECTS	 A You International Ltd. Company	B.M. ELEV.	ENGINEER'S SEAL ORIGINAL SIGNED BY L.D. LLEWELLYN 2006/03/29	 THE CITY OF WINNIPEG WATER AND WASTE DEPARTMENT ENGINEERING DIVISION WATER TREATMENT PLANT ADMINISTRATION AREA MECHANICAL AND ELECTRICAL ELECTRICAL ADMINISTRATION AREA THIRD FLOOR POWER AND LIGHTING PLAN	CITY FILE NUMBER
			DESIGNED BY LL CHECKED BY ND DRAWN BY TL APPROVED BY AHL SCALE: 1:100 RELEASED FOR CONSTRUCTION BY: R. SOROKOWSKI CONSULTANT DRAWING NO. WA-E0133	SHEET OF		
NO. REVISIONS DATE BY		DATE 2005/08/18 DATE 2006/03/29		CITY DRAWING NUMBER 1-0601A-A-E0133-001-01D		