


LCP-1004A

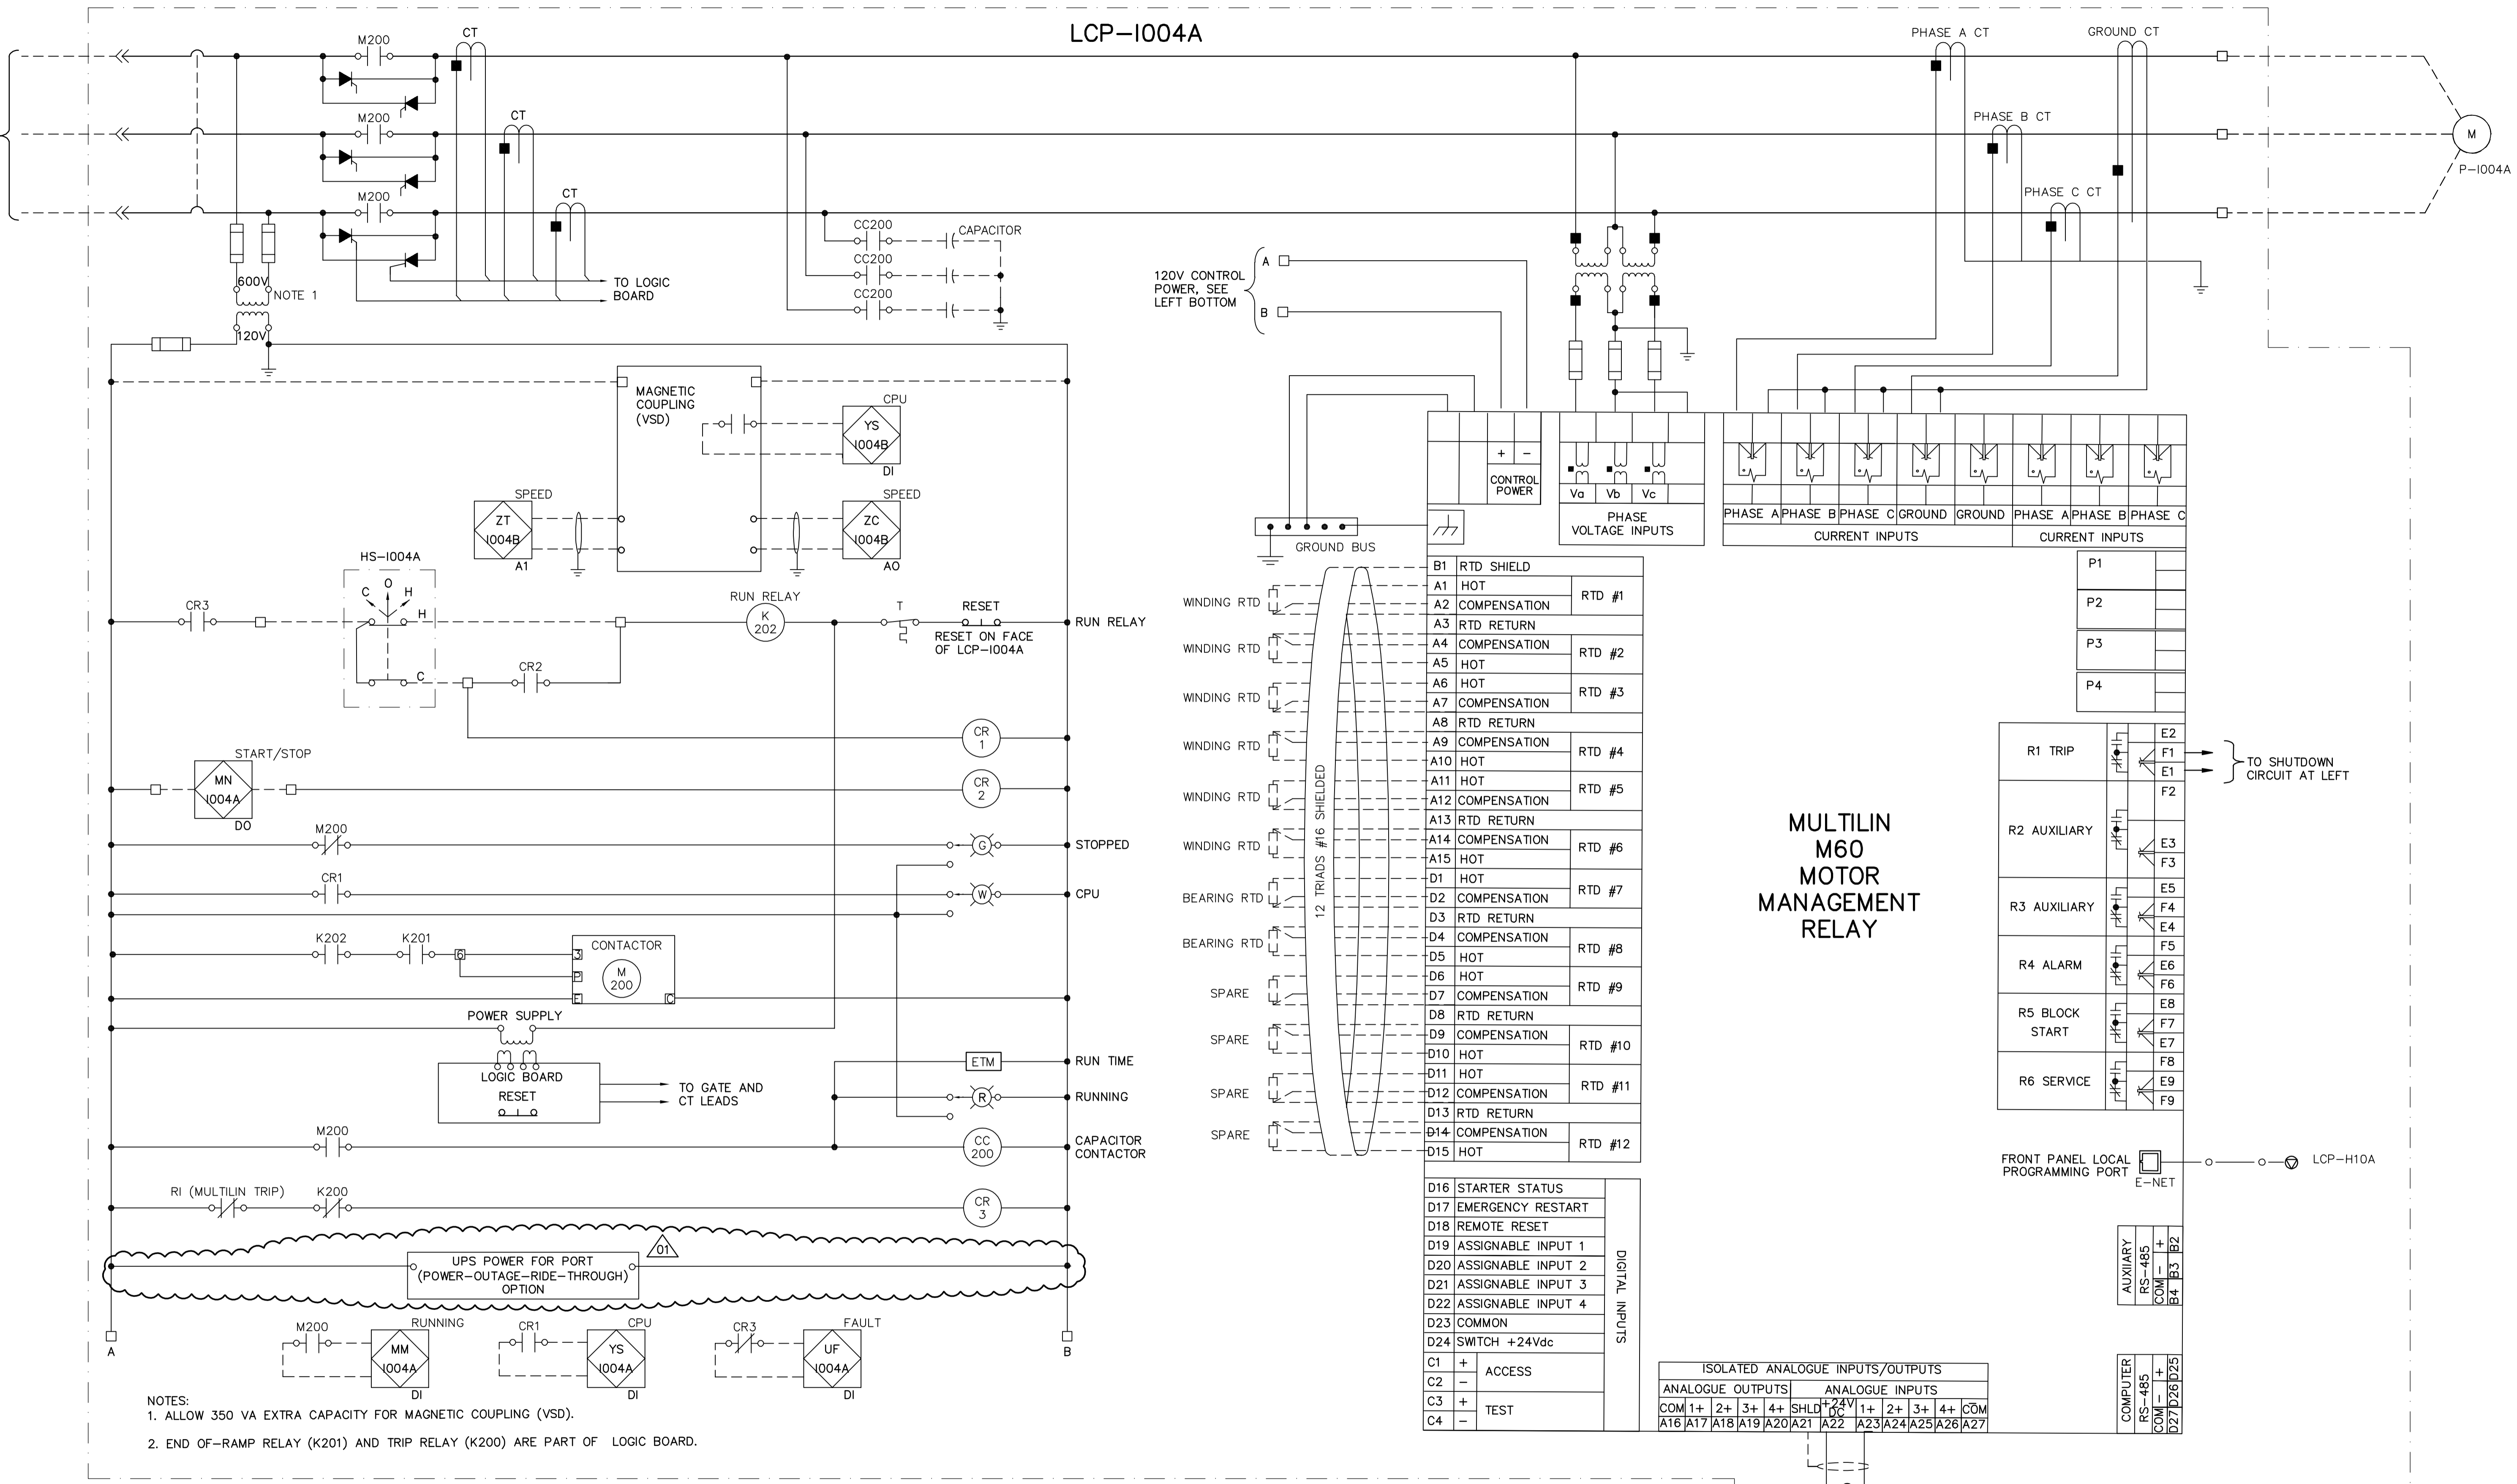

NOTES:
 1. ALLOW 350 VA EXTRA CAPACITY FOR MAGNETIC COUPLING (VSD).
 2. END OF-RAMP RELAY (K201) AND TRIP RELAY (K200) ARE PART OF LOGIC BOARD.

RAW WATER SUPPLY PUMP 4 (P-1004A)



B.M. ELEV.			
01	742-2005 ADDENDUM 3	06/05/05	LL
00	ISSUED FOR TENDER	06/03/29	LL
NO.	REVISIONS	DATE	BY

 Frederickson Cooper ARCHITECTS		 A Tyco International Ltd. Company	
DESIGNED BY	JT	CHECKED BY	ND
DRAWN BY	KJ	APPROVED BY	AHL
SCALE:	NTS	RELEASED FOR CONSTRUCTION BY:	R. SOROKOWSKI
DATE	2005/11/08	DATE	2006/03/29

ENGINEER'S SEAL
 ORIGINAL SIGNED BY
 L.D. LLEWELLYN
 2006/03/29
 CONSULTANT DRAWING NO.
 WB-E0548

THE CITY OF WINNIPEG
 WATER AND WASTE DEPARTMENT
 ENGINEERING DIVISION
 WATER TREATMENT PLANT
 MAIN BUILDING
 MECHANICAL AND ELECTRICAL
 ELECTRICAL
 CONTROL DIAGRAM

CITY FILE NUMBER	
SHEET OF	
CITY DRAWING NUMBER	1-0601B-H-E0548-001-01D