
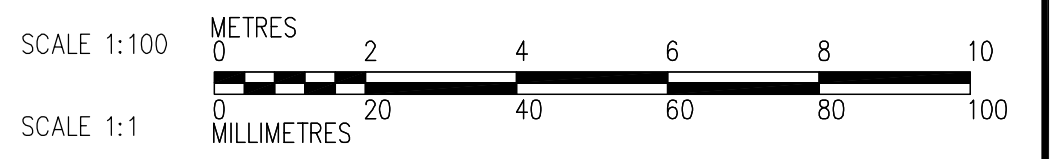


SECOND FLOOR FACILITY PLAN
1:100

NOTES
1. SEE MCC #2A & #2B SINGLE LINE DIAGRAM AND DP-C11 & DP-C12 POWER DISTRIBUTION FOR 600V POWER DISTRIBUTION.
2. ALL 120V AND 208V LOADS ARE FED FROM LP-C11

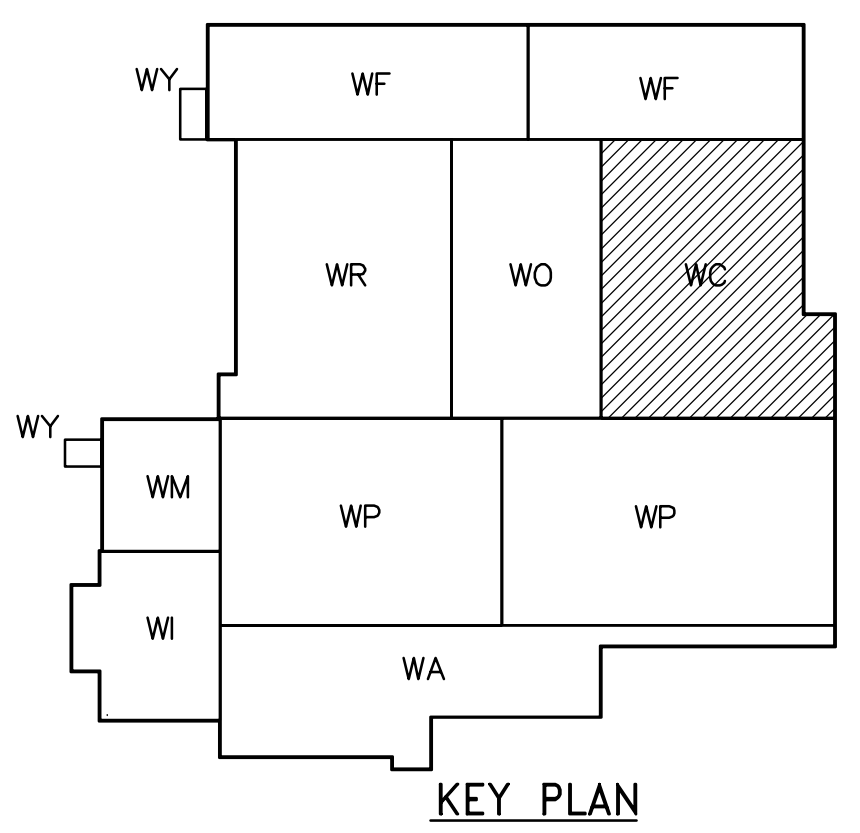

 APEGN Certificate of Authorization CH2M HILL Canada Ltd. No. 1441 Expiry: April 30, 2007	B.M. ELEV.	 Frederickson Cooper ARCHITECTS	 A Terra International Ltd. Company	ENGINEER'S SEAL	 THE CITY OF WINNIPEG WATER AND WASTE DEPARTMENT ENGINEERING DIVISION WATER TREATMENT PLANT CHEMICAL FEED SYSTEMS MECHANICAL AND ELECTRICAL ELECTRICAL CHEMICAL AREA SECOND FLOOR FACILITY PLAN	CITY FILE NUMBER
				DESIGNED BY LL		CHECKED BY ND
		DRAWN BY TLL	APPROVED BY AHL	2006/03/29		CITY DRAWING NUMBER
		SCALE: 1:100	RELEASED FOR CONSTRUCTION BY: R. SOROKOWSKI	CONSULTANT DRAWING NO. WC-E0121		1-0601C-A-E0121-001-01D
	NO. REVISIONS	DATE	BY	DATE		2005/07/08