



1
-
1:50
DETAIL

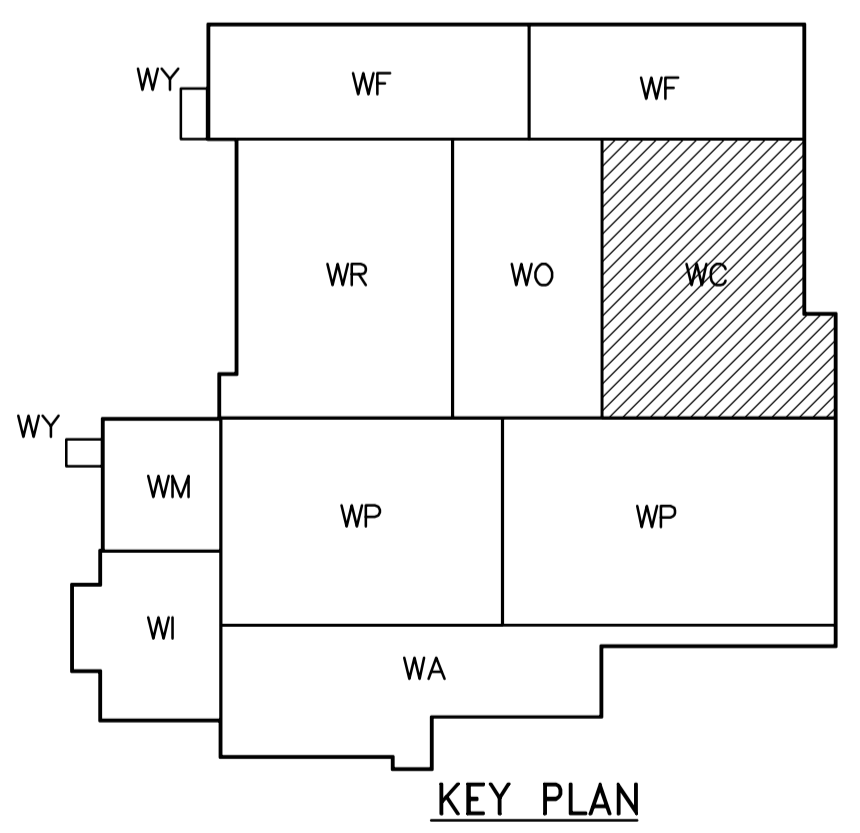

FIRST FLOOR PLAN
1:100

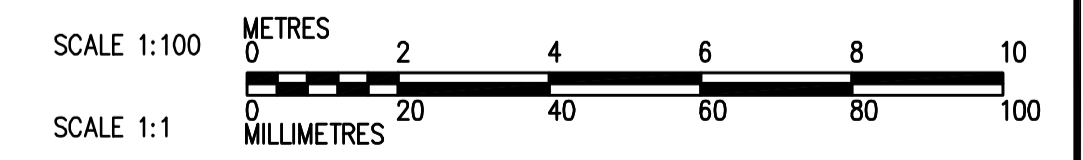

<p>APEGN Certificate of Authorization CH2M HILL Canada Ltd. No. 1441 Expiry: April 30, 2007</p>	B.M. ELEV.	<p>Frederickson Cooper ARCHITECTS</p>	<p>EarthTech A Tyco International Ltd. Company</p>	ENGINEER'S SEAL	<p>THE CITY OF WINNIPEG WATER AND WASTE DEPARTMENT ENGINEERING DIVISION</p>													
				DESIGNED BY JZ/SW		CHECKED BY DL	ORIGINAL SIGNED BY D.K. CUDDINGTON											
		DRAWN BY JMcP	APPROVED BY DJT	2006/02/06		WATER TREATMENT PLANT CHEMICAL FEED SYSTEMS MECHANICAL AND ELECTRICAL												
	<table border="1"> <tr> <td>01</td> <td>742-2005 ADDENDUM 3</td> <td>06/05/05</td> <td>SW</td> </tr> <tr> <td>00</td> <td>ISSUED FOR TENDER</td> <td>2006/02/03</td> <td>SW</td> </tr> </table>	01	742-2005 ADDENDUM 3	06/05/05		SW	00	ISSUED FOR TENDER	2006/02/03	SW	SCALE: 1:100	RELEASED FOR CONSTRUCTION BY: R. SOROKOWSKI	CONSULTANT DRAWING NO. WC-H9112	<table border="1"> <tr> <td>CITY FILE NUMBER</td> <td></td> </tr> <tr> <td>SHEET OF</td> <td></td> </tr> <tr> <td>CITY DRAWING NUMBER</td> <td>1-0601C-A-H9112-001-01D</td> </tr> </table>	CITY FILE NUMBER		SHEET OF	
01	742-2005 ADDENDUM 3	06/05/05	SW															
00	ISSUED FOR TENDER	2006/02/03	SW															
CITY FILE NUMBER																		
SHEET OF																		
CITY DRAWING NUMBER	1-0601C-A-H9112-001-01D																	