
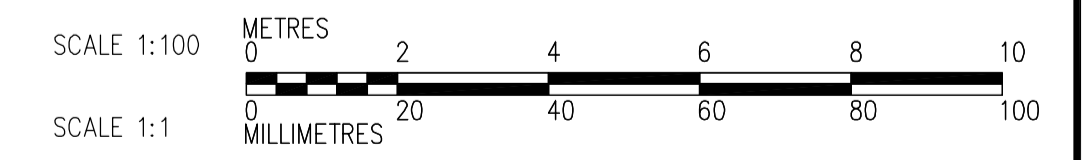
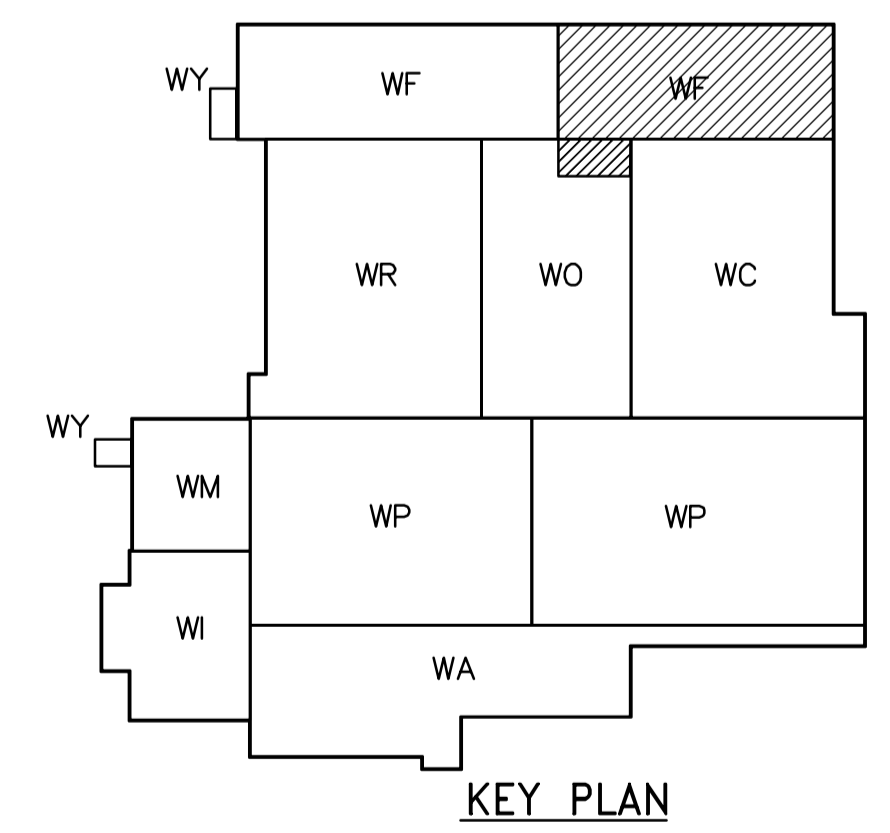


NOTES:

- SEE MCC #1A & #1B SINGLE LINE DIAGRAM AND DP-F03 AND DP-F04 POWER DISTRIBUTION FOR 600V POWER REQUIREMENT.
- ALL 120V AND 208V LOADS ARE FED FROM LP-F01
- PROVIDE STAIRWELL SMOKE DETECTORS AS SHOWN ON FIRE PROTECTION DRAWINGS

FOR CABLE TRAY TAGGING SEE DETAIL 3 WB-E0455

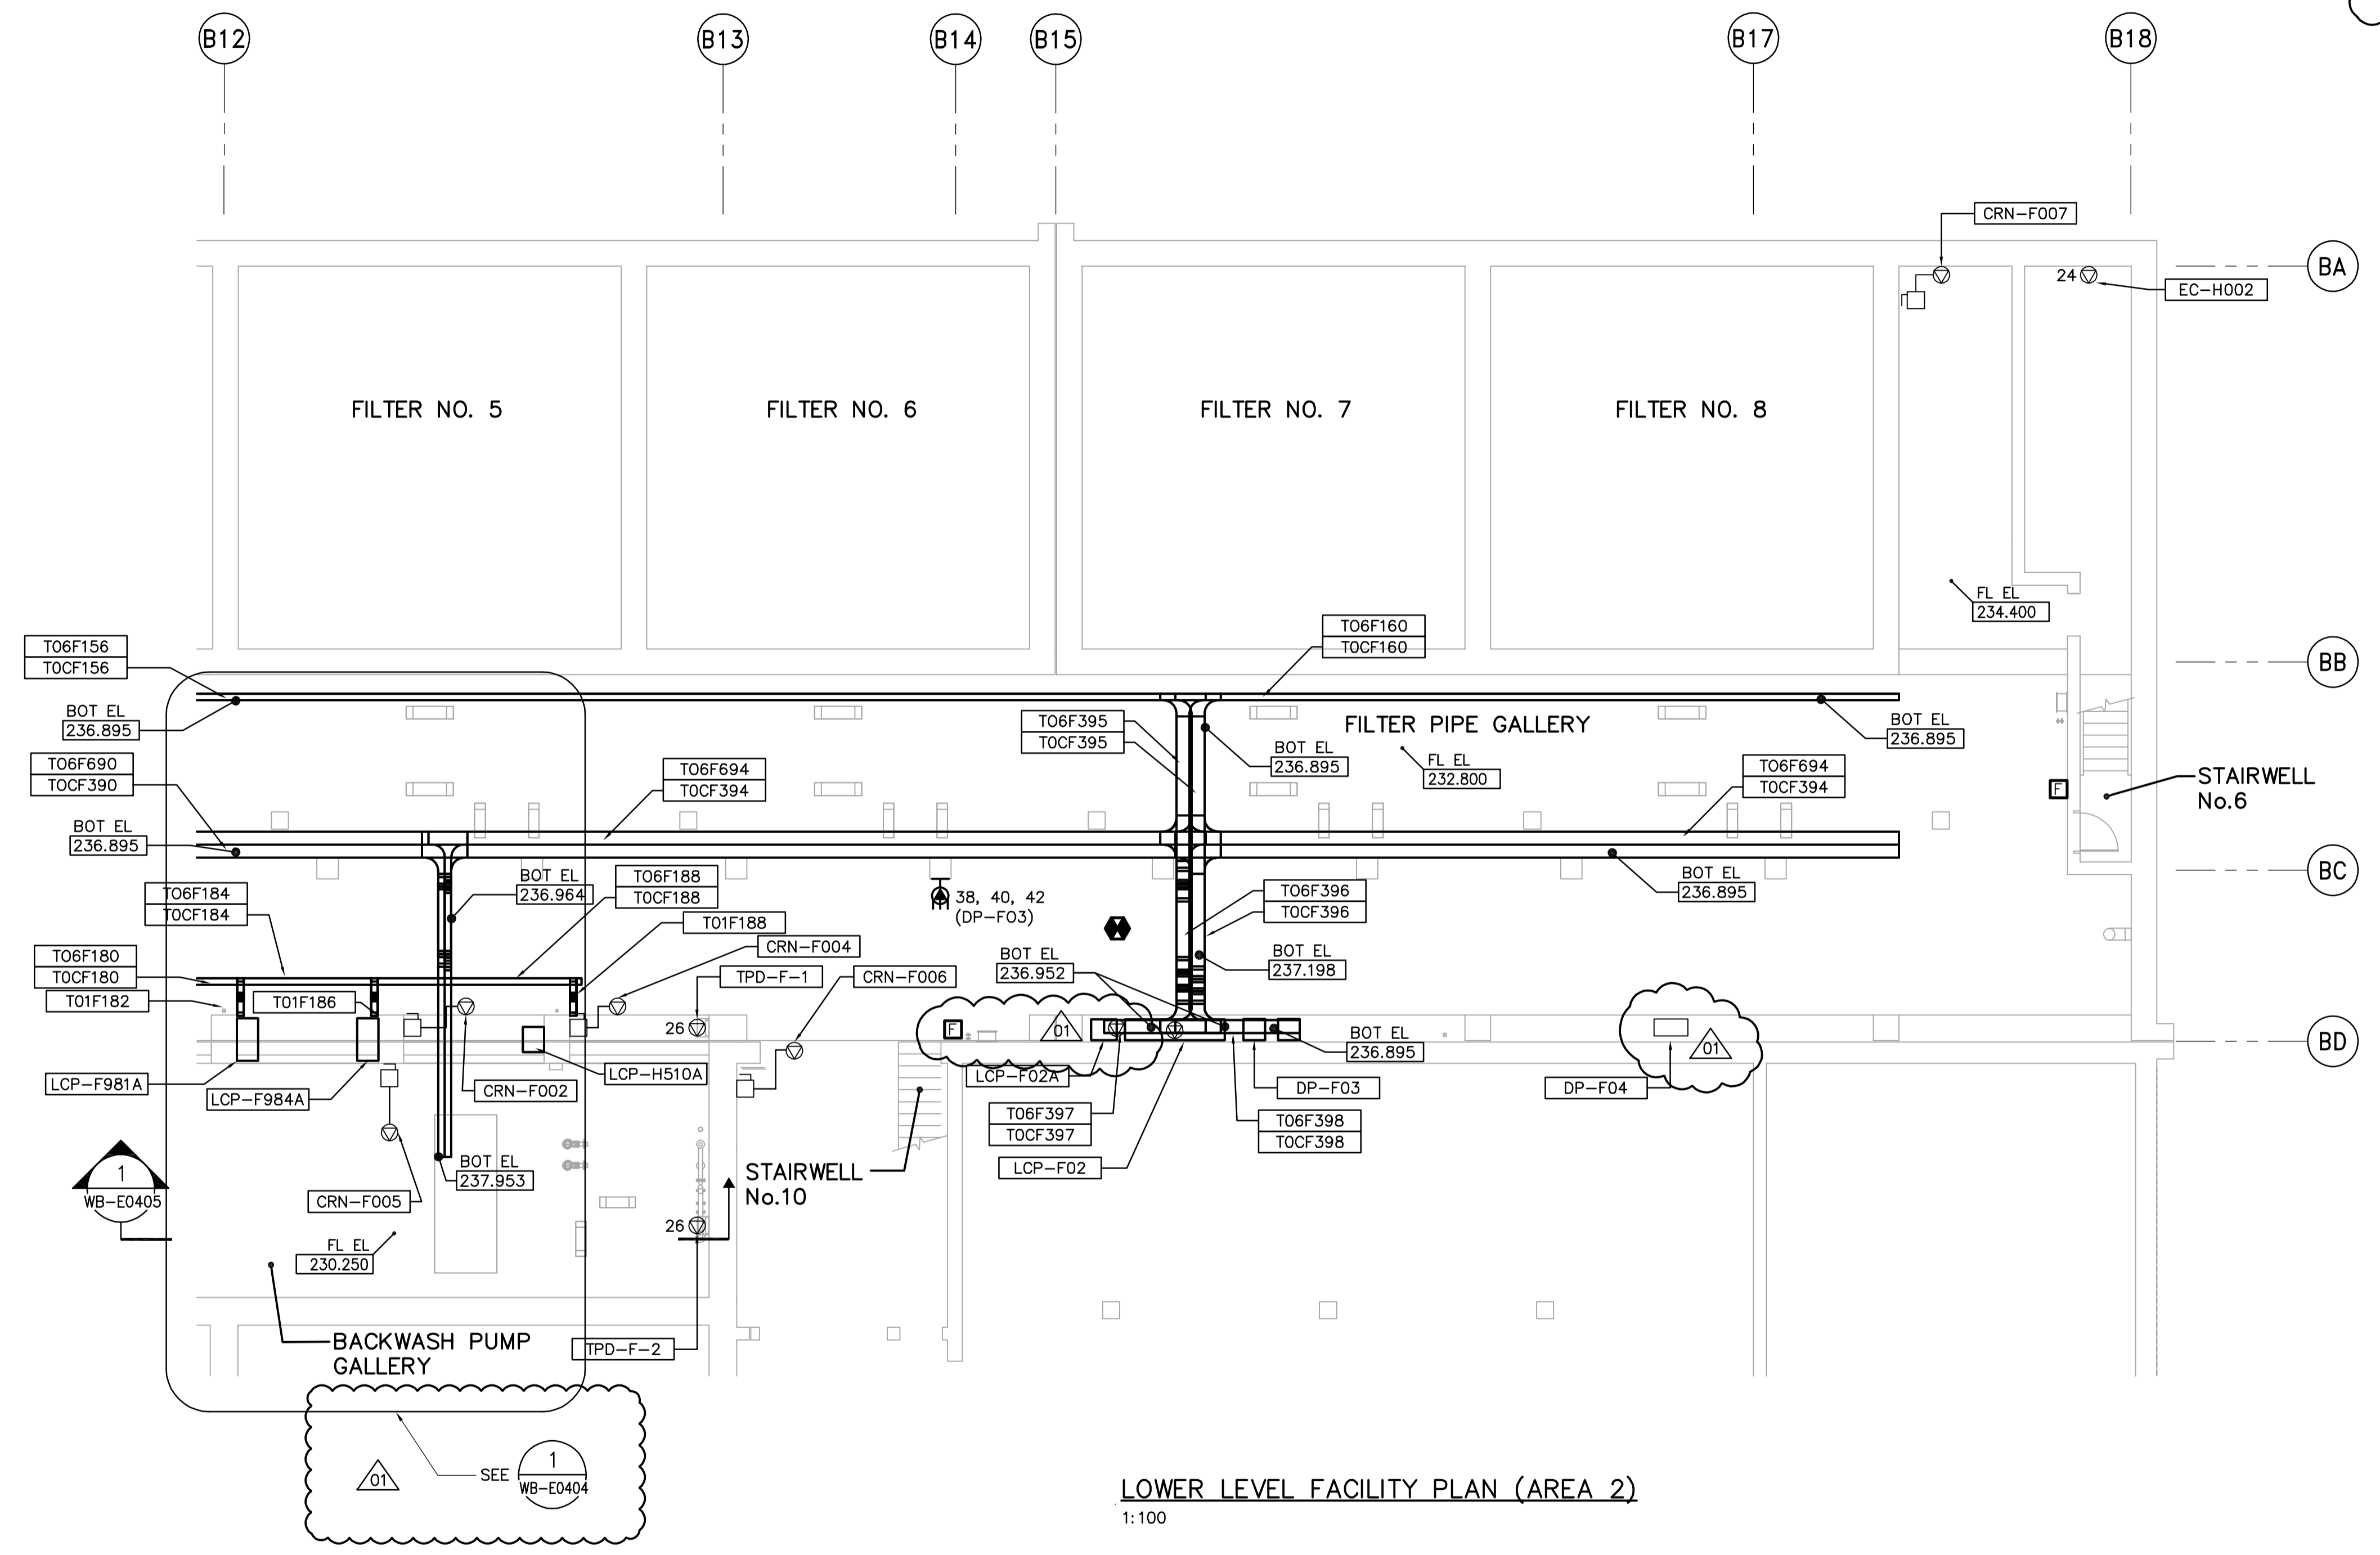

 APEGN Certificate of Authorization CH2M HILL Canada Ltd. No. 1441 Expiry: April 30, 2007	 Frederickson Cooper ARCHITECTS	 A Geo International Ltd. Company	ENGINEER'S SEAL ORIGINAL SIGNED BY L.D. LLEWELLYN 2006/03/29	 THE CITY OF WINNIPEG WATER AND WASTE DEPARTMENT ENGINEERING DIVISION	
	DESIGNED BY: JT CHECKED BY: ND	DRAWN BY: KJ APPROVED BY: AHL	SCALE: 1:100 RELEASED FOR CONSTRUCTION BY: R. SOROKOWSKI	CONSULTANT DRAWING NO. WF-E0102	WATER TREATMENT PLANT FILTRATION MECHANICAL AND ELECTRICAL
	NO. REVISIONS DATE BY	DATE 2005/07/13 DATE 2006/03/29	01 742-2005 ADDENDUM 3 06/05/05 LL 00 ISSUED FOR TENDER 06/03/29 LL	ELECTRICAL FILTRATION AREA 2 LOWER LEVEL FACILITY PLAN	CITY FILE NUMBER SHEET OF CITY DRAWING NUMBER 1-0601F-A-E0102-001-01D
					CITY DRAWING NUMBER 1-0601F-A-E0102-001-01D