

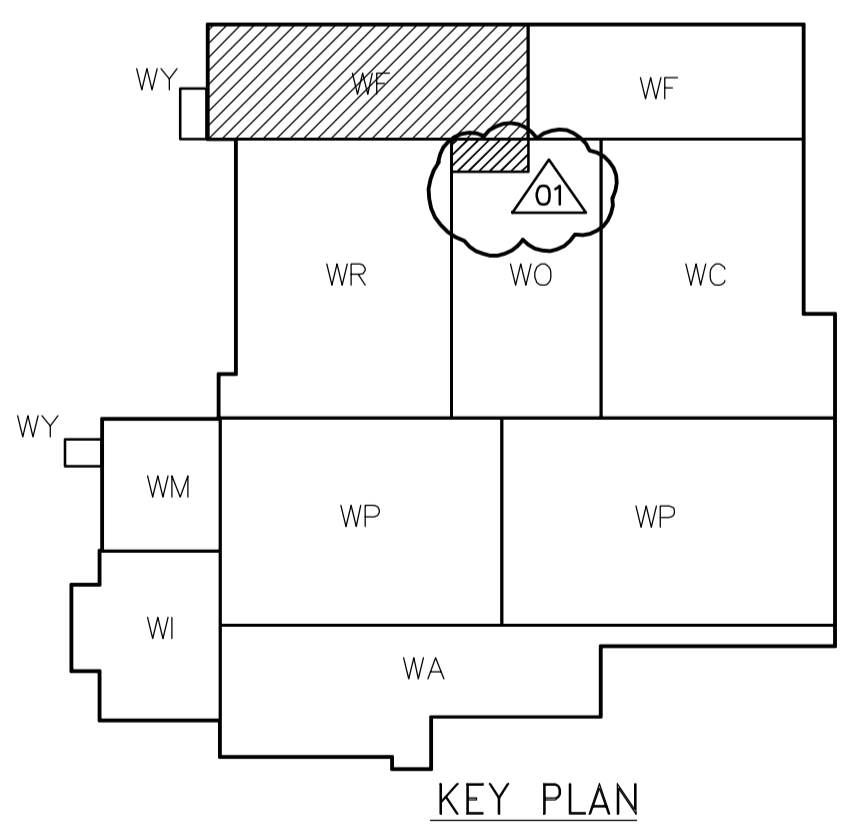


NOTES:

1. ALL 120V AND 208V LOADS ARE FED FROM LP-F01.
2. EMERGENCY LIGHTING EM-X-1, -2 ETC ARE FED FROM BATTERY PACK EM-X.
3. MOUNT TYPE A LUMINAIRE AT 3.2M ABOVE FINISHED FLOOR.

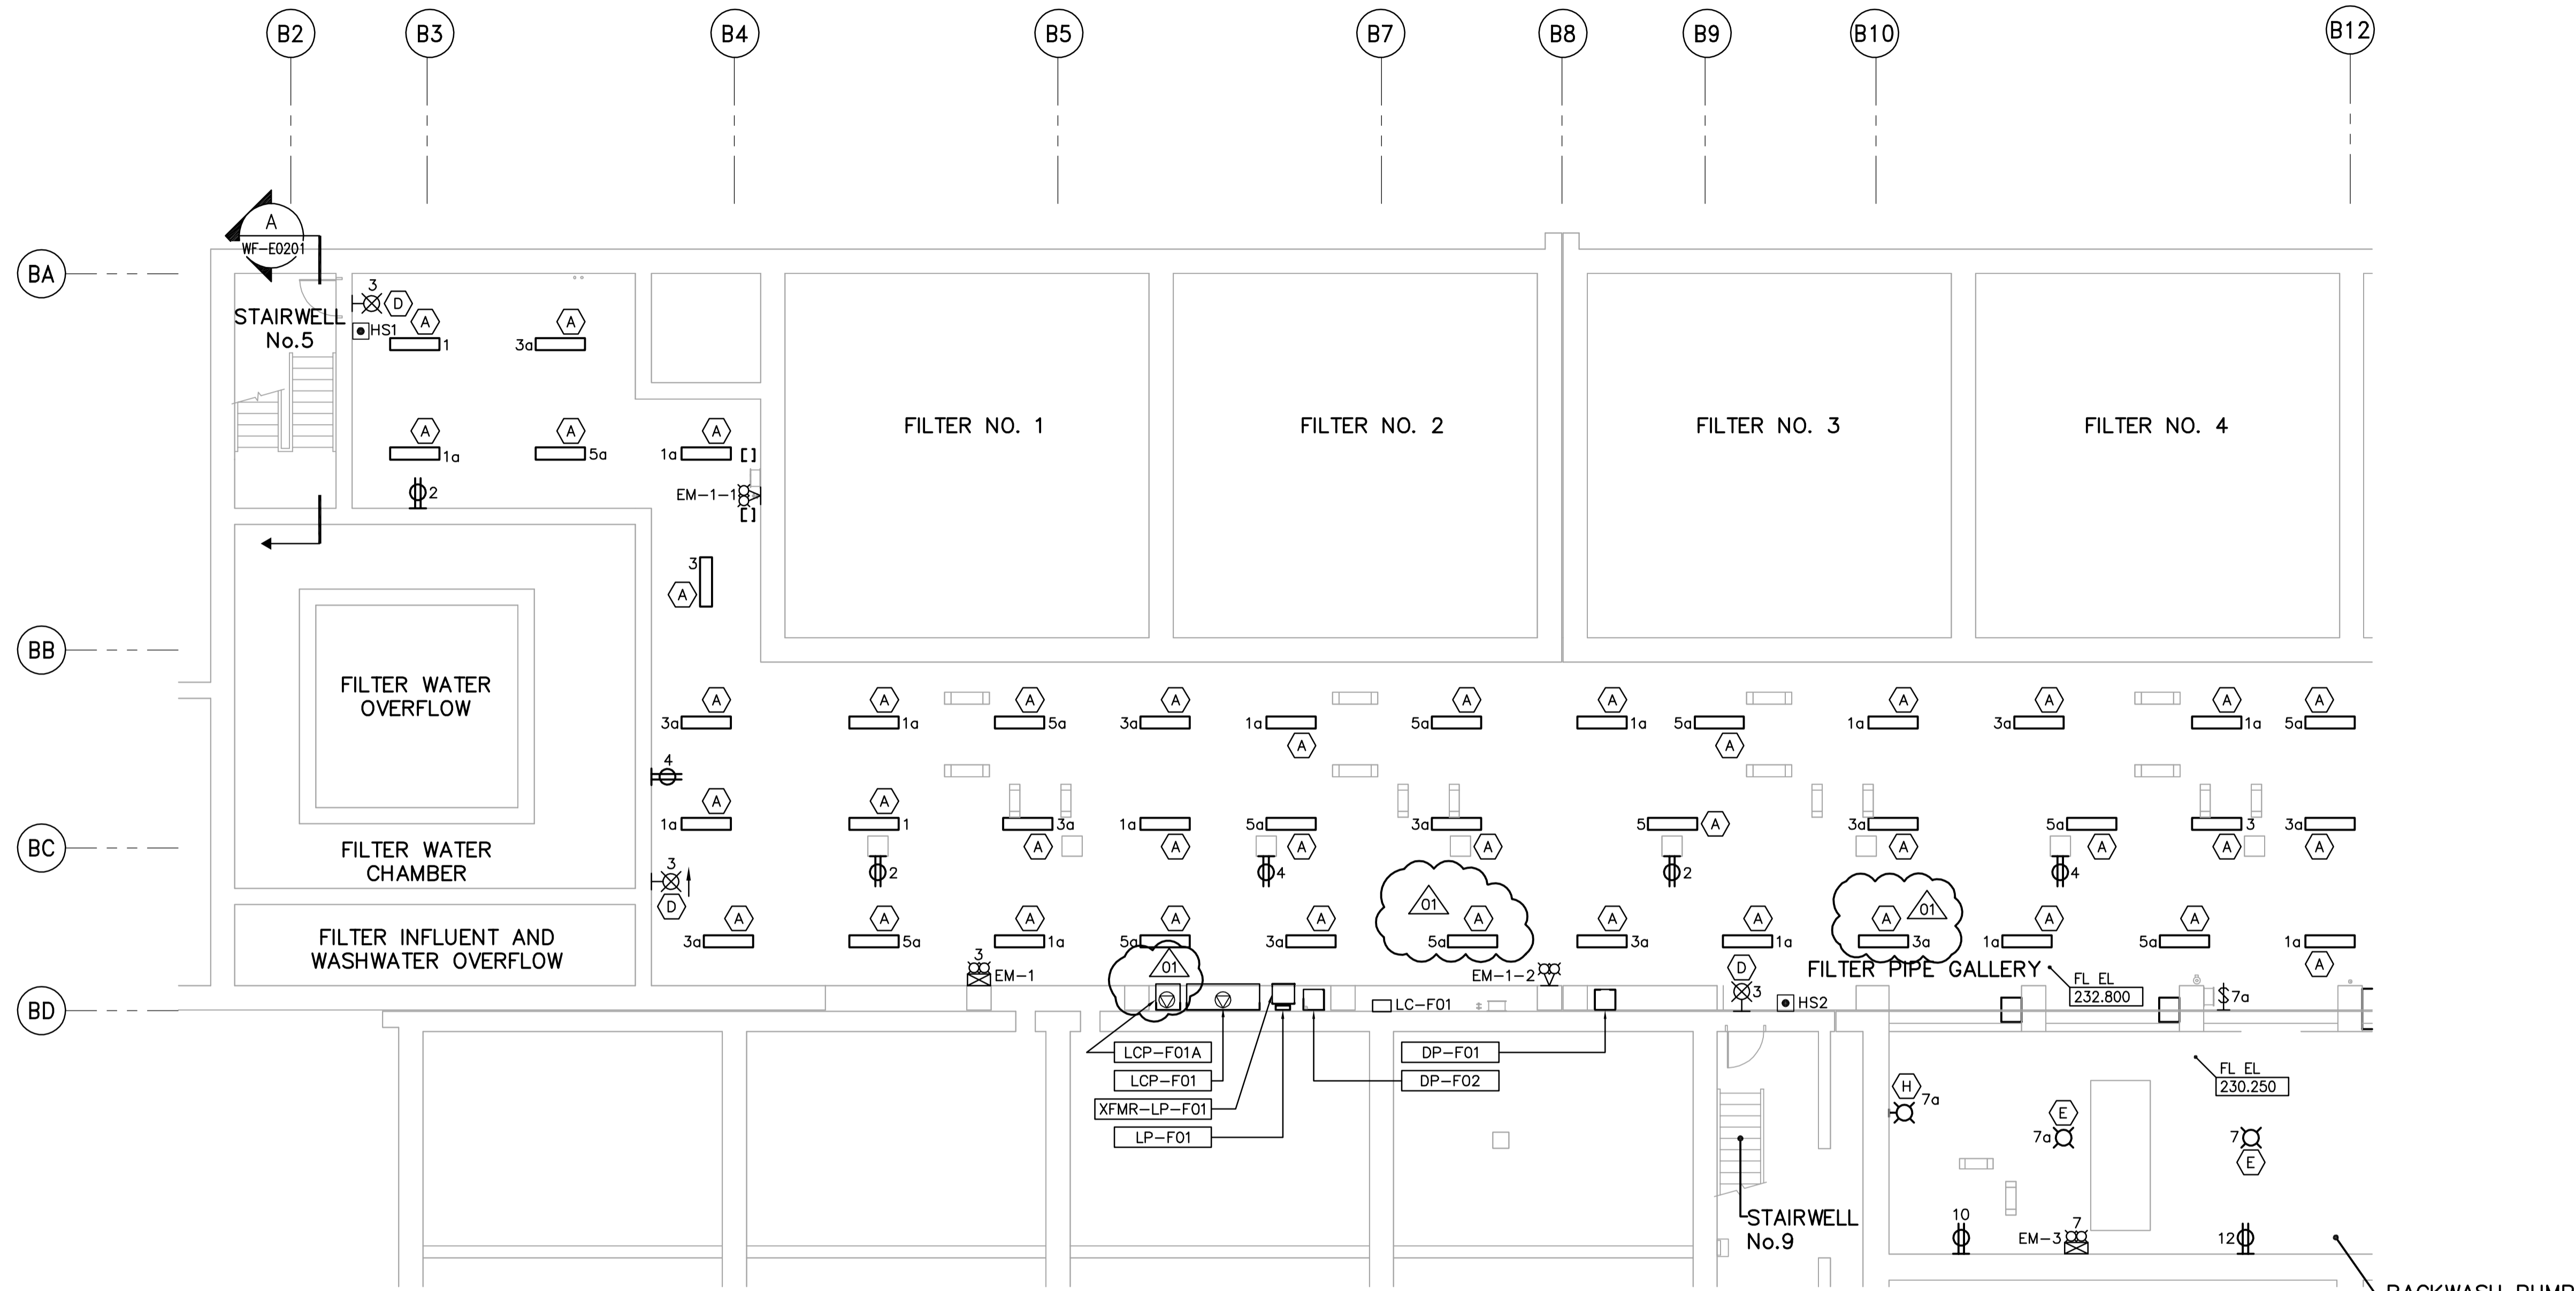

LOWER LEVEL POWER AND LIGHTING PLAN (AREA 1)
1:100

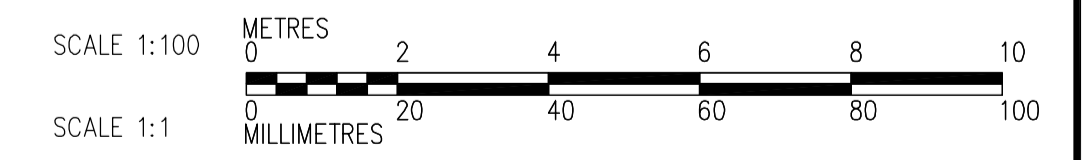

 APEGN Certificate of Authorization CH2M HILL Canada Ltd. No. 1441 Expiry: April 30, 2007	 Frederickson Cooper ARCHITECTS	 A Terra International Ltd. Company	ENGINEER'S SEAL ORIGINAL SIGNED BY L.D. LLEWELLYN 2006/03/29	 THE CITY OF WINNIPEG WATER AND WASTE DEPARTMENT ENGINEERING DIVISION	
	DESIGNED BY: JT CHECKED BY: ND	DRAWN BY: KJ APPROVED BY: AHL	SCALE: 1:100 RELEASED FOR CONSTRUCTION BY: R. SOROKOWSKI	CONSULTANT DRAWING NO. WF-E0105	WATER TREATMENT PLANT FILTRATION MECHANICAL AND ELECTRICAL
	NO. REVISIONS DATE BY	DATE 2005/07/13 DATE 2006/03/29	ELECTRICIAN FILTRATION AREA 1 LOWER LEVEL POWER AND LIGHTING PLAN	CITY FILE NUMBER SHEET OF CITY DRAWING NUMBER 1-0601F-A-E0105-001-01D	
	B.M. ELEV.		DATE 2005/07/13 DATE 2006/03/29		CITY DRAWING NUMBER 1-0601F-A-E0105-001-01D