




- NOTES:**
1. PROVIDE STAIRWELL SMOKE DETECTORS AS SHOWN ON FIRE PROTECTION DRAWINGS
 2. ALL 120V LOADS ARE FED FROM LP-R21
 3. SEE MCC 3A & 3B SINGLE LINE DIAGRAM FOR 600V POWER DISTRIBUTION

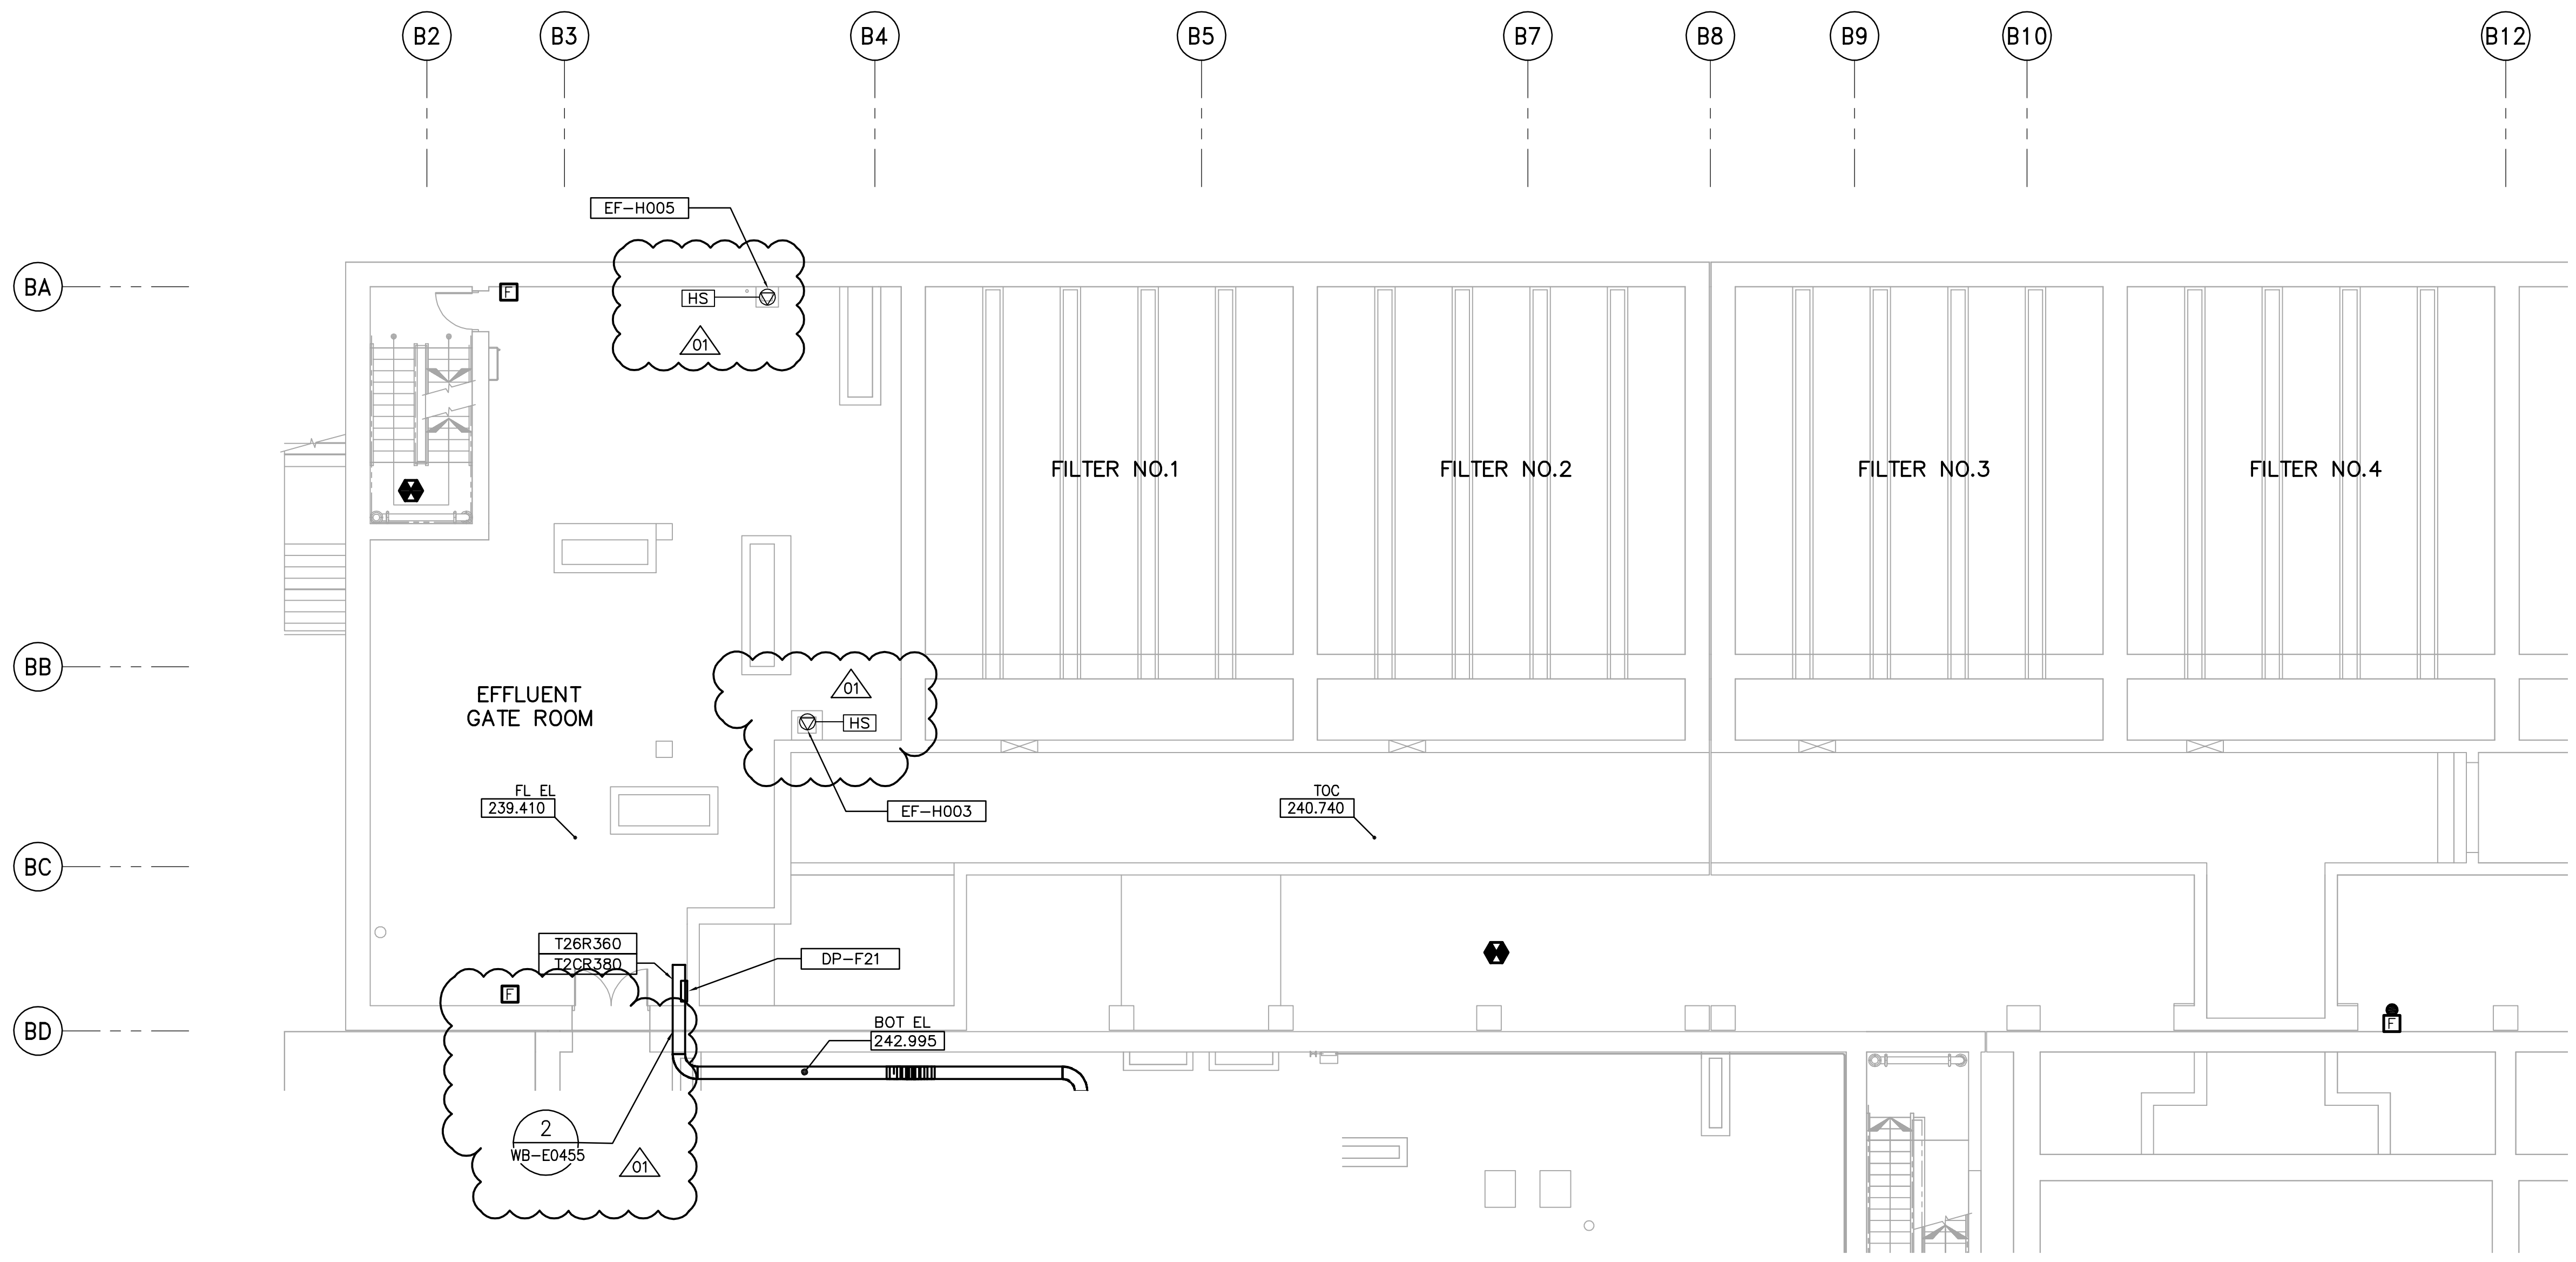

SECOND FLOOR FACILITY PLAN (AREA 1)
1:100

CABLE TRAY TAGGING
SEE DETAIL

3
WB-E0455

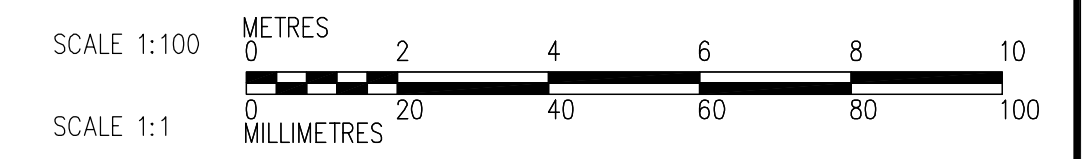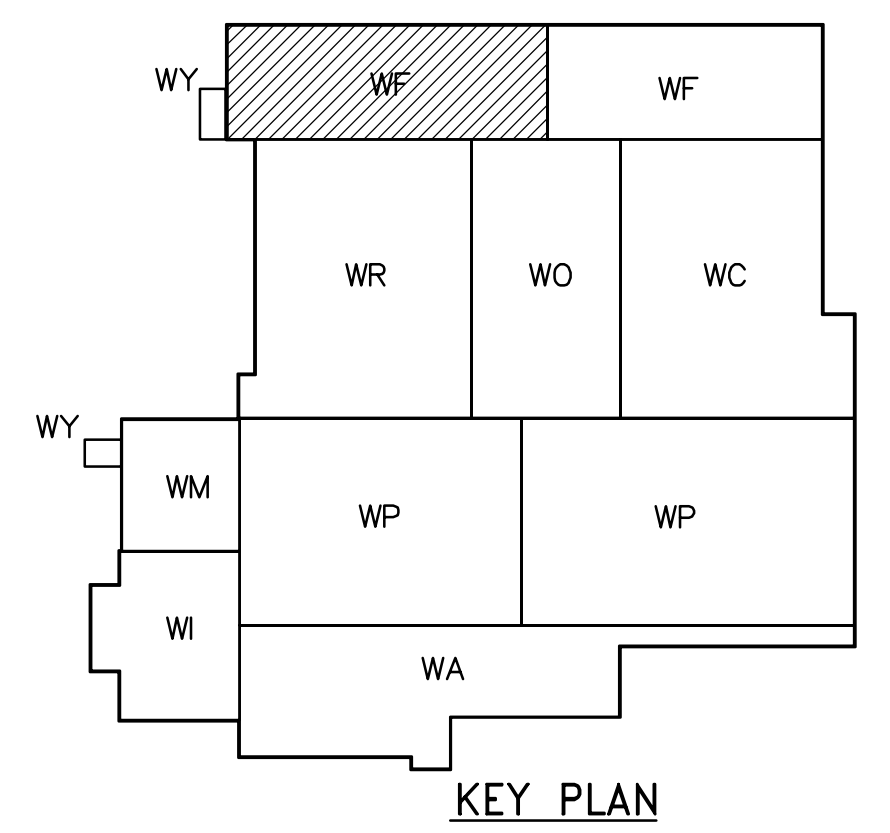

 APEGN Certificate of Authorization CH2M HILL Canada Ltd. No. 1441 Expiry: April 30, 2007	B.M. ELEV.	 Frederickson Cooper ARCHITECTS	 A Tyco International Ltd. Company	ENGINEER'S SEAL ORIGINAL SIGNED BY L.D. LLEWELLYN 2006/03/29	 THE CITY OF WINNIPEG WATER AND WASTE DEPARTMENT ENGINEERING DIVISION WATER TREATMENT PLANT FILTRATION MECHANICAL AND ELECTRICAL ELECTRICAL FILTRATION AREA 1 SECOND FLOOR FACILITY PLAN	CITY FILE NUMBER
	DESIGNED BY LL CHECKED BY ND	CONSULTANT DRAWING NO. WF-E0121	SHEET OF			
	DRAWN BY TL APPROVED BY AHL	RELEASED FOR CONSTRUCTION BY: R. SOROKOWSKI	CITY DRAWING NUMBER 1-0601F-A-E0121-001-01D			
	SCALE: 1:100	DATE 2005/07/08 DATE 2006/03/29				