





- NOTES:
- SEE MCC 4A & 4B SINGLE LINE DIAGRAMS AND DISTRIBUTION PANEL SCHEDULE DP-F32 FOR 600V POWER DISTRIBUTION
  - SEE DWG WB-E0403 FOR FILTER WIRING DETAILS

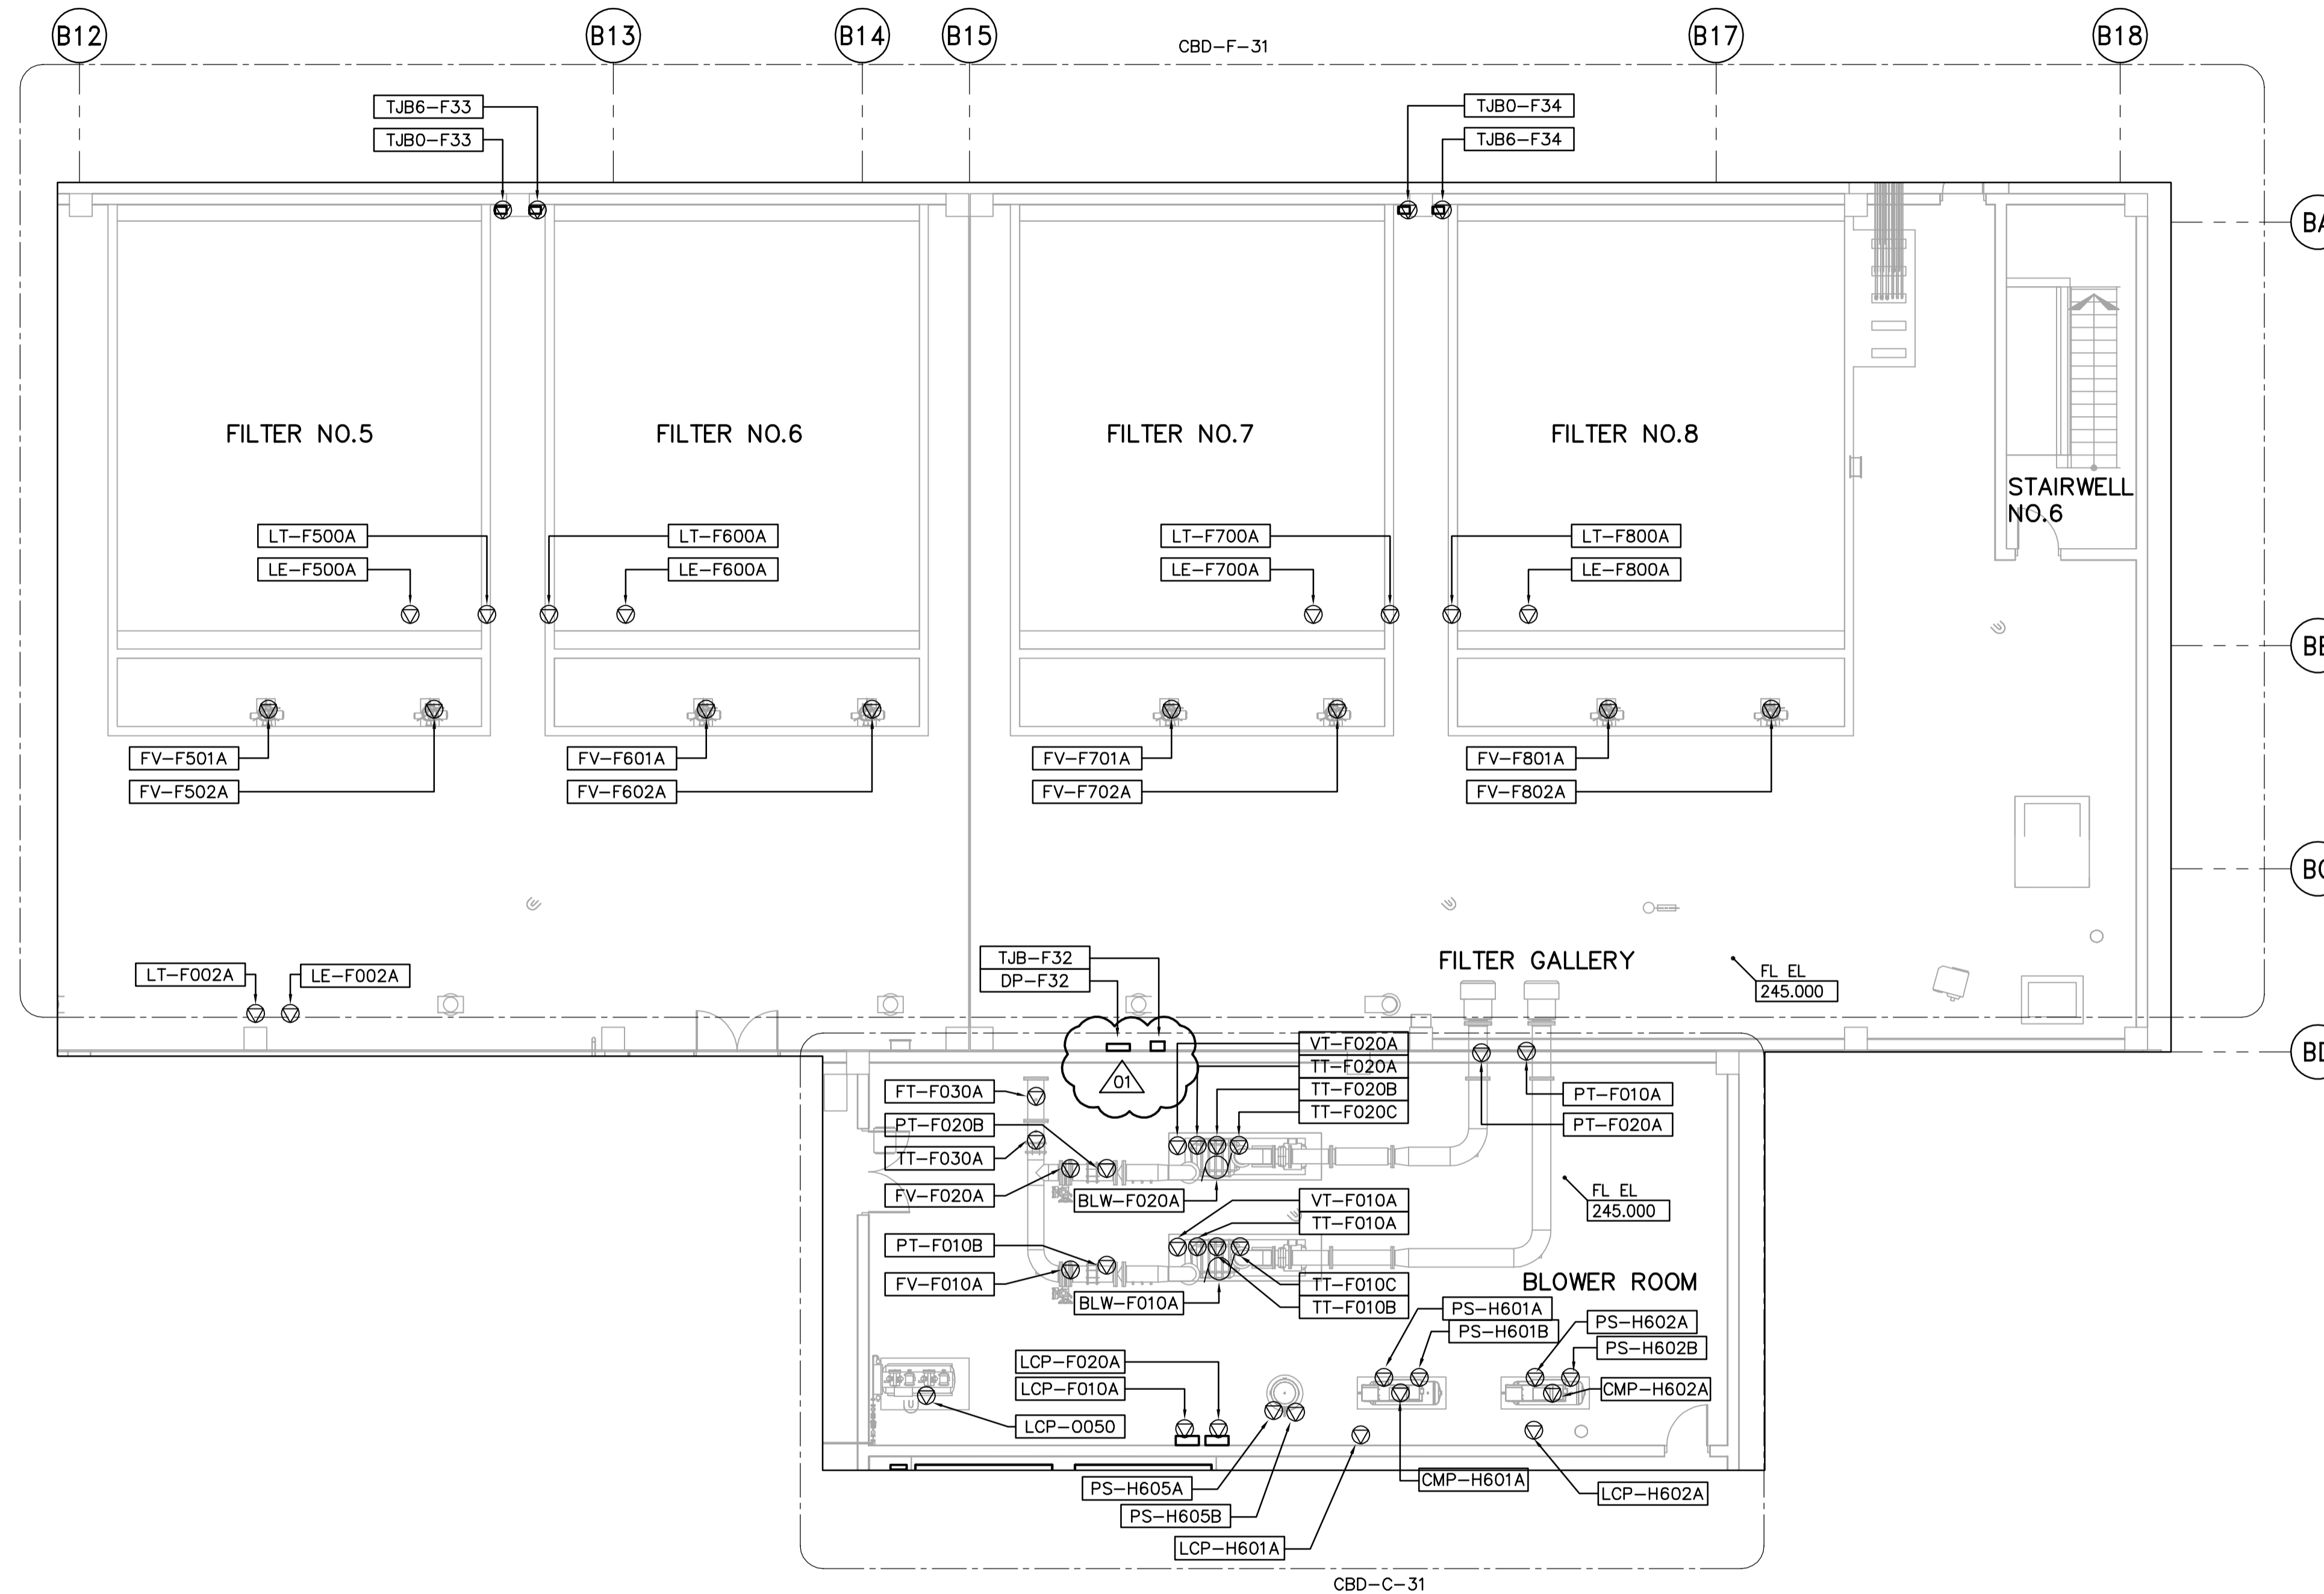

THIRD FLOOR PROCESS PLAN (AREA 2)  
1:100

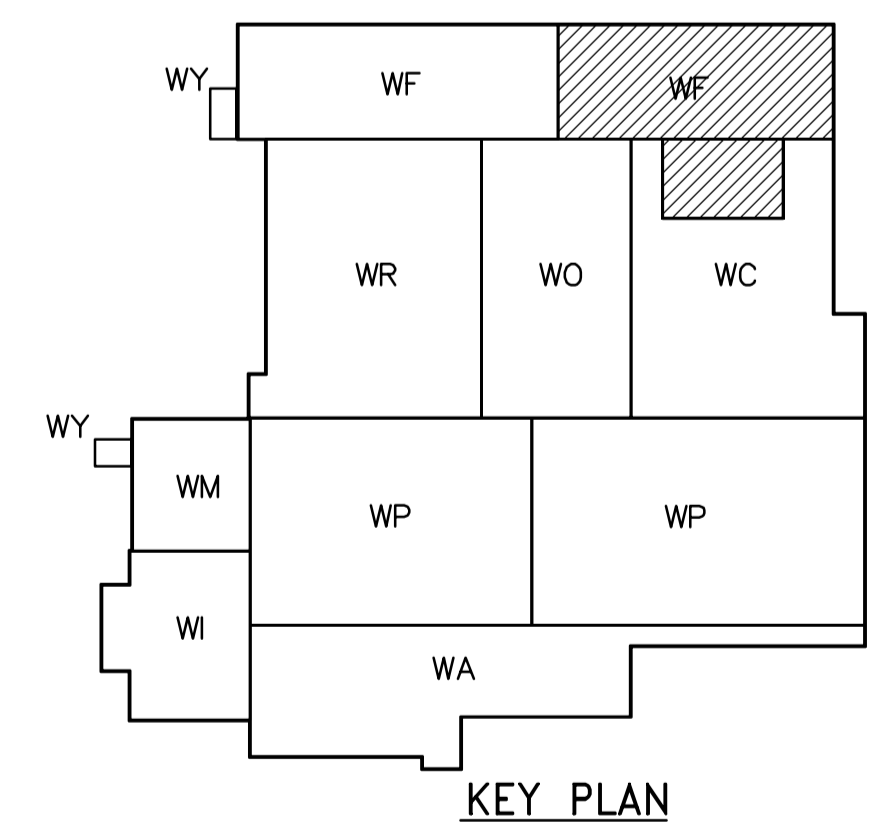

<p><b>APEGN</b> Certificate of Authorization CH2M HILL Canada Ltd. No. 1441 Expiry: April 30, 2007</p>	<p>B.M. ELEV.</p> <table border="1"> <tr><td> </td><td> </td><td> </td></tr> <tr><td> </td><td> </td><td> </td></tr> <tr><td> </td><td> </td><td> </td></tr> <tr><td> </td><td> </td><td> </td></tr> </table>													<p>Frederickson Cooper ARCHITECTS</p>	<p>A You International Ltd. Company</p>	ENGINEER'S SEAL	<p><b>THE CITY OF WINNIPEG</b> WATER AND WASTE DEPARTMENT ENGINEERING DIVISION</p>					
DESIGNED BY LL	CHECKED BY ND	ORIGINAL SIGNED BY L.D. LLEWELLYN																				
DRAWN BY PS	APPROVED BY AHL	2006/03/29																				
SCALE: 1:100	RELEASED FOR CONSTRUCTION BY: R. SOROKOWSKI	CONSULTANT DRAWING NO. WF-E0134																				
<table border="1"> <tr> <th>NO.</th> <th>REVISIONS</th> <th>DATE</th> <th>BY</th> <th>DATE</th> <th>DATE</th> </tr> <tr> <td>01</td> <td>742-2005 ADDENDUM 3</td> <td>06/05/05</td> <td>LL</td> <td> </td> <td> </td> </tr> <tr> <td>00</td> <td>ISSUED FOR TENDER</td> <td>06/03/29</td> <td>LL</td> <td> </td> <td> </td> </tr> </table>		NO.	REVISIONS	DATE	BY	DATE	DATE	01	742-2005 ADDENDUM 3	06/05/05	LL			00	ISSUED FOR TENDER	06/03/29	LL			<p>WATER TREATMENT PLANT FILTRATION MECHANICAL AND ELECTRICAL</p>		CITY FILE NUMBER
NO.	REVISIONS	DATE	BY	DATE	DATE																	
01	742-2005 ADDENDUM 3	06/05/05	LL																			
00	ISSUED FOR TENDER	06/03/29	LL																			
<p>2005/07/13</p>		<p>2006/03/29</p>		<p>ELECTRICAL FILTRATION AREA 2 THIRD FLOOR PROCESS PLAN</p>		SHEET OF																
<p> </p>		<p> </p>		<p> </p>		CITY DRAWING NUMBER																
<p> </p>		<p> </p>		<p> </p>		1-0601F-A-E0134-001-01D																