



FIRST FLOOR PLAN
1:100

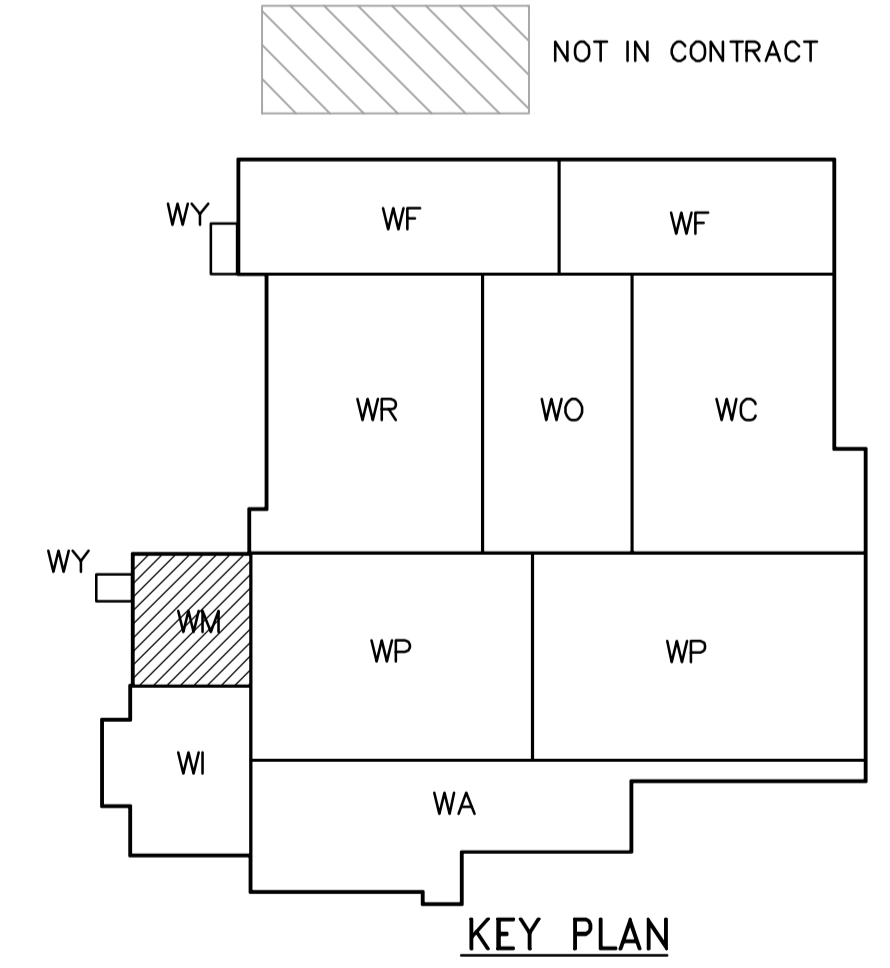

KEY PLAN

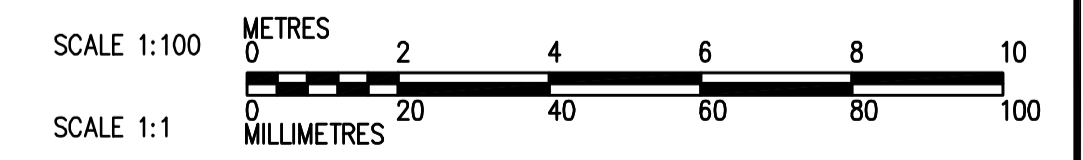

 APEGN Certificate of Authorization CH2M HILL Canada Ltd. No. 1441 Expiry: April 30, 2007	B.M. ELEV. <table border="1"> <tr><td> </td><td> </td><td> </td></tr> <tr><td> </td><td> </td><td> </td></tr> <tr><td> </td><td> </td><td> </td></tr> </table>										 Frederickson Cooper ARCHITECTS	 A Terra International Ltd. Company	ENGINEER'S SEAL	 THE CITY OF WINNIPEG WATER AND WASTE DEPARTMENT ENGINEERING DIVISION
DESIGNED BY JZ/SW	CHECKED BY DL	ORIGINAL SIGNED BY D.K. CUDDINGTON	CITY FILE NUMBER											
DRAWN BY JMcP	APPROVED BY DJT	2006/02/06	SHEET OF											
SCALE: 1:100		RELEASED FOR CONSTRUCTION BY: R. SOROKOWSKI	CONSULTANT DRAWING NO. WM-H9112	CITY DRAWING NUMBER 1-0601M-A-H9112-001-01D	PLUMBING PIPE EMBEDS FIRE PUMP AND ELECTRICAL ROOM FIRST FLOOR PLAN									
NO. REVISIONS	DATE BY	DATE	DATE											