



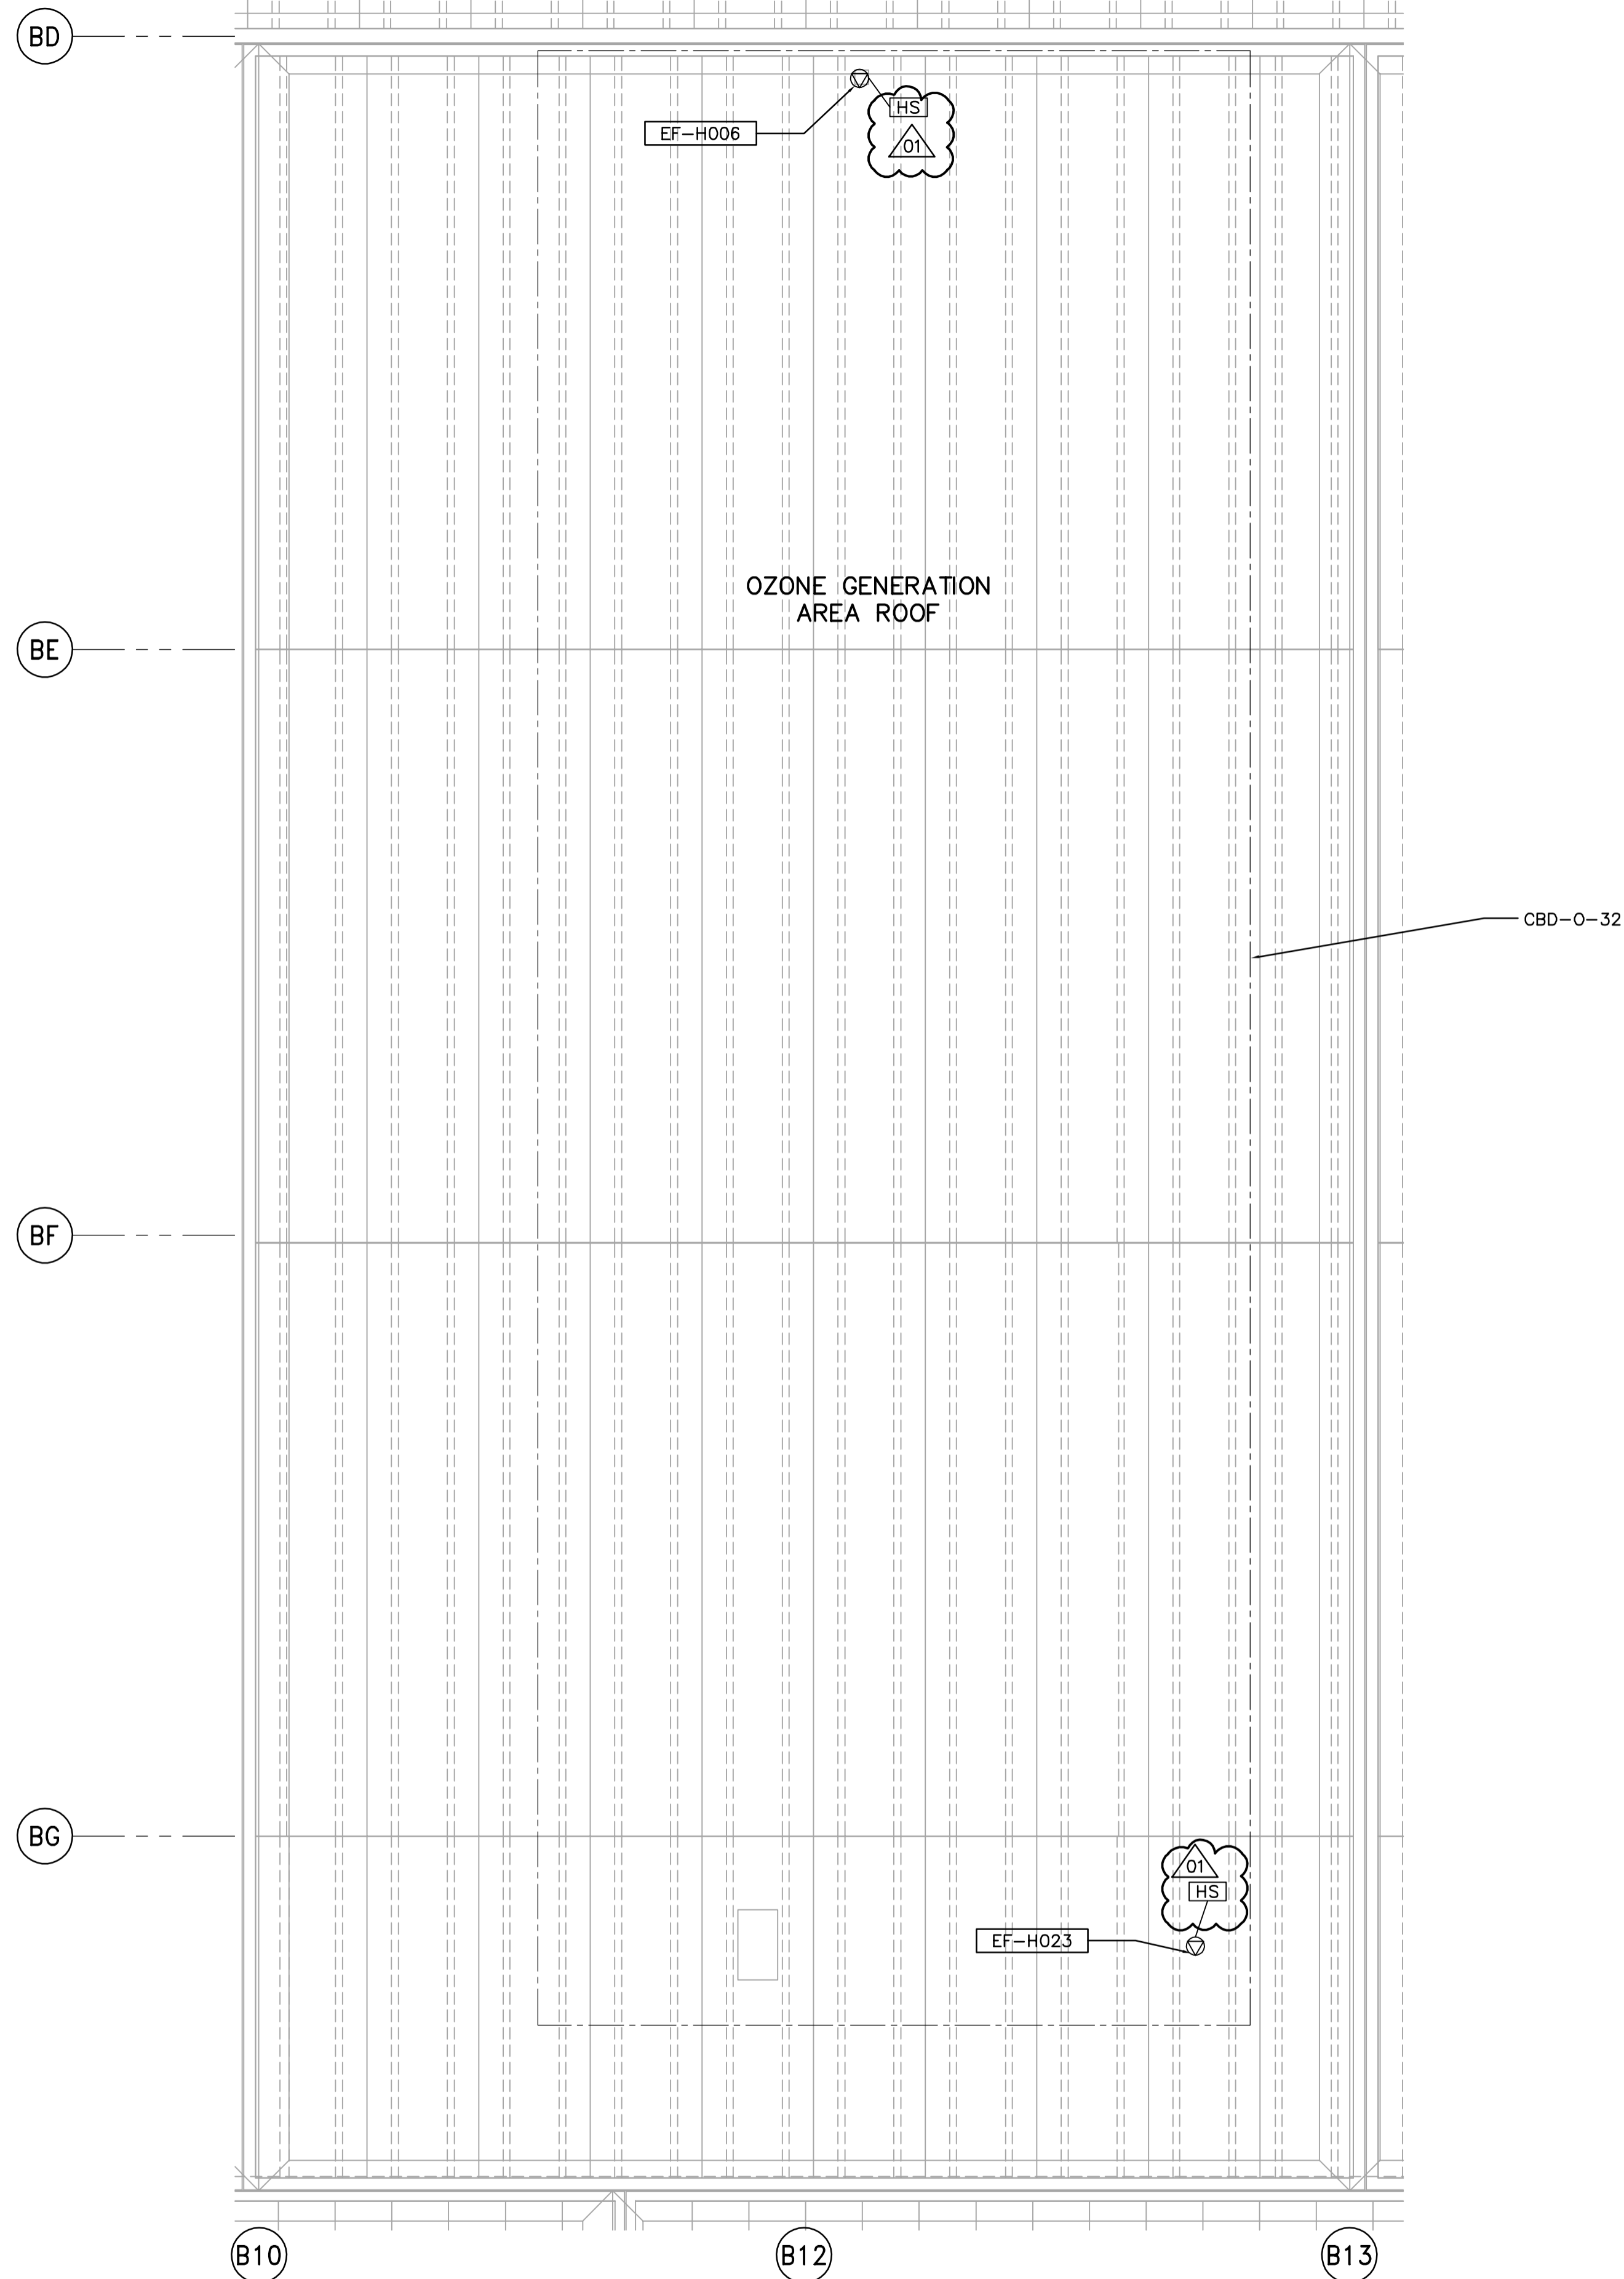

**ROOF AREA FACILITY PLAN**  
1:100

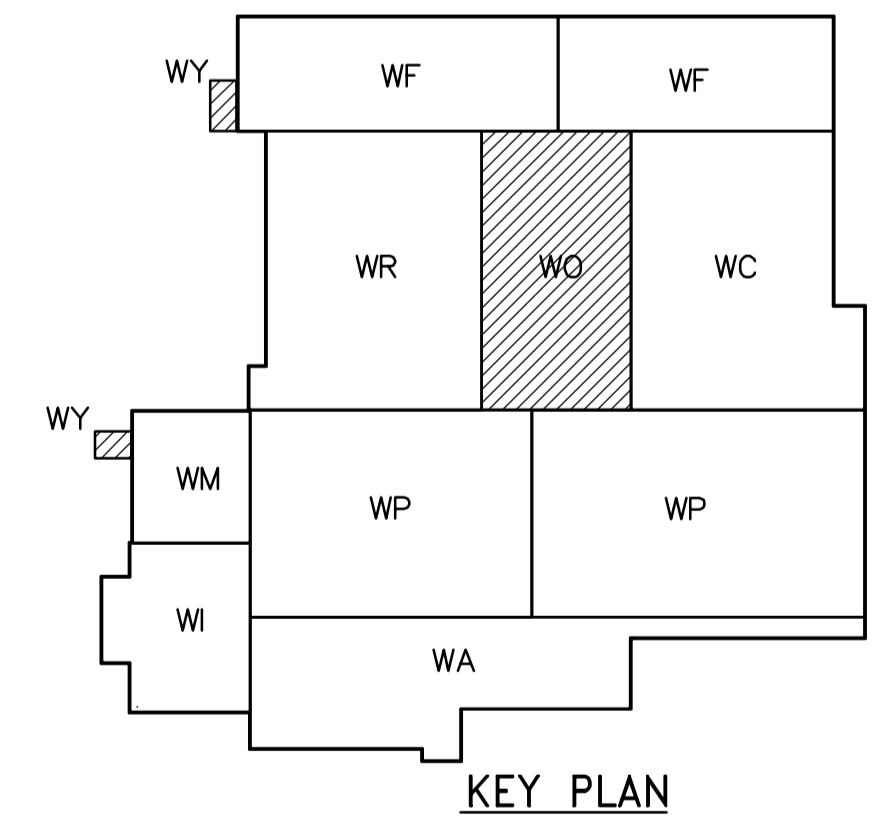

- NOTES**  
 1. SEE MCC 4B SINGLE LINE DIAGRAM FOR 600V POWER DISTRIBUTION.  
 2. ALL 120V AND 208V LOADS ARE FED FROM LP-H31.



 Certificate of Authorization CH2M HILL Canada Ltd. No. 1441 Expiry: April 30, 2007	B.M. ELEV.	 Frederickson Cooper ARCHITECTS	 A Geo International Ltd. Company	ENGINEER'S SEAL	 THE CITY OF WINNIPEG WATER AND WASTE DEPARTMENT ENGINEERING DIVISION
	DESIGNED BY LL DRAWN BY TL SCALE: 1:100			CHECKED BY ND APPROVED BY AHL RELEASED FOR CONSTRUCTION BY: R. SOROKOWSKI	
01 742-2005 ADDENDUM 3 06/05/05 LL 00 ISSUED FOR TENDER 06/03/26 LL	INO. REVISIONS DATE BY DATE 2006/03/06 DATE 2006/03/29	CONSULTANT DRAWING NO. WO-E0145		CITY FILE NUMBER SHEET OF CITY DRAWING NUMBER 1-06010-A-E0145-001-01D	