



NOTES:  
 1. SEE MCC #2A & #2B SINGLE LINE DIAGRAM AND DP-P11 & DP-P12 POWER DISTRIBUTION FOR 600V POWER DISTRIBUTION.  
 2. ALL 120 AND 208V LOADS ARE FED FROM LP-P11

BH  
 BJ  
 BK  
 BL  
 BM

DAF TANKS NO. 5 & NO. 6  
 DAF TANKS NO. 7 & NO. 8

FLOCCULATION TANK 5  
 FLOCCULATION TANK 6  
 FLOCCULATION TANK 7  
 FLOCCULATION TANK 8

FIRST FLOOR PROCESS PLAN (AREA 2)  
 1:100

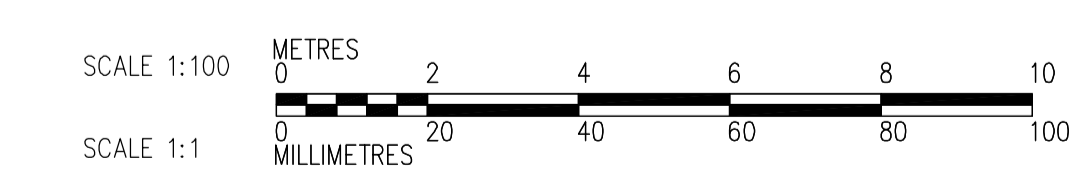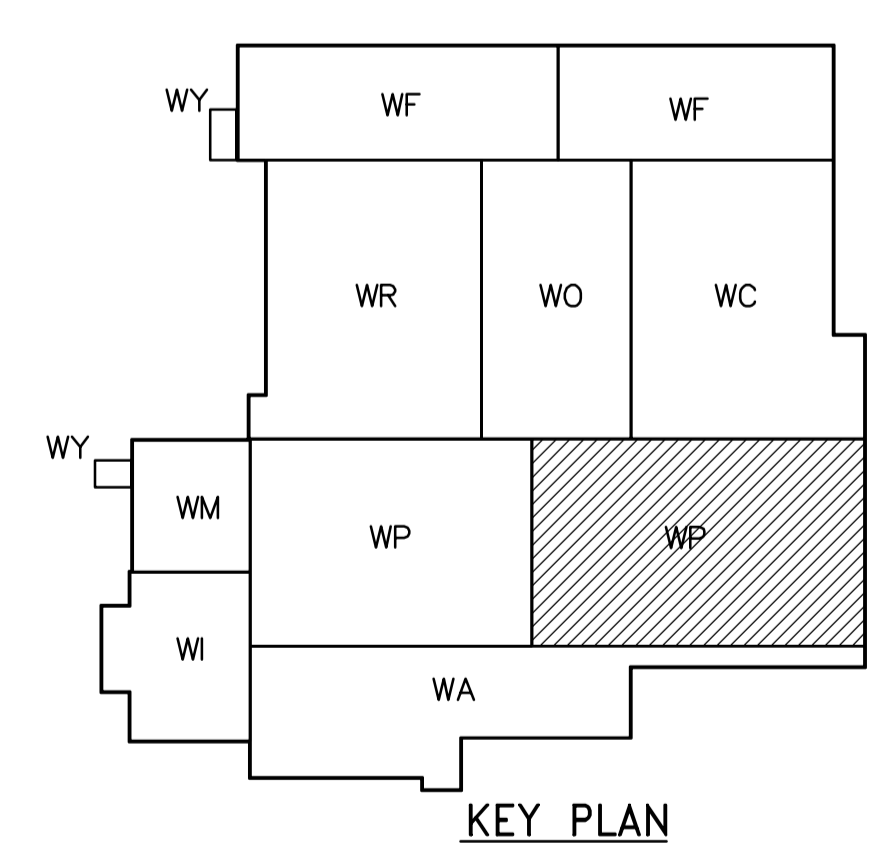

 Certificate of Authorization CH2M HILL Canada Ltd. No. 1441 Expiry: April 30, 2007	 Frederickson Cooper ARCHITECTS	 A Terra International Ltd. Company	ENGINEER'S SEAL ORIGINAL SIGNED BY L.D. LLEWELLYN 2006/03/29	 THE CITY OF WINNIPEG WATER AND WASTE DEPARTMENT ENGINEERING DIVISION WATER TREATMENT PLANT FLOCCULATION AND DAF MECHANICAL AND ELECTRICAL	CITY FILE NUMBER
			CONSULTANT DRAWING NO. WP-E0114		SHEET OF
DESIGNED BY JT CHECKED BY ND DRAWN BY KJ APPROVED BY AHL SCALE: 1:100 RELEASED FOR CONSTRUCTION BY: R. SOROKOWSKI DATE 2005/07/12 DATE 2006/03/29	B.M. ELEV.	ELECTRICAL FLOC/DAF AREA 2 FIRST FLOOR PROCESS PLAN	CITY DRAWING NUMBER 1-0601P-A-E0114-001-01D		
NO. REVISIONS 01 742-2005 ADDENDUM 3 06/05/05 LL 00 ISSUED FOR TENDER 06/03/29 LL					