
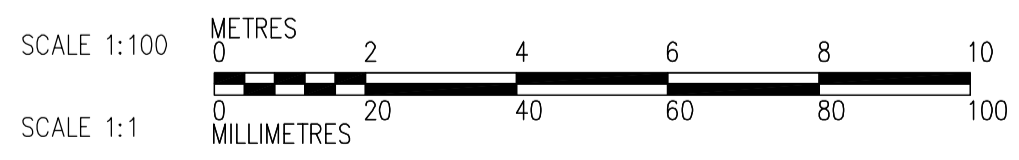


FIRST FLOOR PLAN
1:100

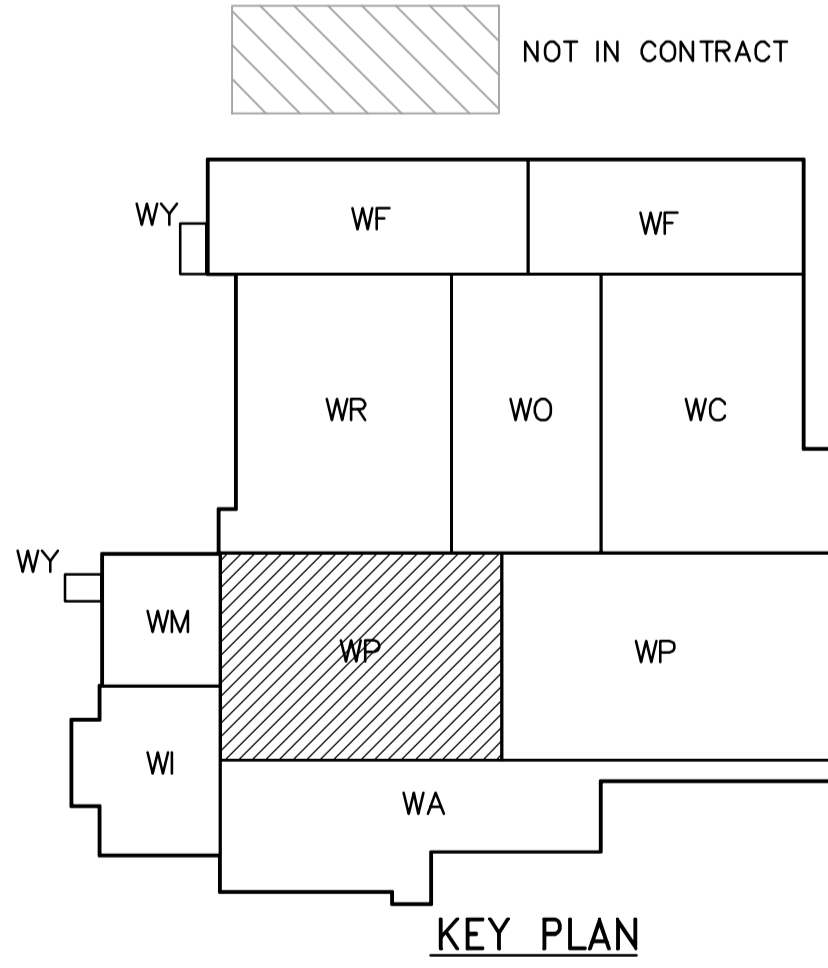

 APEGN Certificate of Authorization CH2M HILL Canada Ltd. No. 1441 Expiry: April 30, 2007	B.M. ELEV.	 Frederickson Cooper ARCHITECTS	 A Terra International Ltd. Company	ENGINEER'S SEAL ORIGINAL SIGNED BY D.K. CUDDINGTON 2006/02/06	 THE CITY OF WINNIPEG WATER AND WASTE DEPARTMENT ENGINEERING DIVISION WATER TREATMENT PLANT FLOCCULATION AND DAF MECHANICAL AND ELECTRICAL PLUMBING PIPE EMBEDS FLOC/DAF AREA 1 FIRST FLOOR PLAN	CITY FILE NUMBER
	DESIGNED BY JZ/SW CHECKED BY DL			CONSULTANT DRAWING NO. WP-H9113		SHEET OF
	DRAWN BY JMcP APPROVED BY DJT			RELEASED FOR CONSTRUCTION BY: R. SOROKOWSKI		CITY DRAWING NUMBER 1-0601P-A-H9113-001-01D
	SCALE: 1:100 INO. REVISIONS DATE BY DATE 2005/07/15 DATE 2006/02/08			DATE 2006/02/03 SW		DATE 2006/02/08