


THIRD FLOOR PLAN  
1:100

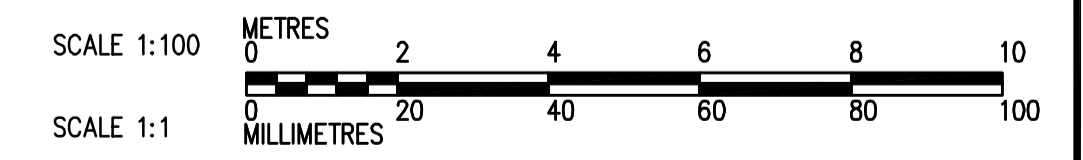

<p><b>APEGN</b> Certificate of Authorization CH2M HILL Canada Ltd. No. 1441 Expiry: April 30, 2007</p>	<p>B.M. ELEV.</p> <table border="1"> <tr><td> </td><td> </td><td> </td></tr> <tr><td> </td><td> </td><td> </td></tr> <tr><td> </td><td> </td><td> </td></tr> <tr><td> </td><td> </td><td> </td></tr> </table>													<p>Frederickson Cooper ARCHITECTS</p>	<p>EarthTech A Tyco International Ltd. Company</p>	<p>ENGINEER'S SEAL</p> <p>ORIGINAL SIGNED BY D.K. CUDDINGTON</p> <p>2006/02/06</p>	<p><b>THE CITY OF WINNIPEG</b> WATER AND WASTE DEPARTMENT ENGINEERING DIVISION</p> <p>WATER TREATMENT PLANT FLOCCULATION AND DAF MECHANICAL AND ELECTRICAL</p> <p>PLUMBING PIPE EMBEDS FLOC/DAF AREA 2 THIRD FLOOR PLAN</p>			
<table border="1"> <tr><td>01</td><td>742-2005 ADDENDUM 3</td><td>06/05/05</td><td>SW</td></tr> <tr><td>00</td><td>ISSUED FOR TENDER</td><td>2006/02/03</td><td>SW</td></tr> </table>	01	742-2005 ADDENDUM 3	06/05/05	SW	00	ISSUED FOR TENDER	2006/02/03	SW	<table border="1"> <tr><td>DESIGNED BY</td><td>JZ/SW</td><td>CHECKED BY</td><td>DL</td></tr> <tr><td>DRAWN BY</td><td>JMcP</td><td>APPROVED BY</td><td>DJT</td></tr> </table>	DESIGNED BY	JZ/SW	CHECKED BY	DL	DRAWN BY	JMcP	APPROVED BY	DJT	<p>SCALE: 1:100</p> <p>RELEASED FOR CONSTRUCTION BY: R. SOROKOWSKI</p>	<p>CONSULTANT DRAWING NO. WP-H9134</p>	<p>CITY FILE NUMBER</p> <p>SHEET OF</p> <p>CITY DRAWING NUMBER 1-0601P-A-H9134-001-01D</p>
01	742-2005 ADDENDUM 3	06/05/05	SW																	
00	ISSUED FOR TENDER	2006/02/03	SW																	
DESIGNED BY	JZ/SW	CHECKED BY	DL																	
DRAWN BY	JMcP	APPROVED BY	DJT																	
<table border="1"> <tr><th>NO.</th><th>REVISIONS</th><th>DATE</th><th>BY</th></tr> <tr><td> </td><td> </td><td> </td><td> </td></tr> </table>	NO.	REVISIONS	DATE	BY					<p>DATE 2005/07/15</p> <p>DATE 2006/02/08</p>	<p>DATE 2006/02/08</p>	<p>DATE 2006/02/08</p>	<p>DATE 2006/02/08</p>								
NO.	REVISIONS	DATE	BY																	
<p> </p>	<p> </p>	<p> </p>	<p> </p>	<p> </p>																