




V SECTION - OZONE CONTACTOR DRAIN LINE
WP-M9108 1:50

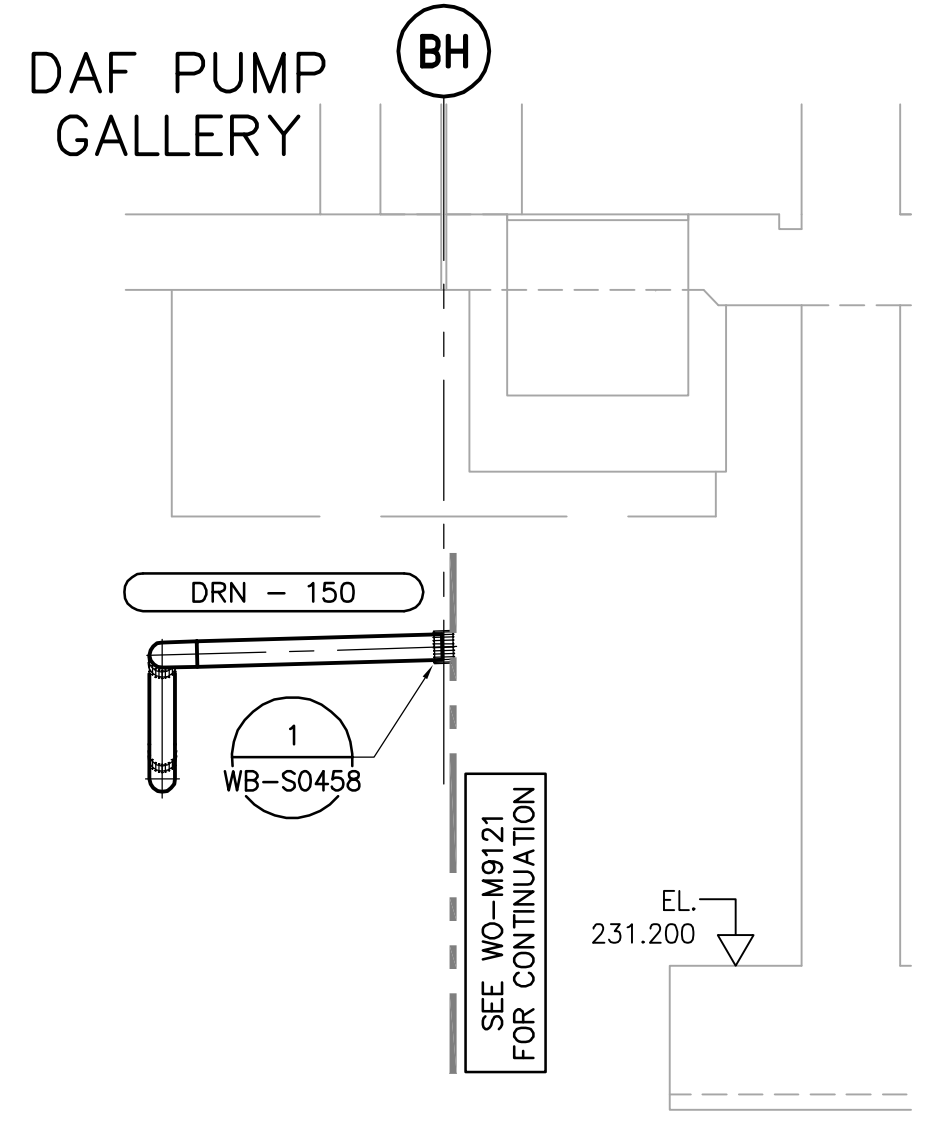


W SECTION - OZONE CONTACTOR DRAIN LINE
WP-M9108 1:50

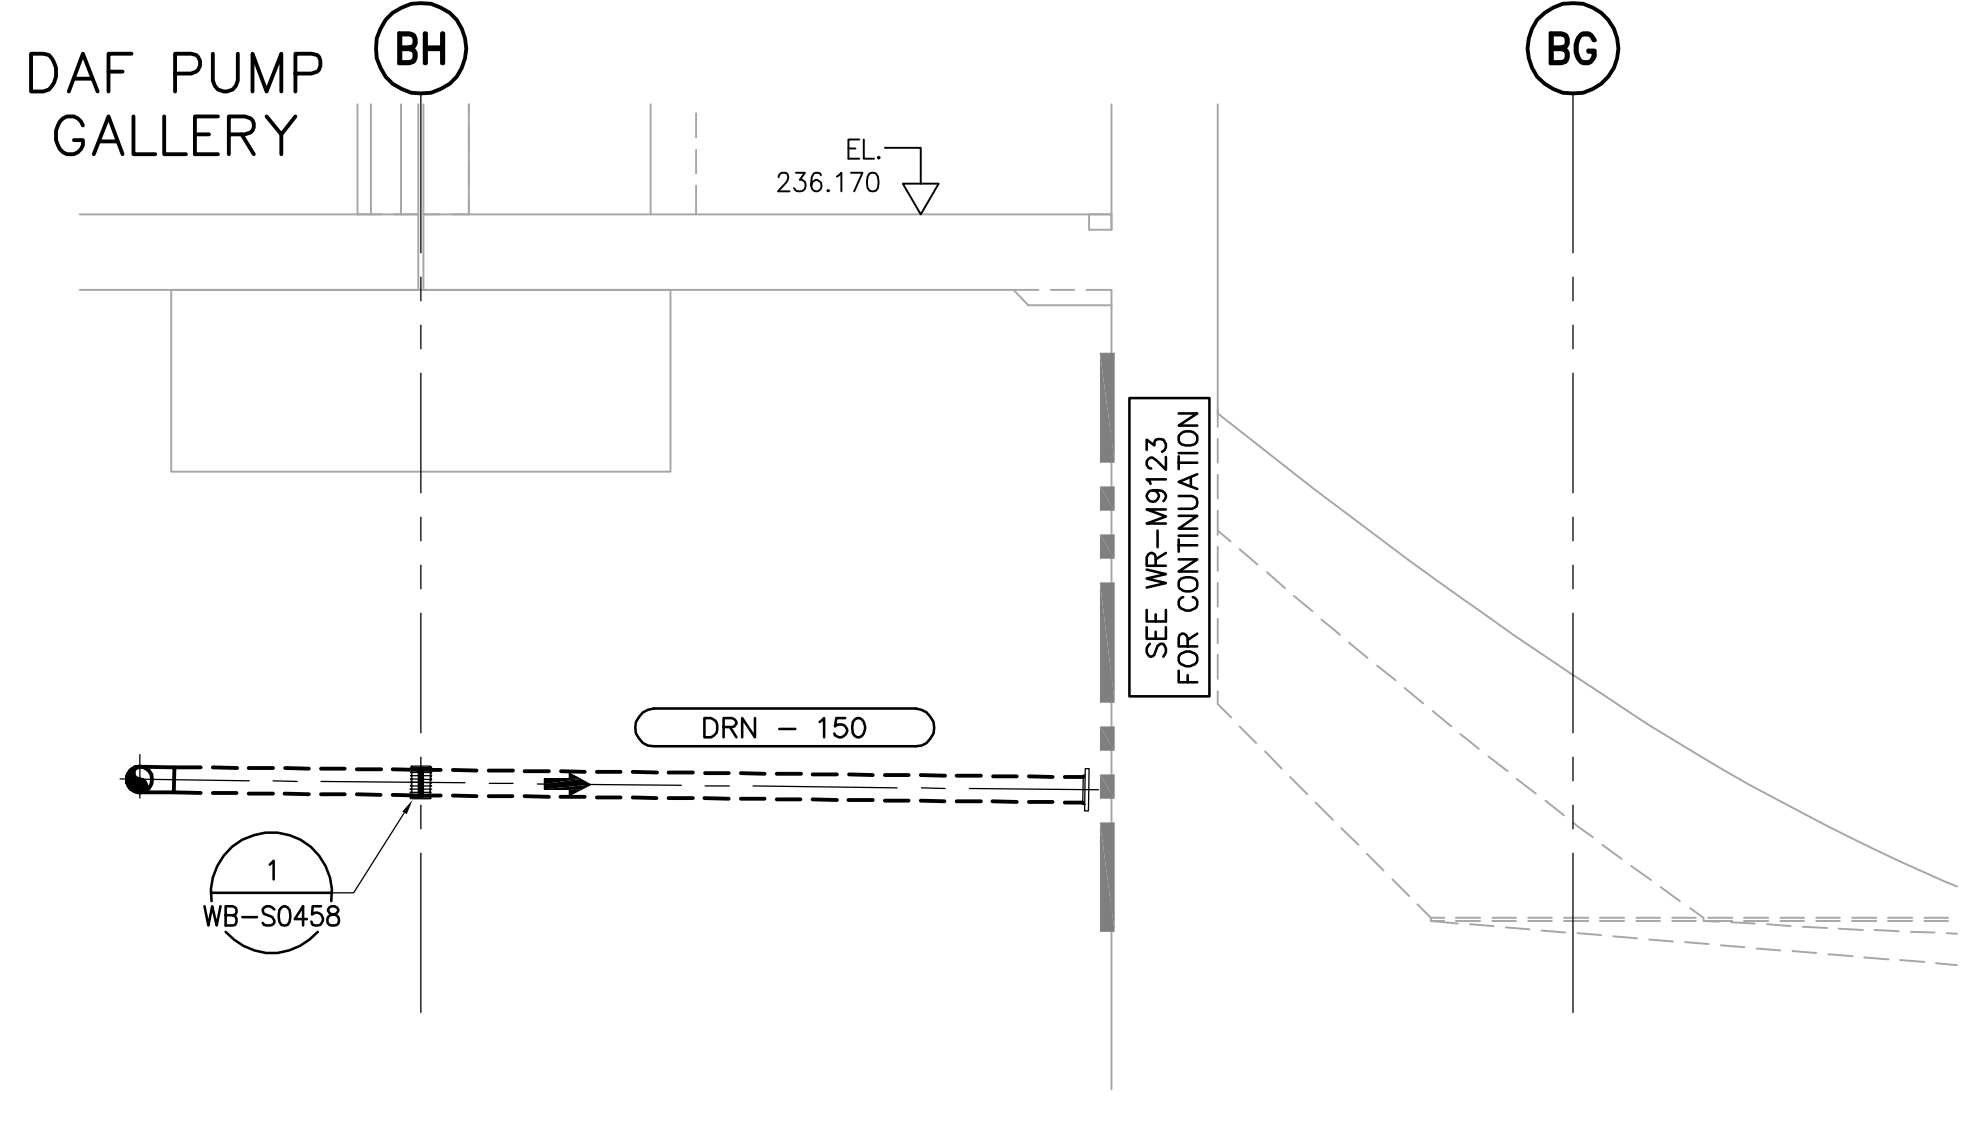

X SECTION - OZONE CONTACTOR DRAIN LINE
WP-M9108 1:50

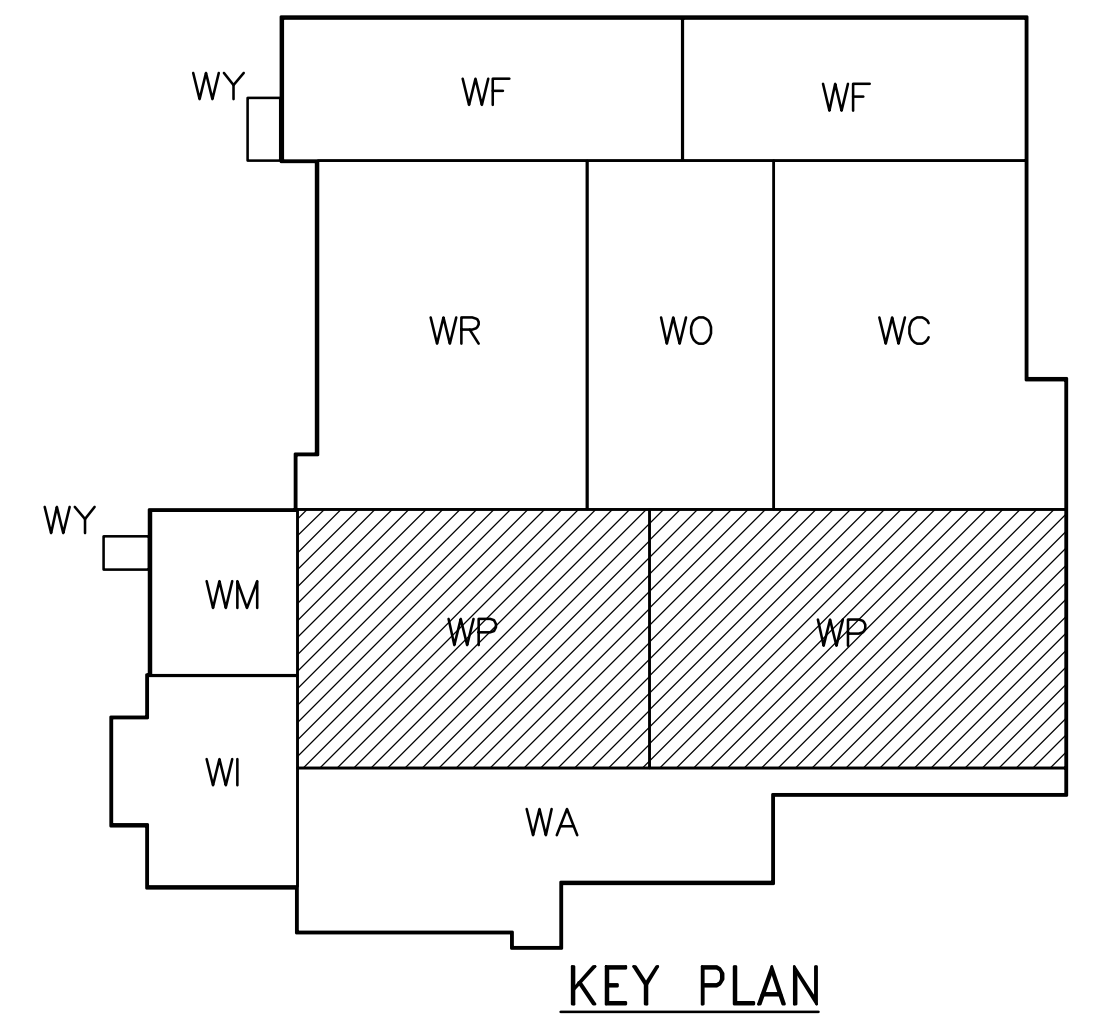

SCALE 1:50 METRES
SCALE 1:1 MILLIMETRES

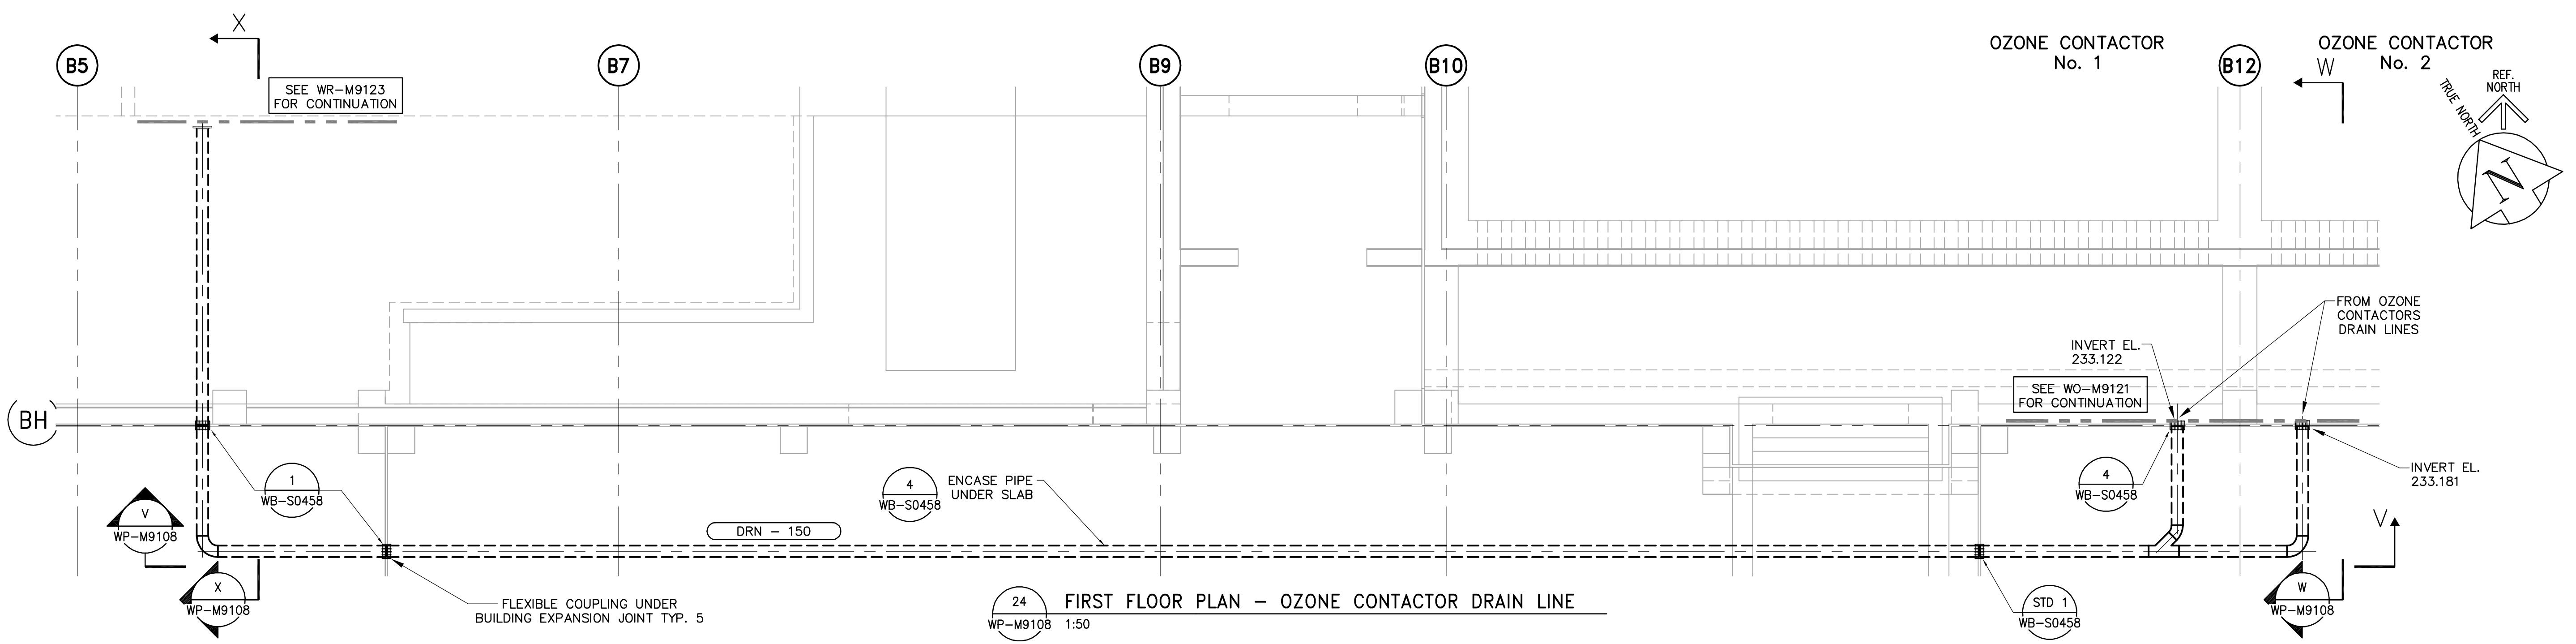

24 FIRST FLOOR PLAN - OZONE CONTACTOR DRAIN LINE
WP-M9108 1:50

 Certificate of Authorization Earth Tech Canada Inc. No. 730 Expiry: April 30, 2007	B.M. ELEV.	 Frederickson Cooper ARCHITECTS	 A Tech International Ltd. Company	ENGINEER'S SEAL	 THE CITY OF WINNIPEG WATER AND WASTE DEPARTMENT ENGINEERING DIVISION	WATER TREATMENT PLANT FLOCCULATION AND DAF FOUNDATIONS AND CONCRETE STRUCTURES	CITY FILE NUMBER
	DESIGNED BY KAS			CHECKED BY SRB			ORIGINAL SIGNED BY S.R. BILEVICIUS
	DRAWN BY PL/LC	APPROVED BY DJT	2006/02/07	CITY DRAWING NUMBER			
	SCALE: AS SHOWN	RELEASED FOR CONSTRUCTION BY: R. SOROKOWSKI	CONSULTANT DRAWING NO. WP-M9108	1-0601P-A-M9108-001-01D			
01 742-2005 ADDENDUM 3 06/05/05 LAE	06/02/03 PL	DATE 2005/10/24	DATE 2006/02/07				
00 ISSUED FOR TENDER							
NO. REVISIONS	DATE	BY					