
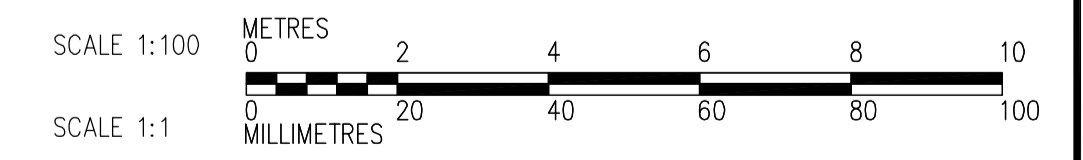


- NOTES:
- SEE MCC #2A & #2B SINGLE LINE DIAGRAM AND DP-P11 & DP-P12 POWER DISTRIBUTION FOR 600V POWER DISTRIBUTION.
 - ALL 120V AND 208V LOADS ARE FED FROM LP-P11
 - PROVIDE STAIRWELL SMOKE DETECTORS AS SHOWN ON FIRE PROTECTION DRAWINGS

FLOCCULATION TANK 1 FLOCCULATION TANK 2 FLOCCULATION TANK 3 FLOCCULATION TANK 4

FIRST FLOOR FACILITY PLAN (AREA 1)
1:100

ACCESS CORRIDOR No. 1
FL EL 236.170

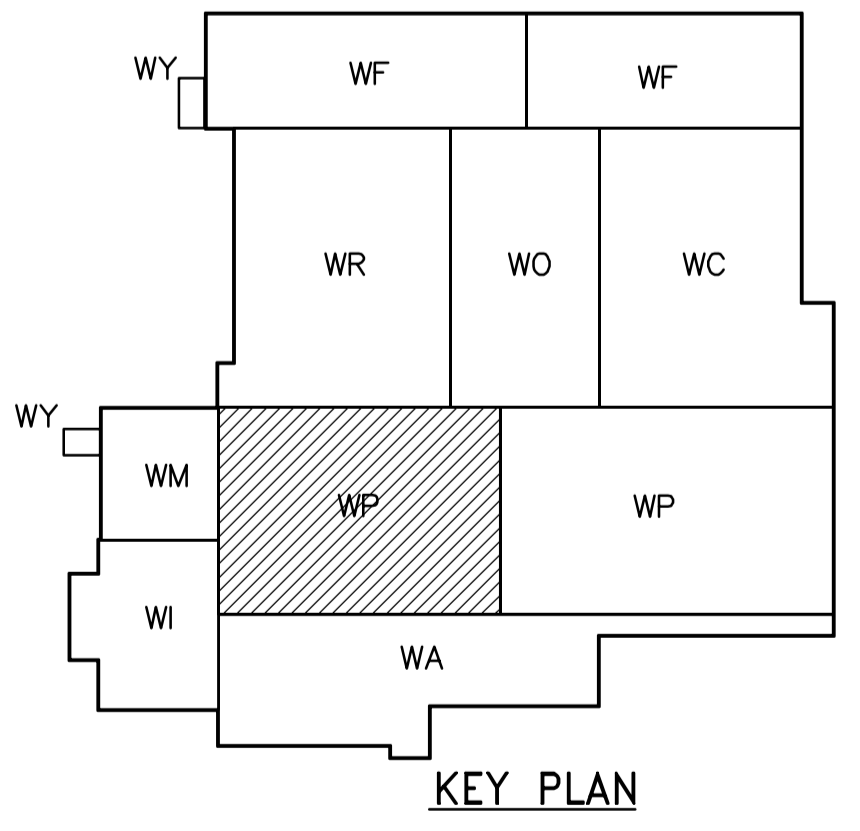

CABLE TRAY TAGGING
SEE DETAIL
01

3
WB-E0455

 Certificate of Authorization CH2M HILL Canada Ltd. No. 1441 Expiry: April 30, 2007	B.M. ELEV.	 Frederickson Cooper ARCHITECTS	 A You International Ltd. Company	ENGINEER'S SEAL ORIGINAL SIGNED BY L.D. LLEWELLYN 2006/03/29	 THE CITY OF WINNIPEG WATER AND WASTE DEPARTMENT ENGINEERING DIVISION WATER TREATMENT PLANT FLOCCULATION AND DAF MECHANICAL AND ELECTRICAL ELECTRICAL FLOC/DAF AREA 1 FIRST FLOOR FACILITY PLAN	CITY FILE NUMBER															
	<table border="1"> <tr> <td>02</td> <td>742-2005 ADDENDUM 4</td> <td>06/05/12</td> <td>LL</td> </tr> <tr> <td>01</td> <td>742-2005 ADDENDUM 3</td> <td>06/05/05</td> <td>LL</td> </tr> <tr> <td>00</td> <td>ISSUED FOR TENDER</td> <td>06/03/29</td> <td>LL</td> </tr> <tr> <td>NO.</td> <td>REVISIONS</td> <td>DATE</td> <td>BY</td> </tr> </table>	02	742-2005 ADDENDUM 4	06/05/12		LL	01	742-2005 ADDENDUM 3	06/05/05	LL	00	ISSUED FOR TENDER	06/03/29	LL	NO.	REVISIONS	DATE	BY	DESIGNED BY: JT CHECKED BY: ND DRAWN BY: KJ APPROVED BY: AHL SCALE: 1:100 RELEASED FOR CONSTRUCTION BY: R. SOROKOWSKI	CONSULTANT DRAWING NO. WP-E0111	SHEET OF
	02	742-2005 ADDENDUM 4	06/05/12	LL																	
	01	742-2005 ADDENDUM 3	06/05/05	LL																	
00	ISSUED FOR TENDER	06/03/29	LL																		
NO.	REVISIONS	DATE	BY																		
DATE: 2005/07/12 DATE: 2006/03/29	DATE: 2006/03/29	CITY DRAWING NUMBER 1-0601P-A-E0111-001-020																			