



- NOTES:**
1. SEE MCC 4A & 4B SINGLE LINE DIAGRAMS AND PANEL SCHEDULES DP-H31 AND DP-H32 FOR 600V POWER DISTRIBUTION
 2. SEE DRAWINGS WB-E0402 AND WB-E0403 FOR FLOCCULATION TANK EQUIPMENT WIRING DETAILS
 3. SEE DRAWINGS WB-E0402 AND WB-E0403 FOR CABLE TRAY MOUNTING DETAILS
 4. ALL 120V AND 208V LOADS ARE FED FROM LP-P31

FOR CABLE TRAY TAGGING SEE DETAIL 3
WB-E0455

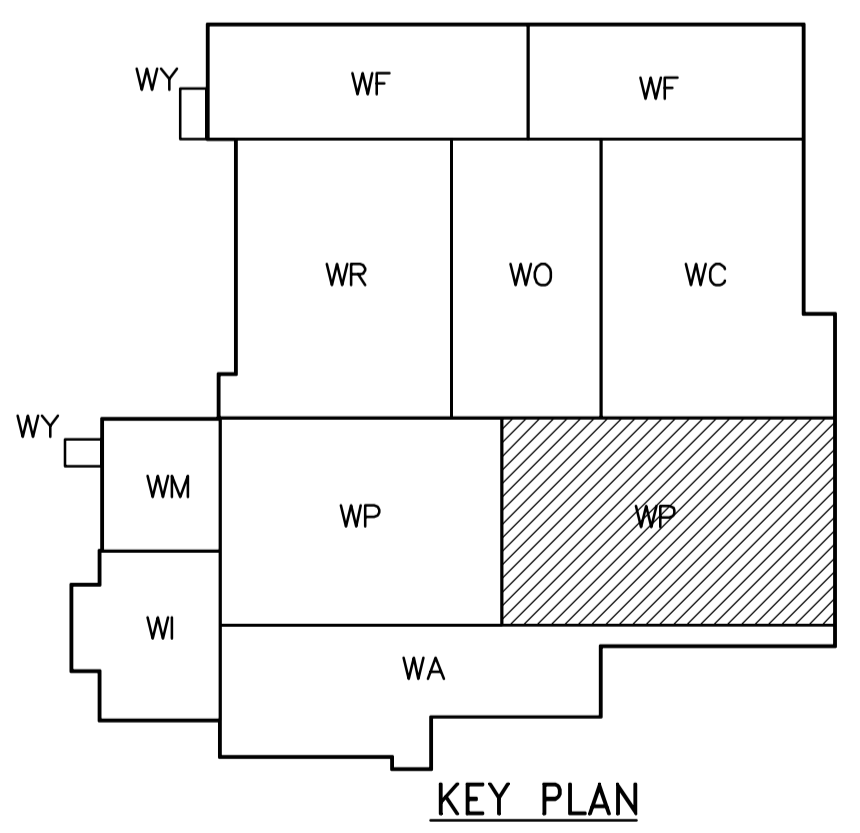

THIRD FLOOR FACILITY PLAN 2
1:100

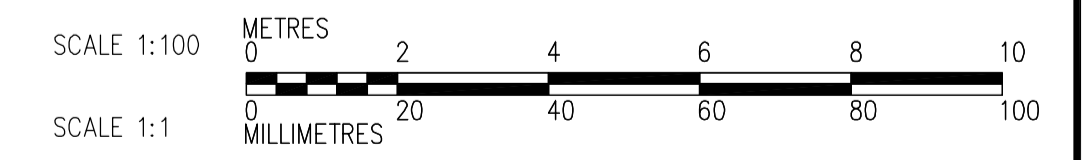

 APEGN Certificate of Authorization CH2M HILL Canada Ltd. No. 1441 Expiry: April 30, 2007	B.M. ELEV.	 Frederickson Cooper ARCHITECTS	 A You International Ltd. Company	ENGINEER'S SEAL ORIGINAL SIGNED BY L.D. LLEWELLYN 2006/03/29	 THE CITY OF WINNIPEG WATER AND WASTE DEPARTMENT ENGINEERING DIVISION WATER TREATMENT PLANT FLOCCULATION AND DAF MECHANICAL AND ELECTRICAL ELECTRICAL FLOC/DAF AREA 2 THIRD FLOOR FACILITY PLAN	CITY FILE NUMBER															
	<table border="1"> <tr> <th>NO.</th> <th>REVISIONS</th> <th>DATE</th> <th>BY</th> </tr> <tr> <td>02</td> <td>742-2005 ADDENDUM 4</td> <td>06/05/12</td> <td>LL</td> </tr> <tr> <td>01</td> <td>742-2005 ADDENDUM 3</td> <td>06/05/05</td> <td>LL</td> </tr> <tr> <td>00</td> <td>ISSUED FOR TENDER</td> <td>06/03/29</td> <td>LL</td> </tr> </table>	NO.	REVISIONS	DATE		BY	02	742-2005 ADDENDUM 4	06/05/12	LL	01	742-2005 ADDENDUM 3	06/05/05	LL	00	ISSUED FOR TENDER	06/03/29	LL	DESIGNED BY: LL CHECKED BY: ND DRAWN BY: TL APPROVED BY: AHL SCALE: 1:100 RELEASED FOR CONSTRUCTION BY: R. SOROKOWSKI DATE: 2005/07/12 DATE: 2006/03/29	CONSULTANT DRAWING NO. WP-E0132	SHEET OF
	NO.	REVISIONS	DATE	BY																	
	02	742-2005 ADDENDUM 4	06/05/12	LL																	
01	742-2005 ADDENDUM 3	06/05/05	LL																		
00	ISSUED FOR TENDER	06/03/29	LL																		
No. 1441 Expiry: April 30, 2007	DATE: 2005/07/12	DATE: 2006/03/29	CITY DRAWING NUMBER 1-0601P-A-E0132-001-020																		
Certificate of Authorization CH2M HILL Canada Ltd. No. 1441 Expiry: April 30, 2007	DATE: 2005/07/12	DATE: 2006/03/29	CITY DRAWING NUMBER 1-0601P-A-E0132-001-020																		