
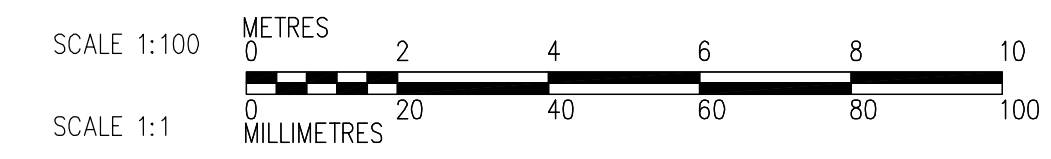


- NOTES:**
1. PROVIDE STAIRWELL SMOKE DETECTORS AS SHOWN ON FIRE PROTECTION DRAWINGS
 2. SEE PANEL SCHEDULES DP-R21 & DP-R22 FOR 600V POWER DISTRIBUTION
 3. CABLE TRAY TAGGING SEE DET. WB-E0455

SECOND FLOOR FACILITY PLAN
1:100

CABLE TRAY TAGGING
SEE DETAIL
3
WB-E0455

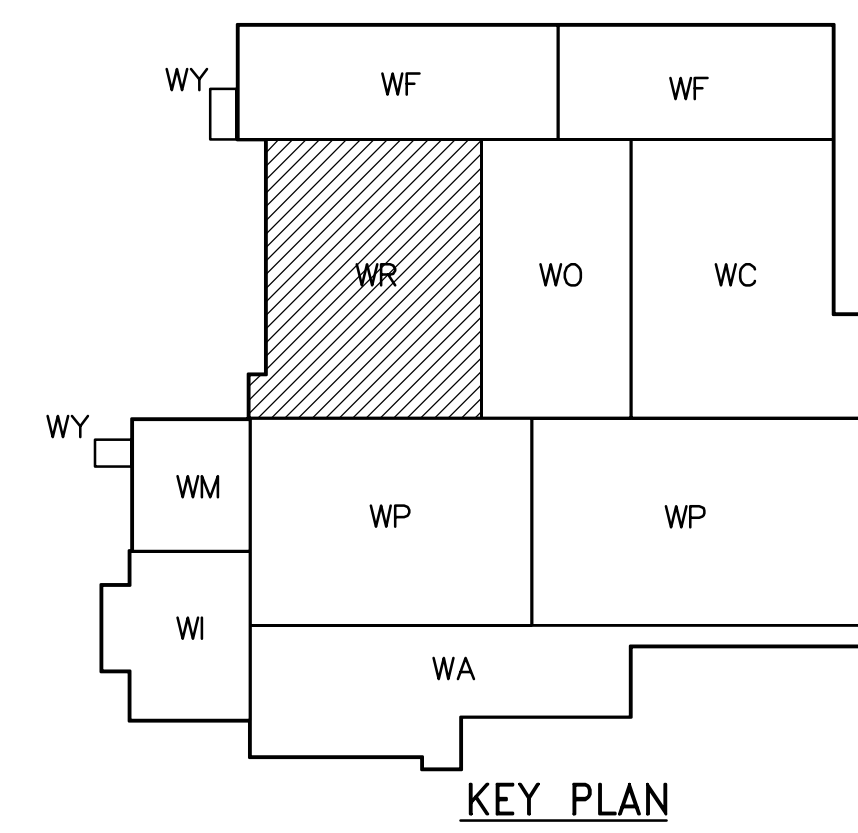

<p>APEGN Certificate of Authorization CH2M HILL Canada Ltd. No. 1441 Expiry: April 30, 2007</p>	<p>Frederickson Cooper ARCHITECTS</p>		<p>EarthTech A Tyco International Ltd. Company</p>		ENGINEER'S SEAL ORIGINAL SIGNED BY L.D. LLEWELLYN 2006/03/29	<p>THE CITY OF WINNIPEG WATER AND WASTE DEPARTMENT ENGINEERING DIVISION</p>
	DESIGNED BY LL CHECKED BY ND		DRAWN BY TL APPROVED BY AHL		CONSULTANT DRAWING NO. WR-E0121	
	SCALE: 1:100		RELEASED FOR CONSTRUCTION BY: R. SOROKOWSKI			
	NO. REVISIONS DATE BY		DATE 2005/07/12 DATE 2006/03/29		WATER TREATMENT PLANT RESIDUALS HANDLING MECHANICAL AND ELECTRICAL ELECTRICAL RESIDUALS HANDLING AREA SECOND FLOOR FACILITY PLAN	