



PARTIAL SECOND FLOOR PLAN
1:100

THIRD FLOOR PLAN
1:100

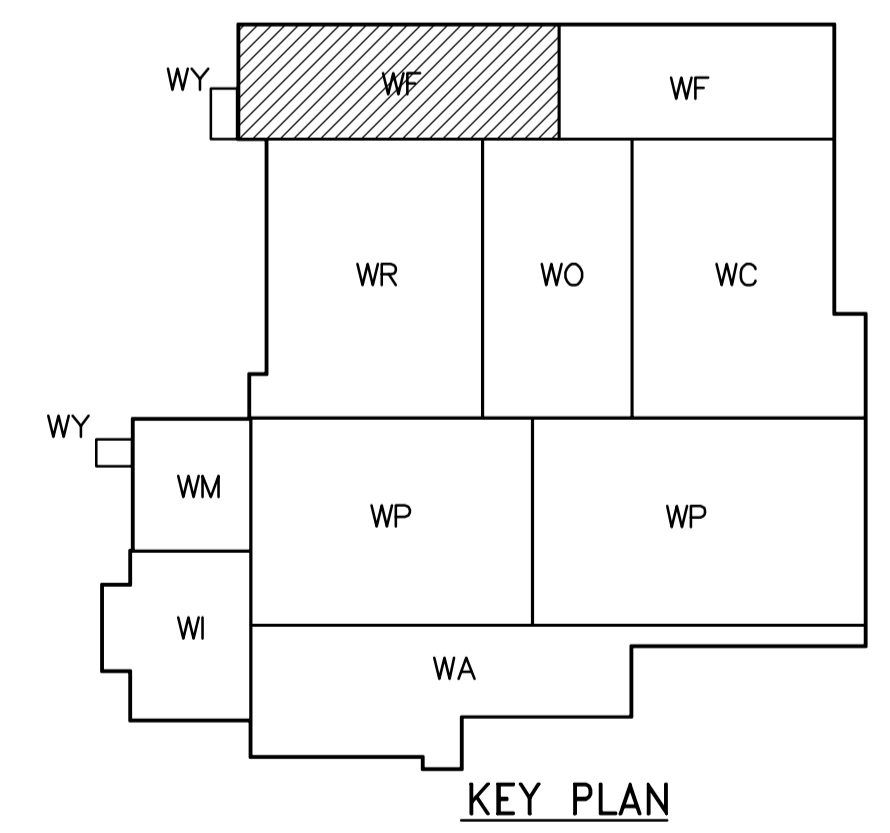

KEY PLAN

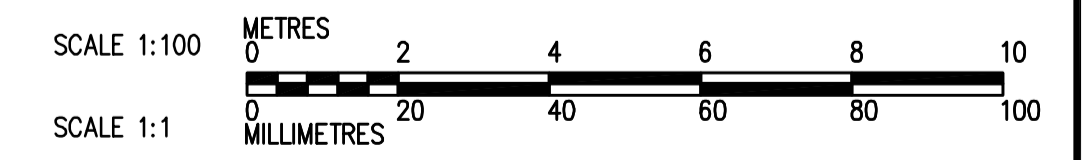

<p>APEGN Certificate of Authorization CH2M HILL Canada Ltd. No. 1441 Expiry: April 30, 2007</p>	<p>Frederickson Cooper ARCHITECTS</p>		<p>EarthTech A Tyco International Ltd. Company</p>		ENGINEER'S SEAL ORIGINAL SIGNED BY D.K. CUDDINGTON 2006/03/29	<p>THE CITY OF WINNIPEG WATER AND WASTE DEPARTMENT ENGINEERING DIVISION</p>	
	DESIGNED BY JZ/SW CHECKED BY DL		APPROVED BY AHL		CONSULTANT DRAWING NO. WF-H0133		
	DRAWN BY JMcP		RELEASED FOR CONSTRUCTION BY: R. SOROKOWSKI				
	SCALE: 1:100		DATE 2005/08/02		DATE 2006/03/29		
B.M. ELEV.		NO. REVISIONS		DATE BY		WATER TREATMENT PLANT FILTRATION MECHANICAL AND ELECTRICAL	CITY FILE NUMBER SHEET OF
01 742-2005 ADDENDUM 5 06/05/19 SW 00 ISSUED FOR TENDER 06/03/29 SW		DATE BY		DATE 2005/08/02 DATE 2006/03/29		PLUMBING FILTRATION AREA 1 PARTIAL SECOND FLOOR AND THIRD FLOOR PLAN	CITY DRAWING NUMBER 1-0601F-A-H0133-001-01D