
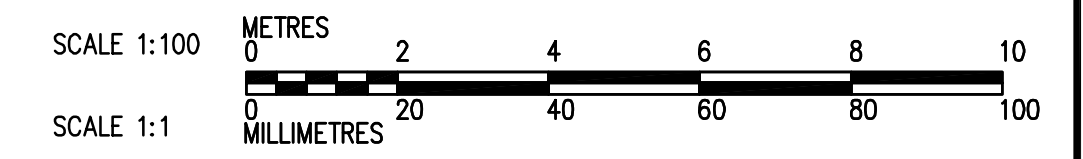


THIRD FLOOR PLAN
1:100

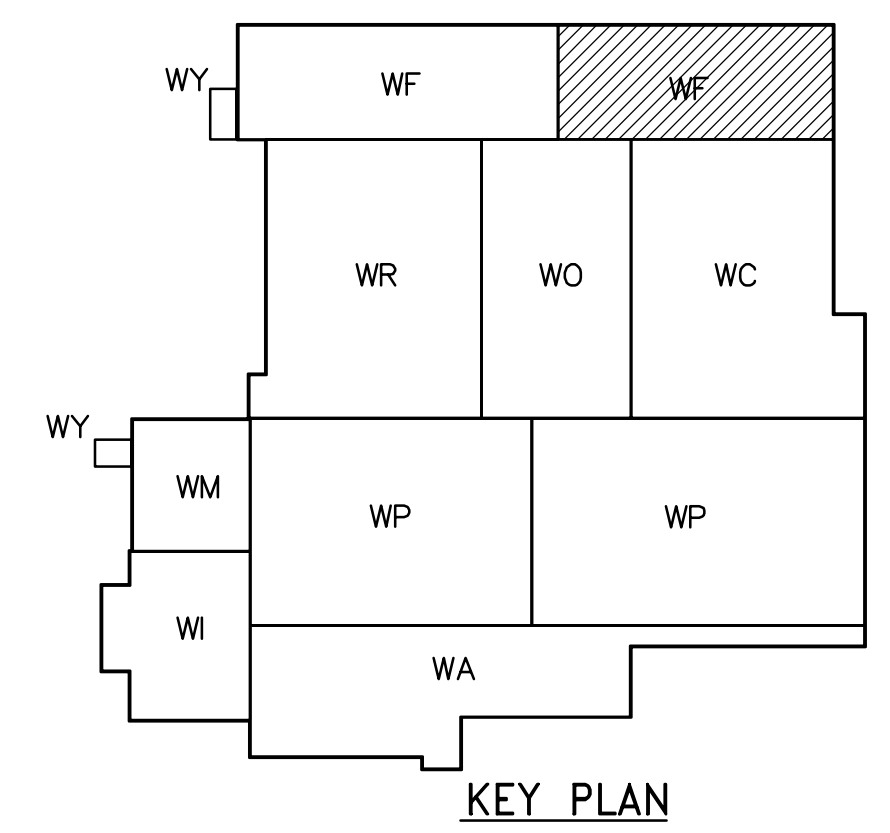

<p>APEGN Certificate of Authorization CH2M HILL Canada Ltd. No. 1441 Expiry: April 30, 2007</p>	<p>Frederickson Cooper ARCHITECTS</p>		<p>A You International Ltd. Company</p>		ENGINEER'S SEAL ORIGINAL SIGNED BY D.K. CUDDINGTON 2006/03/29	<p>THE CITY OF WINNIPEG WATER AND WASTE DEPARTMENT ENGINEERING DIVISION</p>
	DESIGNED BY: JZ/SW CHECKED BY: DL		DRAWN BY: JMcP APPROVED BY: AHL		WATER TREATMENT PLANT FILTRATION MECHANICAL AND ELECTRICAL	
	SCALE: 1:100		RELEASED FOR CONSTRUCTION BY: R. SOROKOWSKI			
	NO. REVISIONS: 01 742-2005 ADDENDUM 5 06/05/19 SW 00 ISSUED FOR TENDER 06/03/29 SW		DATE: 2005/08/02 DATE: 2006/03/29		CONSULTANT DRAWING NO. WF-H0134	