
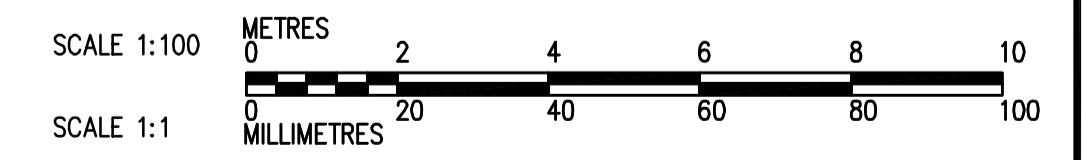


ROOF PLAN
1:100

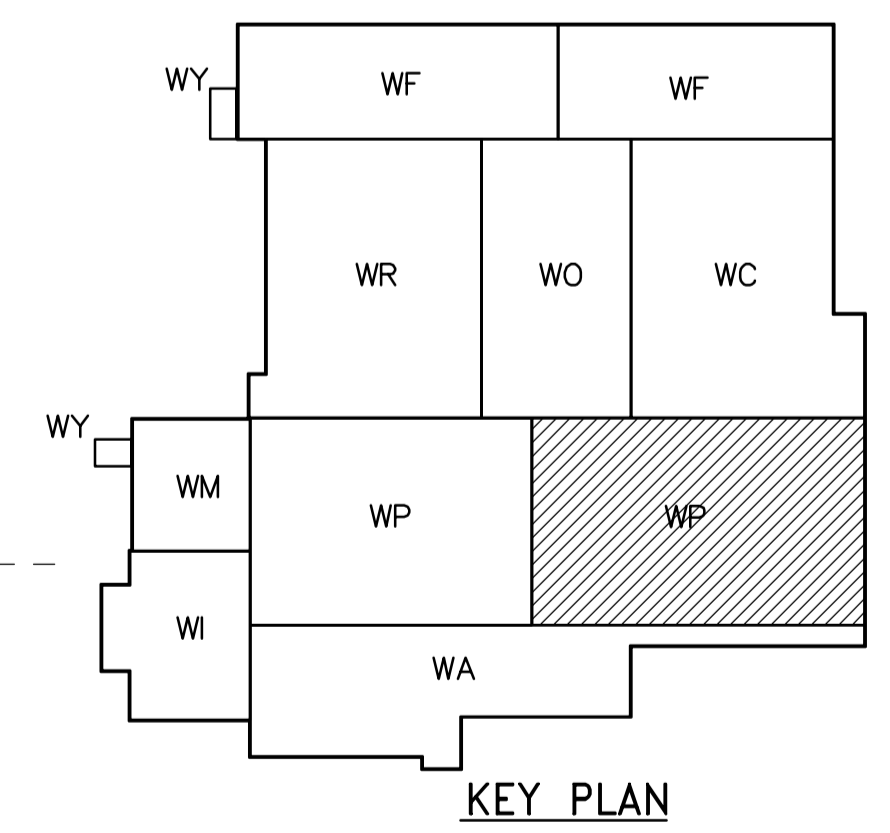

<p>Certificate of Authorization CH2M HILL Canada Ltd. No. 1441 Expiry: April 30, 2007</p>	<p>Frederickson Cooper ARCHITECTS</p>		<p>A Tetra International Ltd. Company</p>		<p>ENGINEER'S SEAL</p> <p>ORIGINAL SIGNED BY D.K. CUDDINGTON 2006/03/29</p>		<p>THE CITY OF WINNIPEG WATER AND WASTE DEPARTMENT ENGINEERING DIVISION</p>	
	<p>DESIGNED BY JZ/SW</p> <p>DRAWN BY JMcP</p>		<p>CHECKED BY DL</p> <p>APPROVED BY AHL</p>		<p>CONSULTANT DRAWING NO. WP-H0144</p>		<p>WATER TREATMENT PLANT FLOCCULATION AND DAF MECHANICAL AND ELECTRICAL</p>	
	<p>SCALE: 1:100</p>		<p>RELEASED FOR CONSTRUCTION BY: R. SOROKOWSKI</p>		<p>PLUMBING FLOC/DAF AREA 2 ROOF PLAN</p>		<p>CITY FILE NUMBER</p> <p>SHEET OF</p> <p>CITY DRAWING NUMBER 1-0601P-A-H0144-001-01D</p>	
	<p>NO. REVISIONS</p>		<p>DATE BY</p>		<p>DATE 2005/07/15</p> <p>DATE 2006/03/29</p>			