


NOTES:  
1. SEE PANEL SCHEDULES DP-R21 & DP-R22 FOR 600V POWER DISTRIBUTION

SECOND FLOOR PROCESS PLAN  
1:100

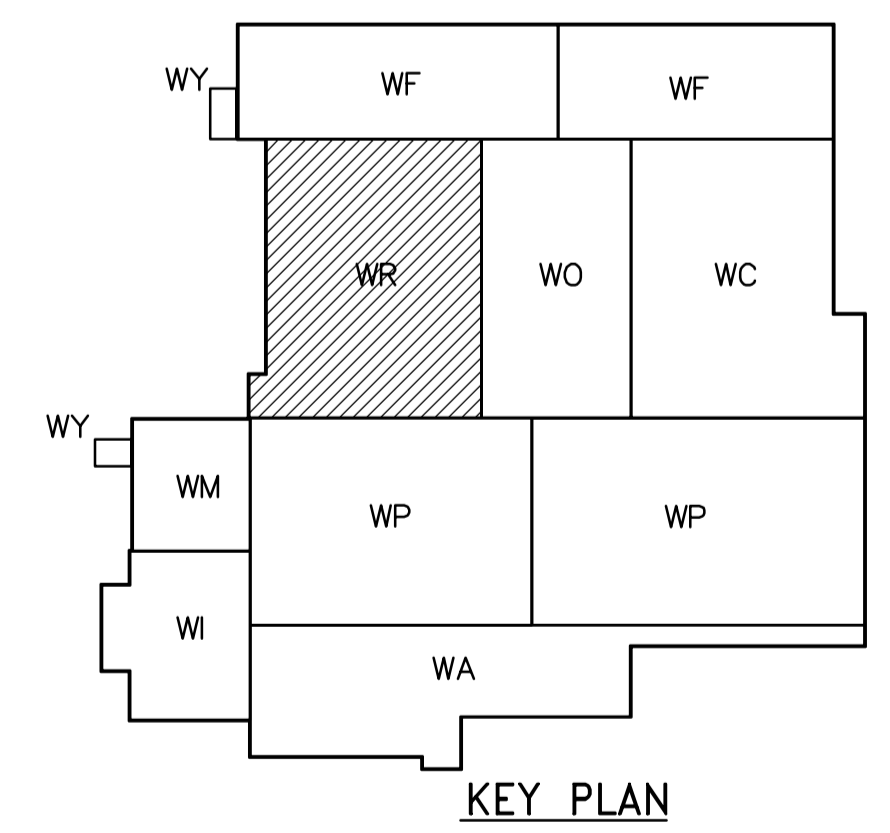

<p><b>APEGN</b> Certificate of Authorization CH2M HILL Canada Ltd. No. 1441 Expiry: April 30, 2007</p>	<table border="1"> <tr> <th>NO.</th> <th>REVISIONS</th> <th>DATE</th> <th>BY</th> </tr> <tr> <td>02</td> <td>742-2005 ADDENDUM 5</td> <td>06/05/19</td> <td>LL</td> </tr> <tr> <td>01</td> <td>742-2005 ADDENDUM 3</td> <td>06/05/05</td> <td>LL</td> </tr> <tr> <td>00</td> <td>ISSUED FOR TENDER</td> <td>06/03/29</td> <td>LL</td> </tr> </table>	NO.	REVISIONS	DATE	BY	02	742-2005 ADDENDUM 5	06/05/19	LL	01	742-2005 ADDENDUM 3	06/05/05	LL	00	ISSUED FOR TENDER	06/03/29	LL	<p>Frederickson Cooper ARCHITECTS</p>	<p>EarthTech A Tyco International Ltd. Company</p>	ENGINEER'S SEAL  ORIGINAL SIGNED BY L.D. LLEWELLYN 2006/03/29	<p><b>THE CITY OF WINNIPEG</b> WATER AND WASTE DEPARTMENT ENGINEERING DIVISION</p>
		NO.	REVISIONS	DATE	BY																
02	742-2005 ADDENDUM 5	06/05/19	LL																		
01	742-2005 ADDENDUM 3	06/05/05	LL																		
00	ISSUED FOR TENDER	06/03/29	LL																		
DESIGNED BY: LL CHECKED BY: ND DRAWN BY: TL APPROVED BY: AHL SCALE: 1:100 RELEASED FOR CONSTRUCTION BY: R. SOROKOWSKI DATE: 2006/01/21	CONSULTANT DRAWING NO. WR-E0122	WATER TREATMENT PLANT RESIDUALS HANDLING MECHANICAL AND ELECTRICAL ELECTRICAL RESIDUALS HANDLING AREA SECOND FLOOR PROCESS PLAN	CITY FILE NUMBER SHEET OF CITY DRAWING NUMBER 1-0601R-A-E0122-001-020																		