

EC-H002  
INCOMING GAS MAIN REFER TO YARD PIPING DRAWINGS FOR DETAIL

GAS PRESSURE REGULATOR STATION. 70 kPa BY MANITOBA HYDRO



NG-65  
UP TO ROOF ALONG OUTSIDE WALL SEE DWG. WB-H0145 FOR CONTINUATION

PROVIDE GAS PRESSURE REGULATOR 1.7 TO 3.5 kPa (377 kW CONNECTED INPUT CAPACITY) AS PER MANITOBA GAS NOTICE

NG-80  
UP TO ROOF ALONG OUTSIDE WALL SEE DWG. WB-H0145 FOR CONTINUATION

STAIRWELL NO. 6  
CHLORINE CONTACT TANK ACCESS PLATFORM

FIRST FLOOR PLAN  
1:100

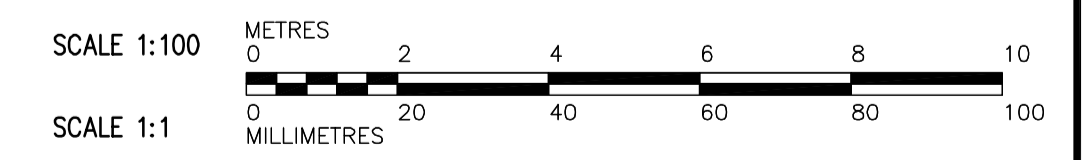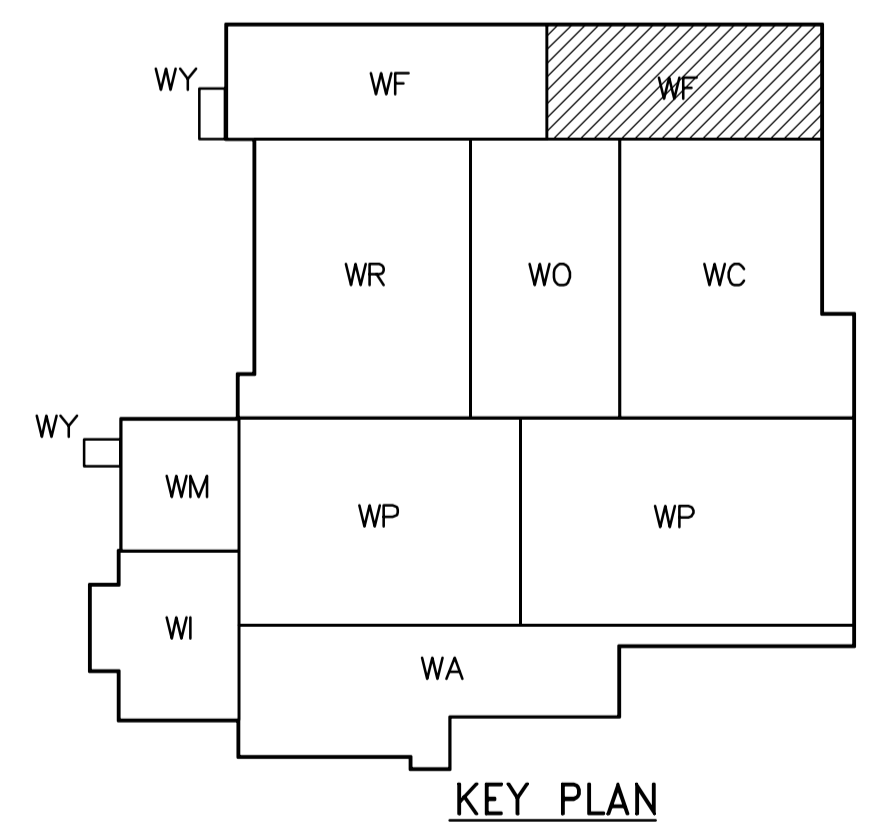

<p><b>APEGN</b> Certificate of Authorization CH2M HILL Canada Ltd. No. 1441 Expiry: April 30, 2007</p>	<p>Frederickson Cooper ARCHITECTS</p>	<p>EarthTech A Tyco International Ltd. Company</p>	ENGINEER'S SEAL	<p><b>THE CITY OF WINNIPEG</b> WATER AND WASTE DEPARTMENT ENGINEERING DIVISION</p>		
			DESIGNED BY TT		CHECKED BY DL	ORIGINAL SIGNED BY D.K. CUDDINGTON 2006/03/29
			DRAWN BY AM		APPROVED BY AHL	
			SCALE: 1:100		RELEASED FOR CONSTRUCTION BY: R. SOROKOWSKI	CONSULTANT DRAWING NO. WF-H0112
B.M. ELEV. 01 742-2005 ADDENDUM 6 06/05/26 TT 00 ISSUED FOR TENDER 06/03/29 TT NO. REVISIONS DATE BY DATE 2005/07/08 DATE 2006/03/29	WATER TREATMENT PLANT FILTRATION MECHANICAL AND ELECTRICAL		CITY FILE NUMBER SHEET OF CITY DRAWING NUMBER 1-0601F-A-H0112-001-01D			