



- NOTES:**
1. ALL 120V AND 208V LOADS ARE FED FROM LP-A11.
  2. EMERGENCY LIGHTING EM-X-1, -2 ETC ARE FED FROM BATTERY PACK EM-X.
  3. MOUNT TYPE A AND U LUMINAIRES AT 3m ABOVE FINISHED FLOOR.

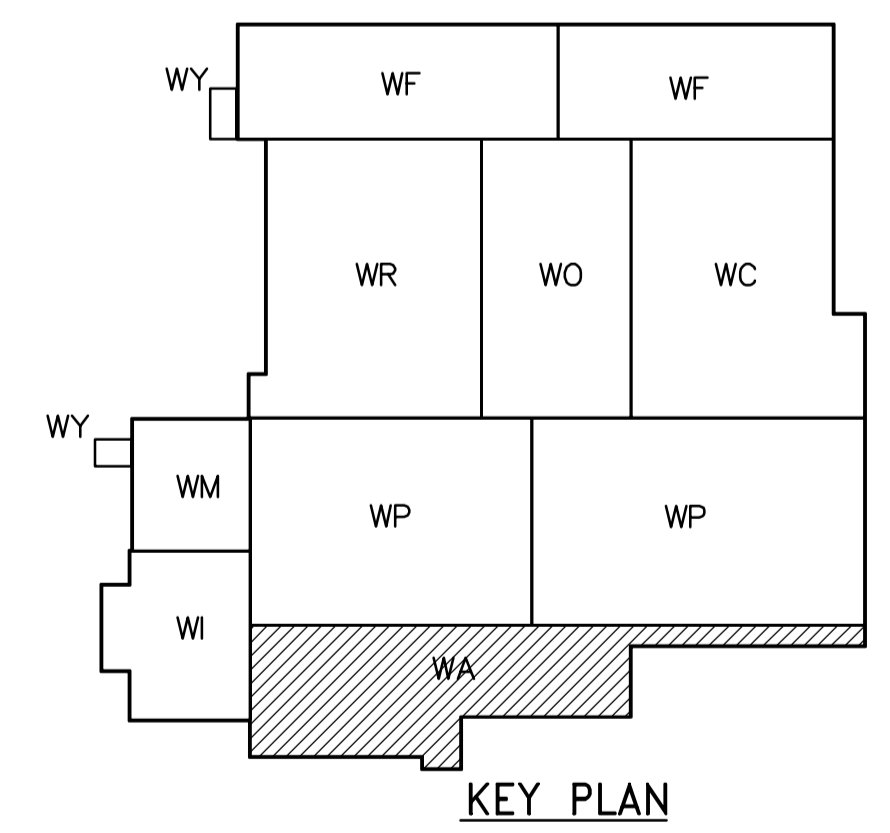

**FIRST FLOOR POWER AND LIGHTING PLAN**  
1:100

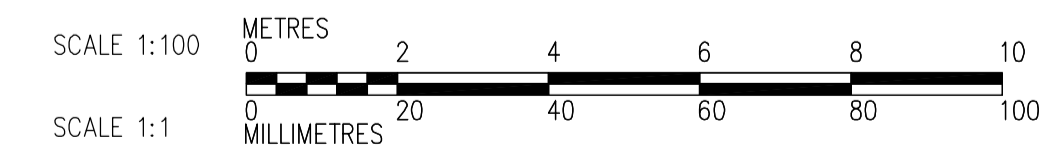

 Certificate of Authorization CH2M HILL Canada Ltd. No. 1441 Expiry: April 30, 2006	B.M. ELEV.	 Frederickson Cooper ARCHITECTS	 A Tyco International Ltd. Company	ENGINEER'S SEAL	 <b>THE CITY OF WINNIPEG</b> WATER AND WASTE DEPARTMENT ENGINEERING DIVISION	
	DESIGNED BY JT			CHECKED BY ND		ORIGINAL SIGNED BY L.D. LLEWELLYN
	DRAWN BY KJ			APPROVED BY AHL		2006/03/29
	SCALE: 1:100			RELEASED FOR CONSTRUCTION BY: R. SOROKOWSKI		CONSULTANT DRAWING NO. WA-E0113
00 ISSUED FOR TENDER 06/03/29 LL	NO. REVISIONS	DATE BY	DATE 2005/08/18	DATE 2006/03/29	WATER TREATMENT PLANT ADMINISTRATION MECHANICAL AND ELECTRICAL ELECTRICAL ADMINISTRATION AREA FIRST FLOOR POWER AND LIGHTING PLAN	
					CITY FILE NUMBER SHEET OF CITY DRAWING NUMBER 1-0601A-A-E0113-001-000	