

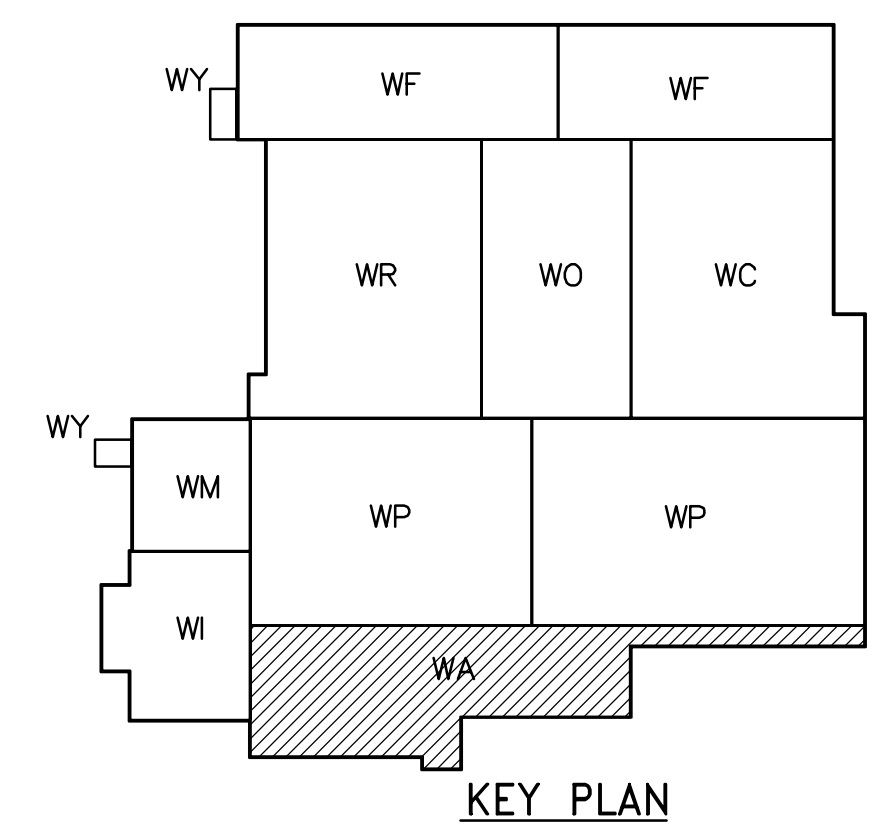


NOTES
 1. ALL 120V AND 208V LOADS 27a* ARE FED FROM LP-A11

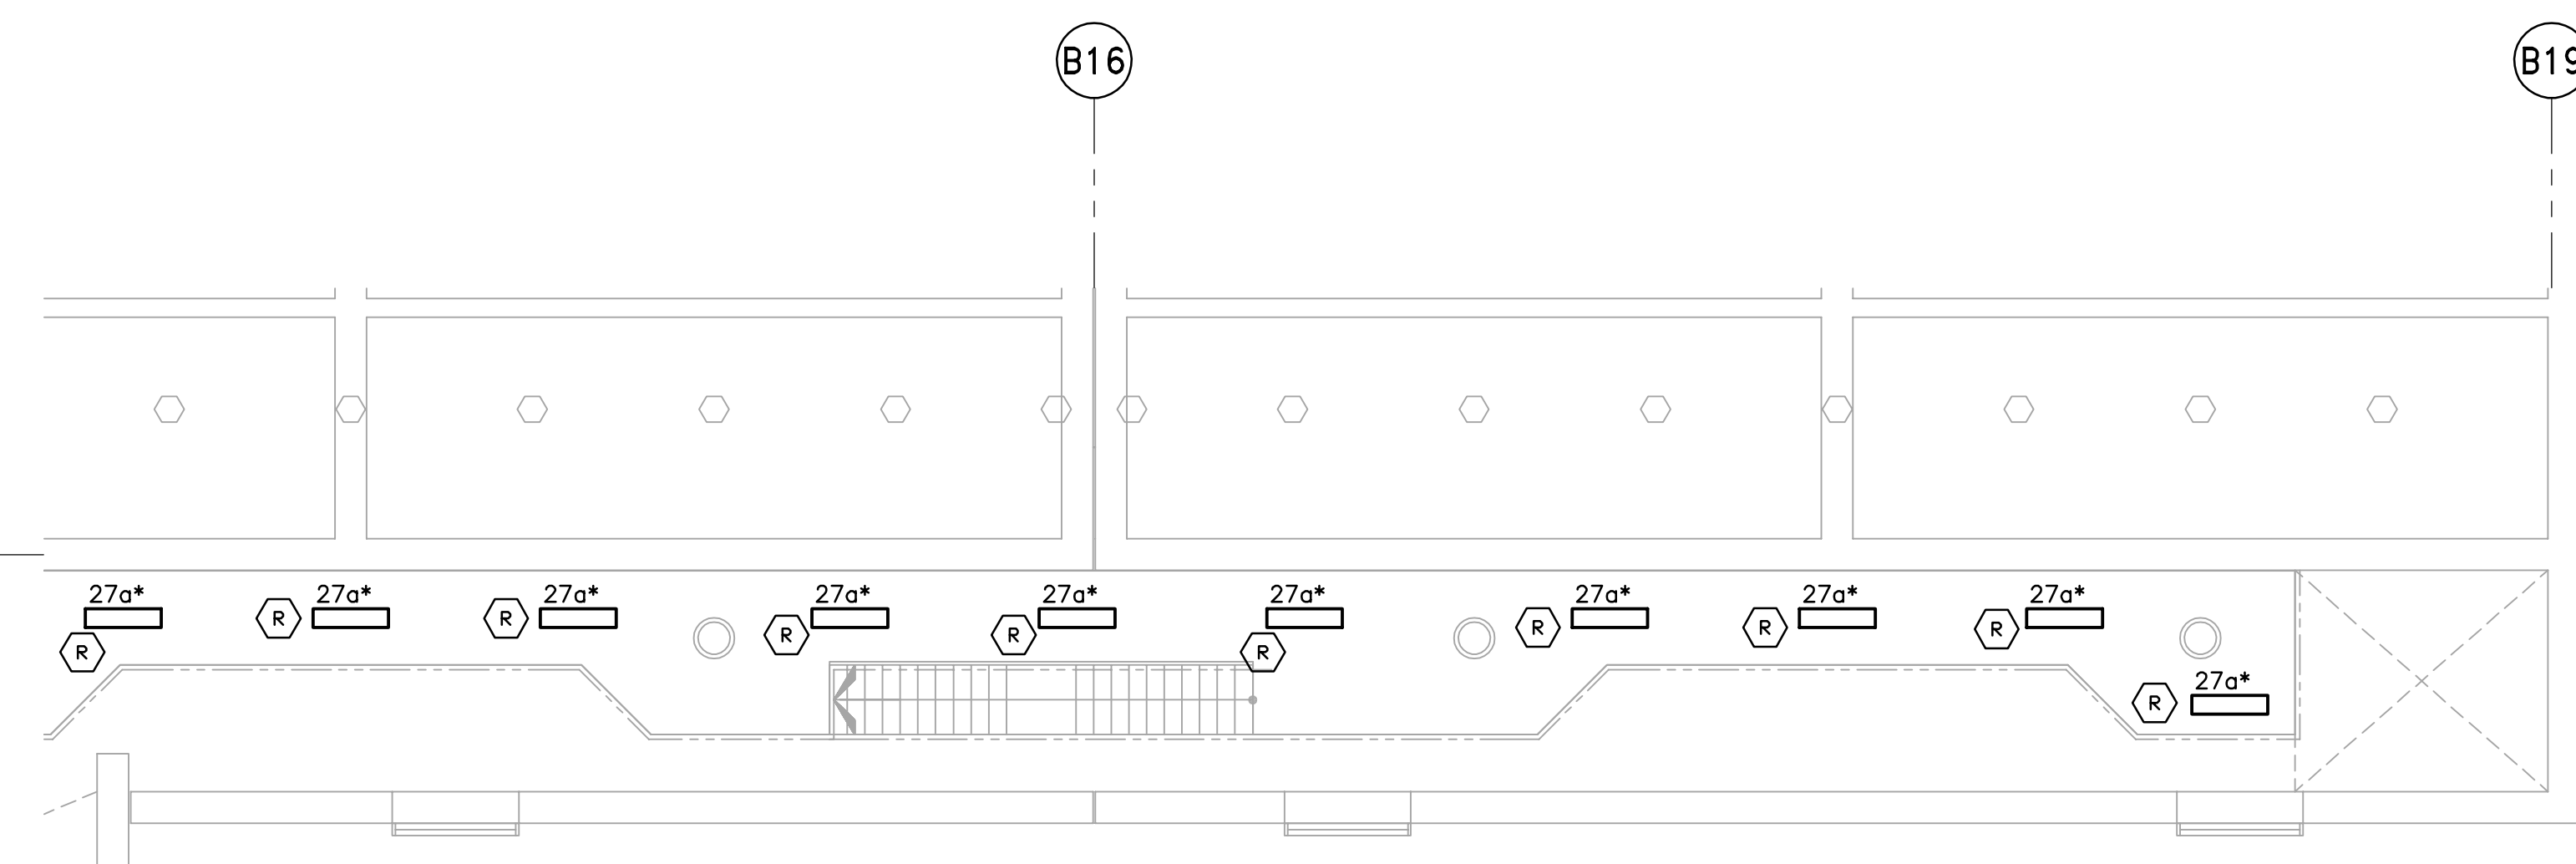

SECOND FLOOR POWER AND LIGHTING PLAN
 1:100

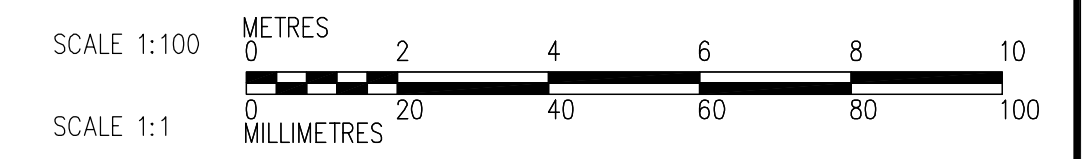

| | | | | | | |
|--------------------------------------------------------------------------------------------------------------|----------------------------------|---------------------------------------|---------------------------------------------|---------------------------------------------------------------------------|---------------------------------------------------------------------------------------|--------------------------------------------------------------------------------|
| APEGN Certificate of Authorization CH2M HILL Canada Ltd. No. 1441 Expiry: April 30, 2006 | B.M. ELEV. | Frederickson Cooper ARCHITECTS | A Terra International Ltd. Company | ENGINEER'S SEAL | THE CITY OF WINNIPEG WATER AND WASTE DEPARTMENT ENGINEERING DIVISION | |
| | | | | DESIGNED BY PF | | CHECKED BY ND |
| | | DRAWN BY TL | APPROVED BY AHL | 2006/03/29 | | WATER TREATMENT PLANT ADMINISTRATION AREA MECHANICAL AND ELECTRICAL |
| | | SCALE: 1:100 | RELEASED FOR CONSTRUCTION BY: R. SOROKOWSKI | CONSULTANT DRAWING NO. WA-E0123 | | CITY FILE NUMBER SHEET OF CITY DRAWING NUMBER 1-0601A-A-E0123-001-000 |
| | 00 ISSUED FOR TENDER 06/03/26 LL | DATE 2006/02/07 | DATE 2006/03/29 | ELECTRICAL ADMINISTRATION AREA SECOND FLOOR POWER AND LIGHTING PLAN | | |