



NOTES  
1. ALL 120V AND 208V LOADS ARE FED FROM LP-A21

ADMINISTRATION AREA

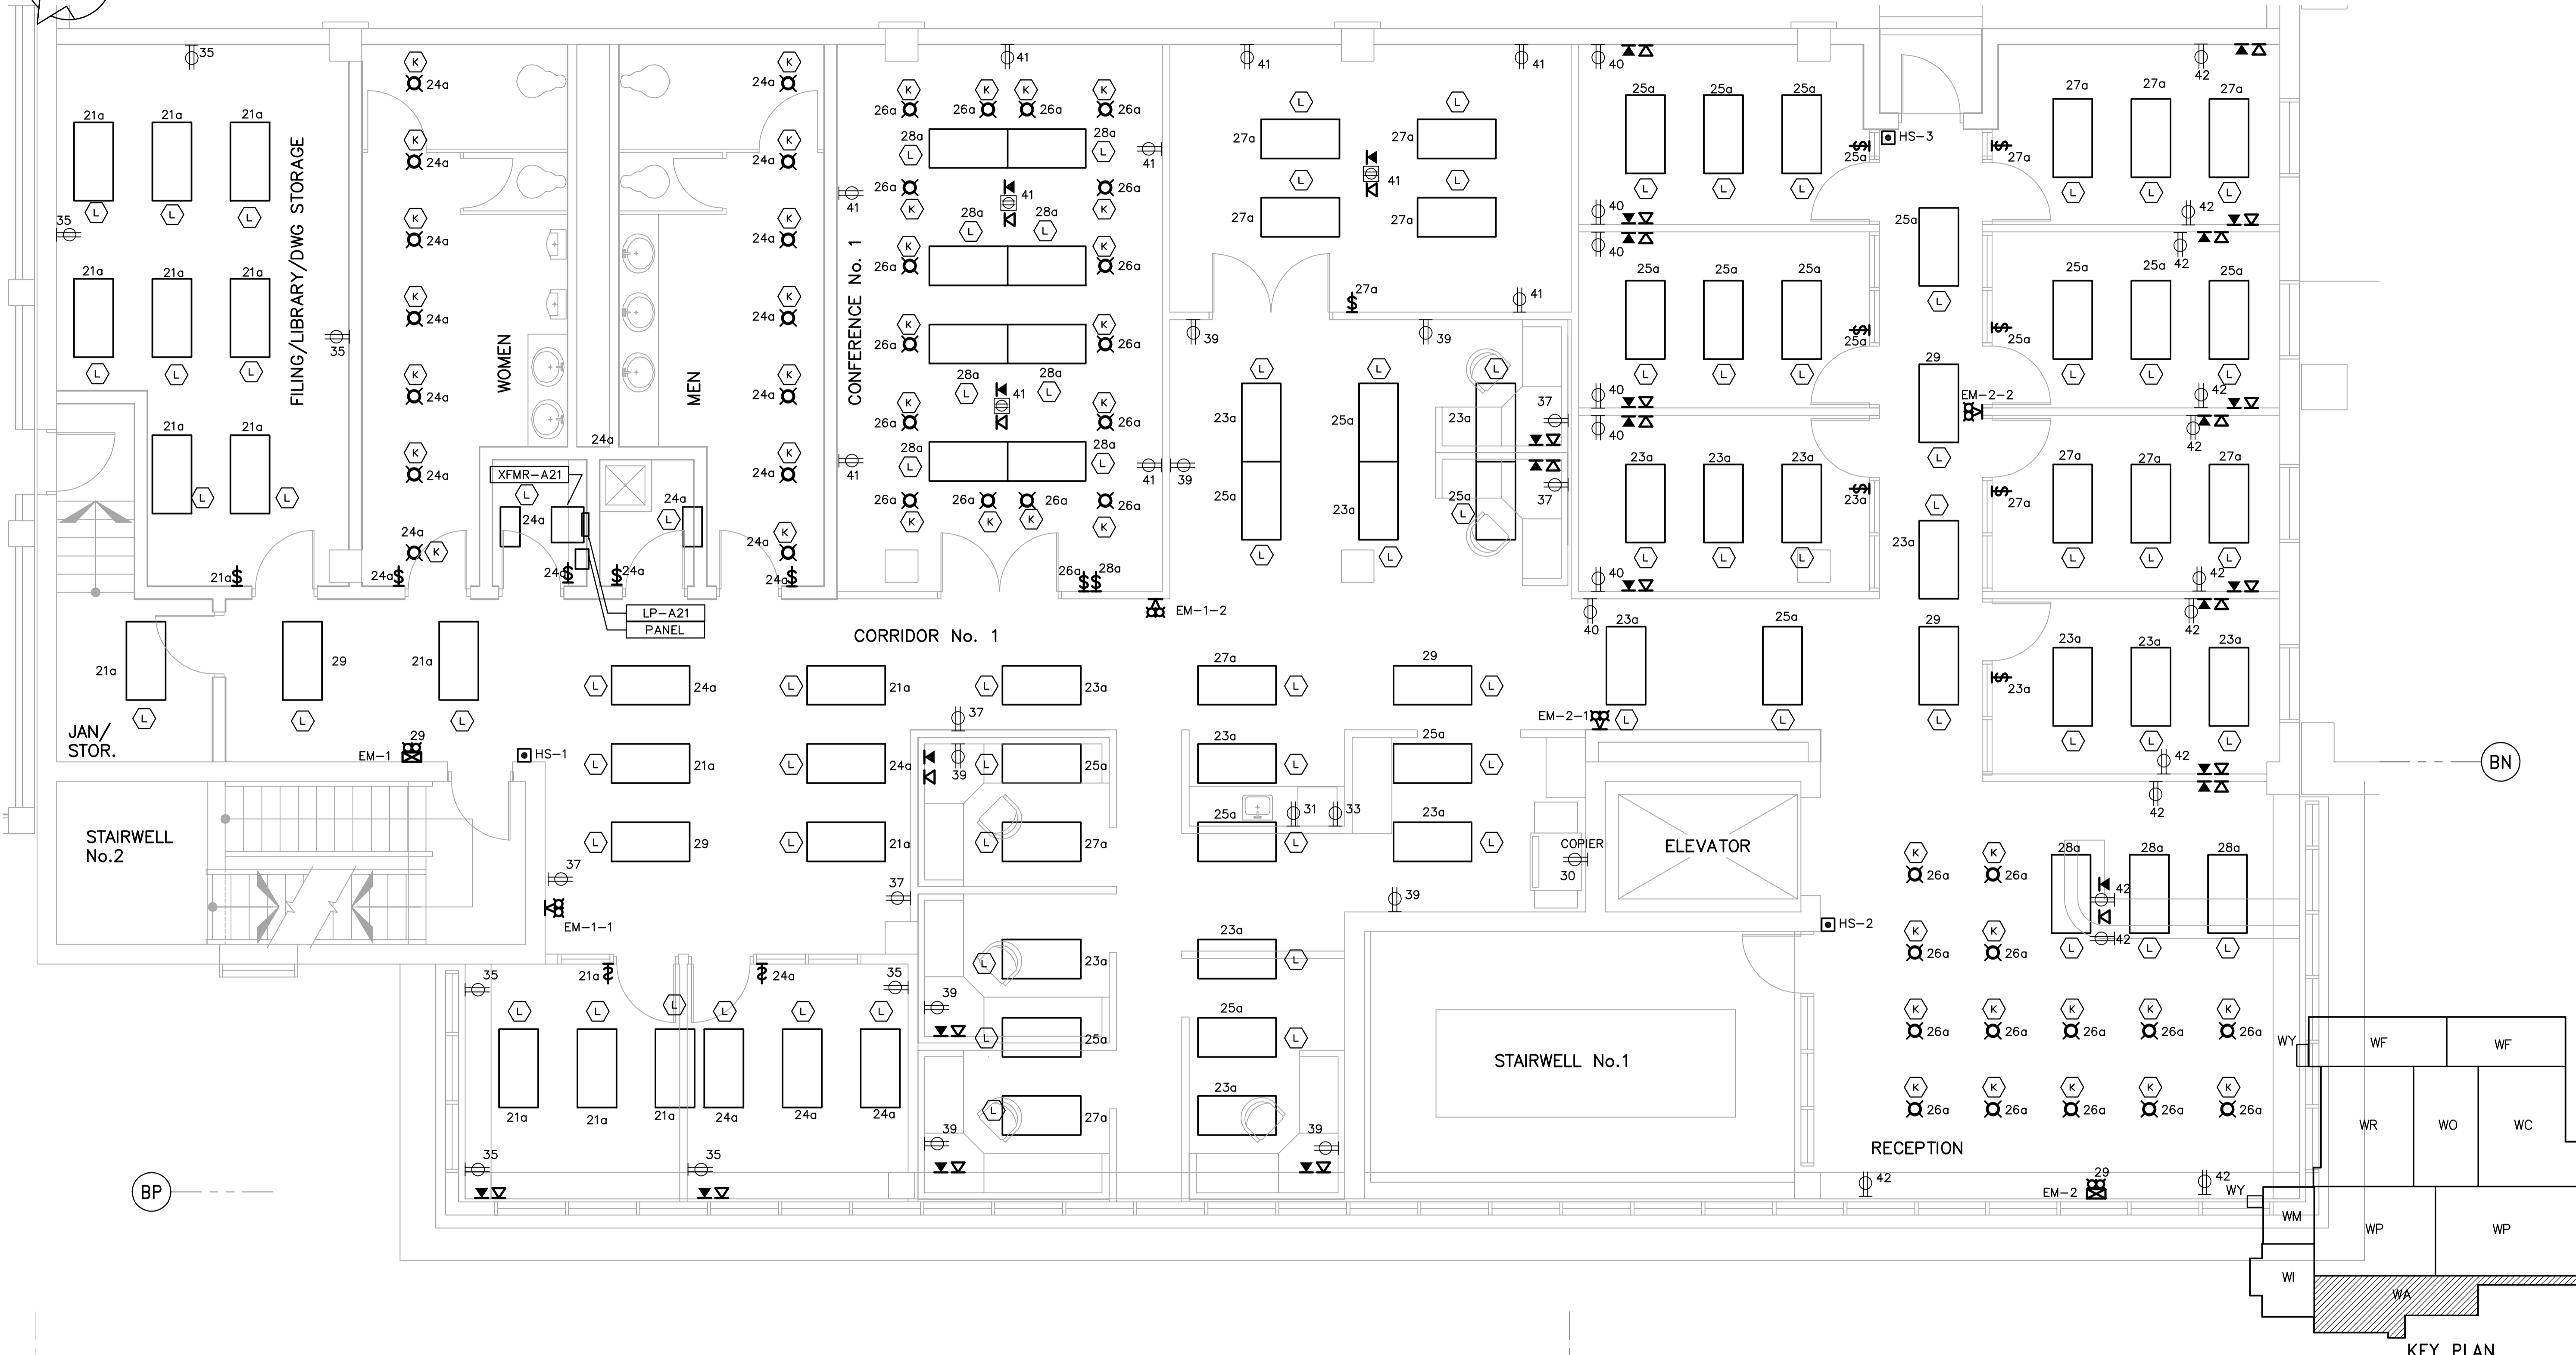

1 SECOND FLOOR POWER AND LIGHTING PLAN  
WA-E0113 1:50

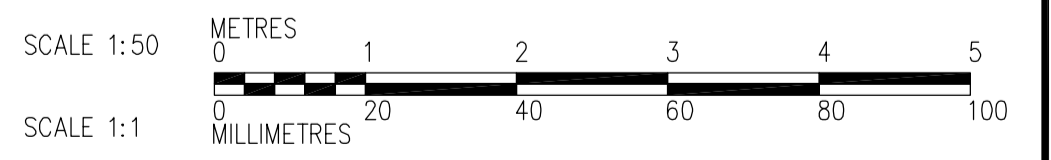

B2

B6

 <b>APEGN</b> Certificate of Authorization CH2M HILL Canada Ltd. No. 1441 Expiry: April 30, 2006	B.M. ELEV.	 Frederickson Cooper ARCHITECTS	 A Terra International Ltd. Company	ENGINEER'S SEAL  ORIGINAL SIGNED BY L.D. LLEWELLYN 2006/03/29	 <b>THE CITY OF WINNIPEG</b> WATER AND WASTE DEPARTMENT ENGINEERING DIVISION  WATER TREATMENT PLANT ADMINISTRATION AREA MECHANICAL AND ELECTRICAL  ELECTRICAL ADMINISTRATION AREA SECOND FLOOR POWER AND LIGHTING PLAN	CITY FILE NUMBER
	00 ISSUED FOR TENDER 06/03/29 LL	DESIGNED BY PF CHECKED BY ND DRAWN BY TL APPROVED BY AHL	CONSULTANT DRAWING NO. WA-E0401	SHEET OF		
	NO. REVISIONS DATE BY DATE 2006/02/07 DATE 2006/03/29	SCALE: 1:50 RELEASED FOR CONSTRUCTION BY: R. SOROKOWSKI	CITY DRAWING NUMBER 1-0601A-A-E0401-001-000			