


FIRST FLOOR PLAN
1:100

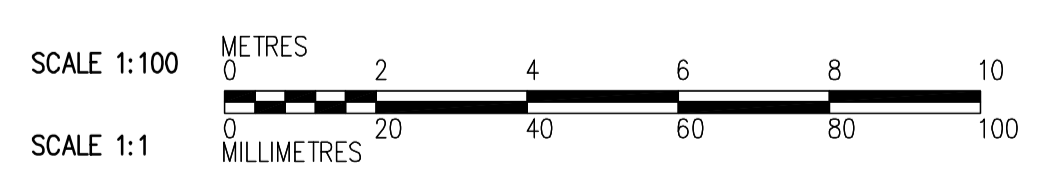

 Certificate of Authorization CH2M HILL Canada Ltd. No. 1441 Expiry: April 30, 2006	B.M. ELEV.	 Frederickson Cooper ARCHITECTS	 A Yeo International Ltd. Company	ENGINEER'S SEAL	 THE CITY OF WINNIPEG WATER AND WASTE DEPARTMENT ENGINEERING DIVISION WATER TREATMENT PLANT ADMINISTRATION MECHANICAL AND ELECTRICAL HVAC ADMINISTRATION AREA FIRST FLOOR PLAN	CITY FILE NUMBER
	DESIGNED BY TT CHECKED BY DL DRAWN BY AM APPROVED BY AHL			ORIGINAL SIGNED BY D.K. CUDDINGTON 2006/03/29		SHEET OF
	SCALE: 1:100 RELEASED FOR CONSTRUCTION BY: R. SOROKOWSKI	CONSULTANT DRAWING NO. WA-H0111	CITY DRAWING NUMBER			
	00 ISSUED FOR TENDER 06/03/29 TT NO. REVISIONS DATE BY	DATE 2005/07/04 DATE 2006/03/29	1-0601A-A-H0111-001-000			