

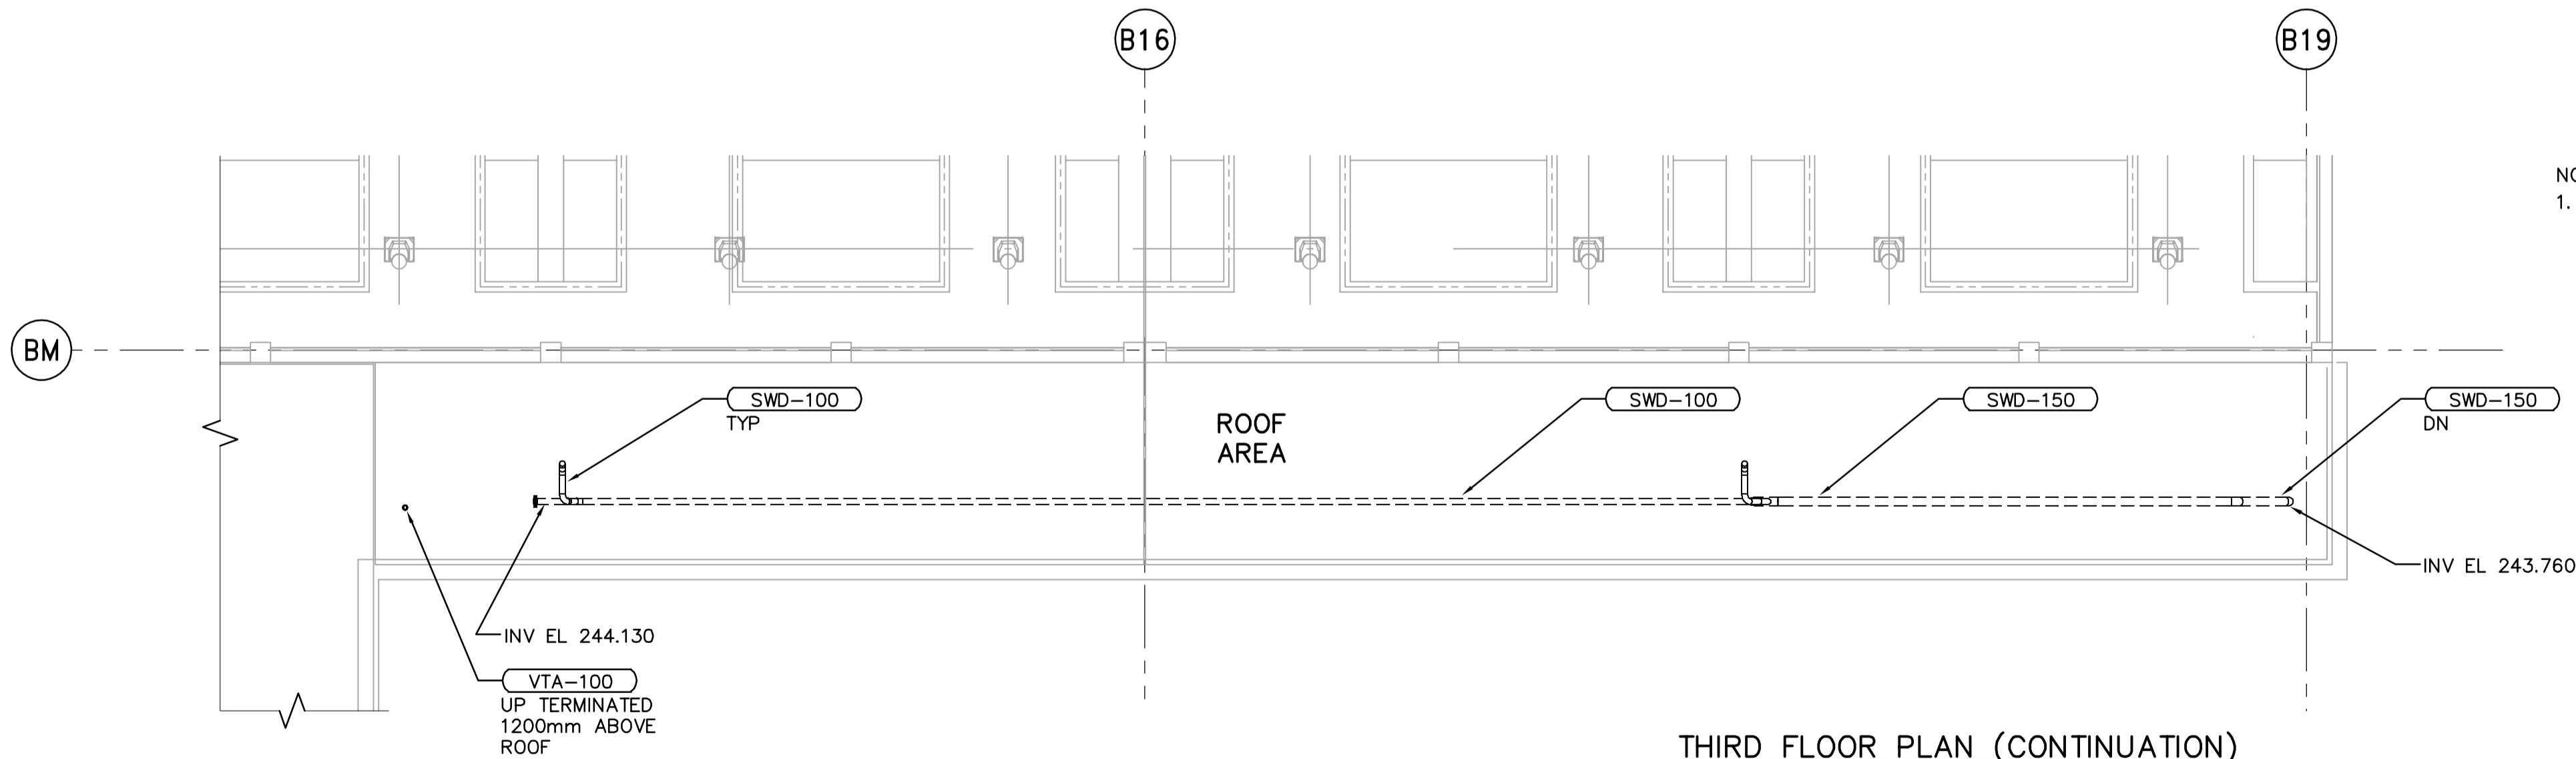


THIRD FLOOR PLAN
1:100

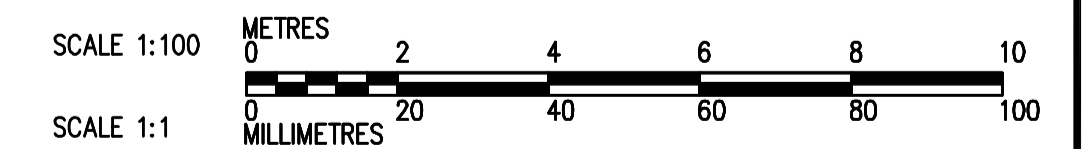

THIRD FLOOR PLAN (CONTINUATION)
1:100

NOTES
1. FOR PLUMBING FIXTURE CONNECTION SIZES, REFER TO FIXTURE CONNECTION SCHEDULE ON DWG. WB-H0533.

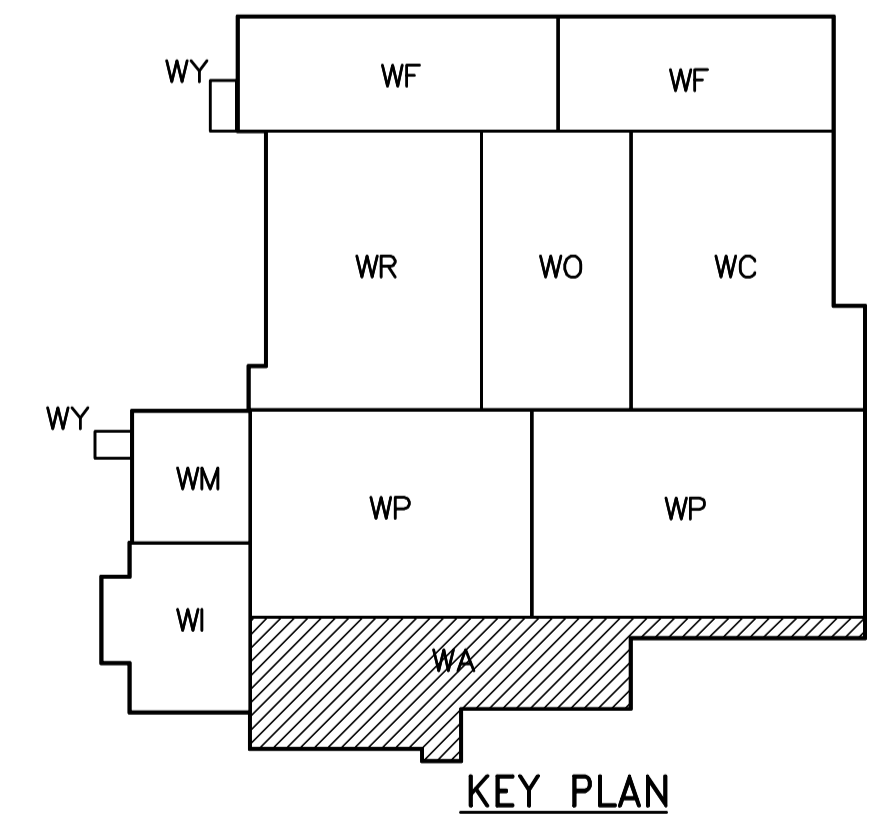

 Certificate of Authorization CH2M HILL Canada Ltd. No. 1441 Expiry: April 30, 2006	B.M. ELEV.	 Frederickson Cooper ARCHITECTS	 A You International Ltd. Company	ENGINEER'S SEAL ORIGINAL SIGNED BY D.K. CUDDINGTON 2006/03/29	 THE CITY OF WINNIPEG WATER AND WASTE DEPARTMENT ENGINEERING DIVISION WATER TREATMENT PLANT ADMINISTRATION MECHANICAL AND ELECTRICAL PLUMBING ADMINISTRATION AREA THIRD FLOOR PLAN	CITY FILE NUMBER
	00 ISSUED FOR TENDER 06/03/29 SW	DESIGNED BY JZ/SW CHECKED BY DL	CONSULTANT DRAWING NO. WA-H0132	SHEET OF		
	INO. REVISIONS DATE BY DATE 2005/07/15 DATE 2006/03/29	DRAWN BY JMcP APPROVED BY AHL	RELEASED FOR CONSTRUCTION BY: R. SOROKOWSKI	CITY DRAWING NUMBER 1-0601A-A-H0132-001-000		
		SCALE: 1:100	R. SOROKOWSKI			