

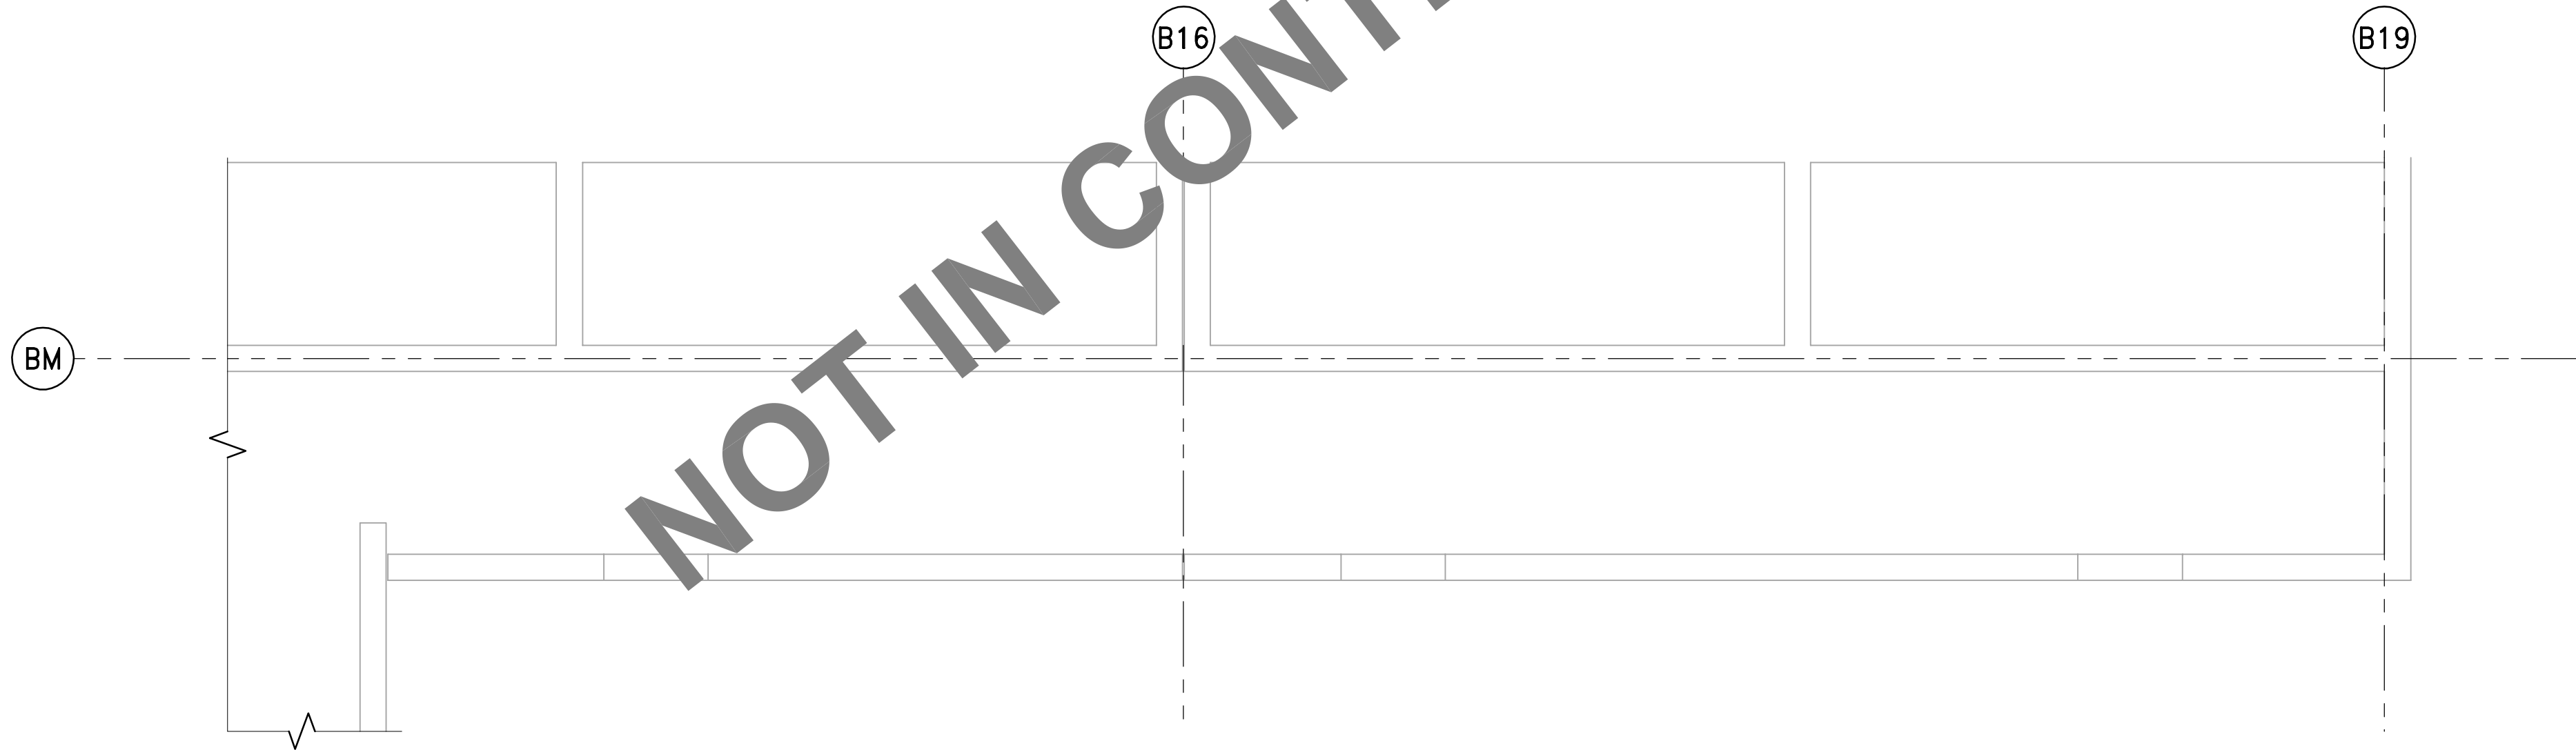


SECOND FLOOR PLAN  
1:100

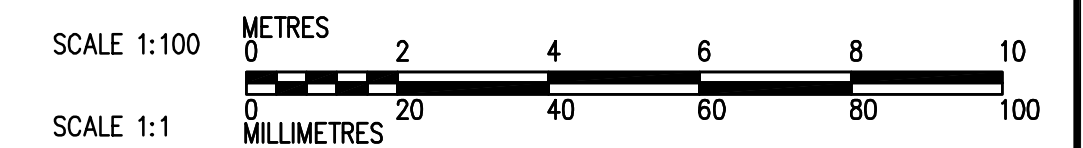

SECOND FLOOR PLAN (CONTINUATION)  
1:100

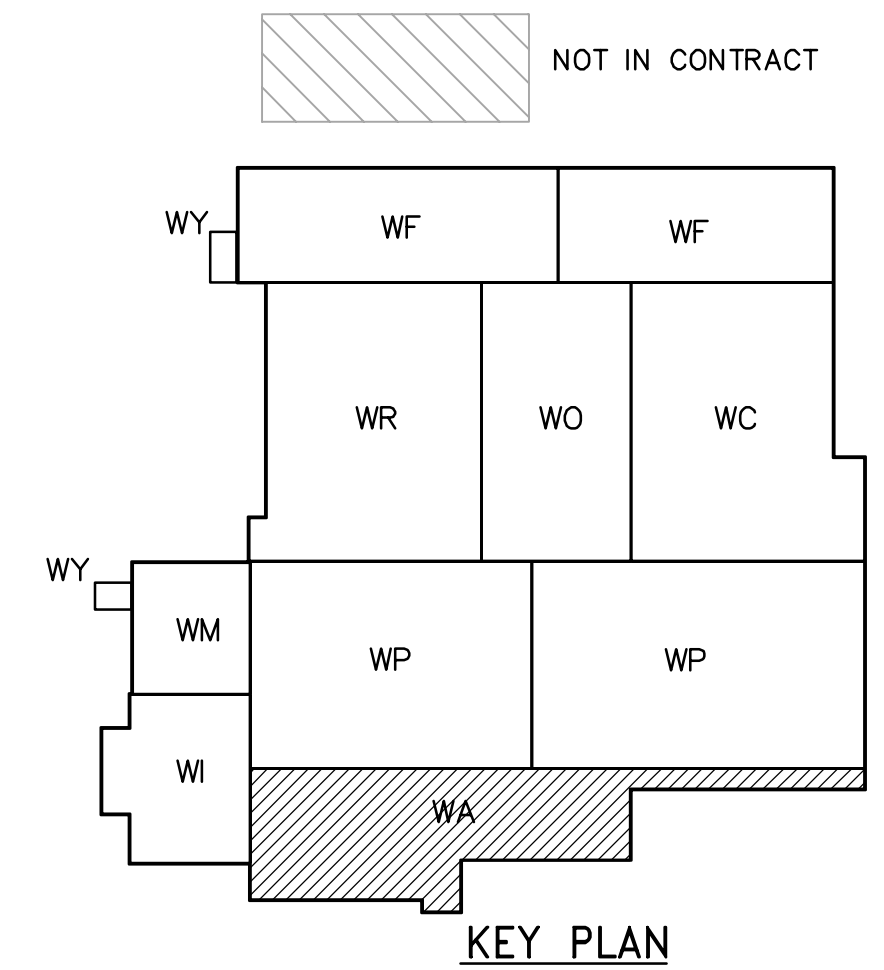

NOT IN CONTRACT - FOR INFORMATION ONLY

 <b>APECA</b> Certificate of Authorization CH2M HILL Canada Ltd. No. 1441 Expiry: April 30, 2006	B.M. ELEV.	 Frederickson Cooper ARCHITECTS	 EarthTech A Tyco International Ltd. Company	ENGINEER'S SEAL  ORIGINAL SIGNED BY D.K. CUDDINGTON  2006/02/06	 <b>THE CITY OF WINNIPEG</b> WATER AND WASTE DEPARTMENT ENGINEERING DIVISION
	DESIGNED BY JZ/SW DRAWN BY JMcP SCALE: 1:100	CHECKED BY DL APPROVED BY DJT RELEASED FOR CONSTRUCTION BY: R. SOROKOWSKI	CONSULTANT DRAWING NO. WA-H9122	WATER TREATMENT PLANT ADMINISTRATION FOUNDATIONS AND CONCRETE STRUCTURES	CITY FILE NUMBER SHEET OF CITY DRAWING NUMBER <b>1-0601A-A-H9122-001-00D</b>
00 ISSUED FOR TENDER 2006/02/03 SW NO. REVISIONS DATE BY	DATE 2005/07/15 DATE 2006/02/08	PLUMBING PIPE EMBEDS ADMINISTRATION AREA SECOND FLOOR PLAN			