

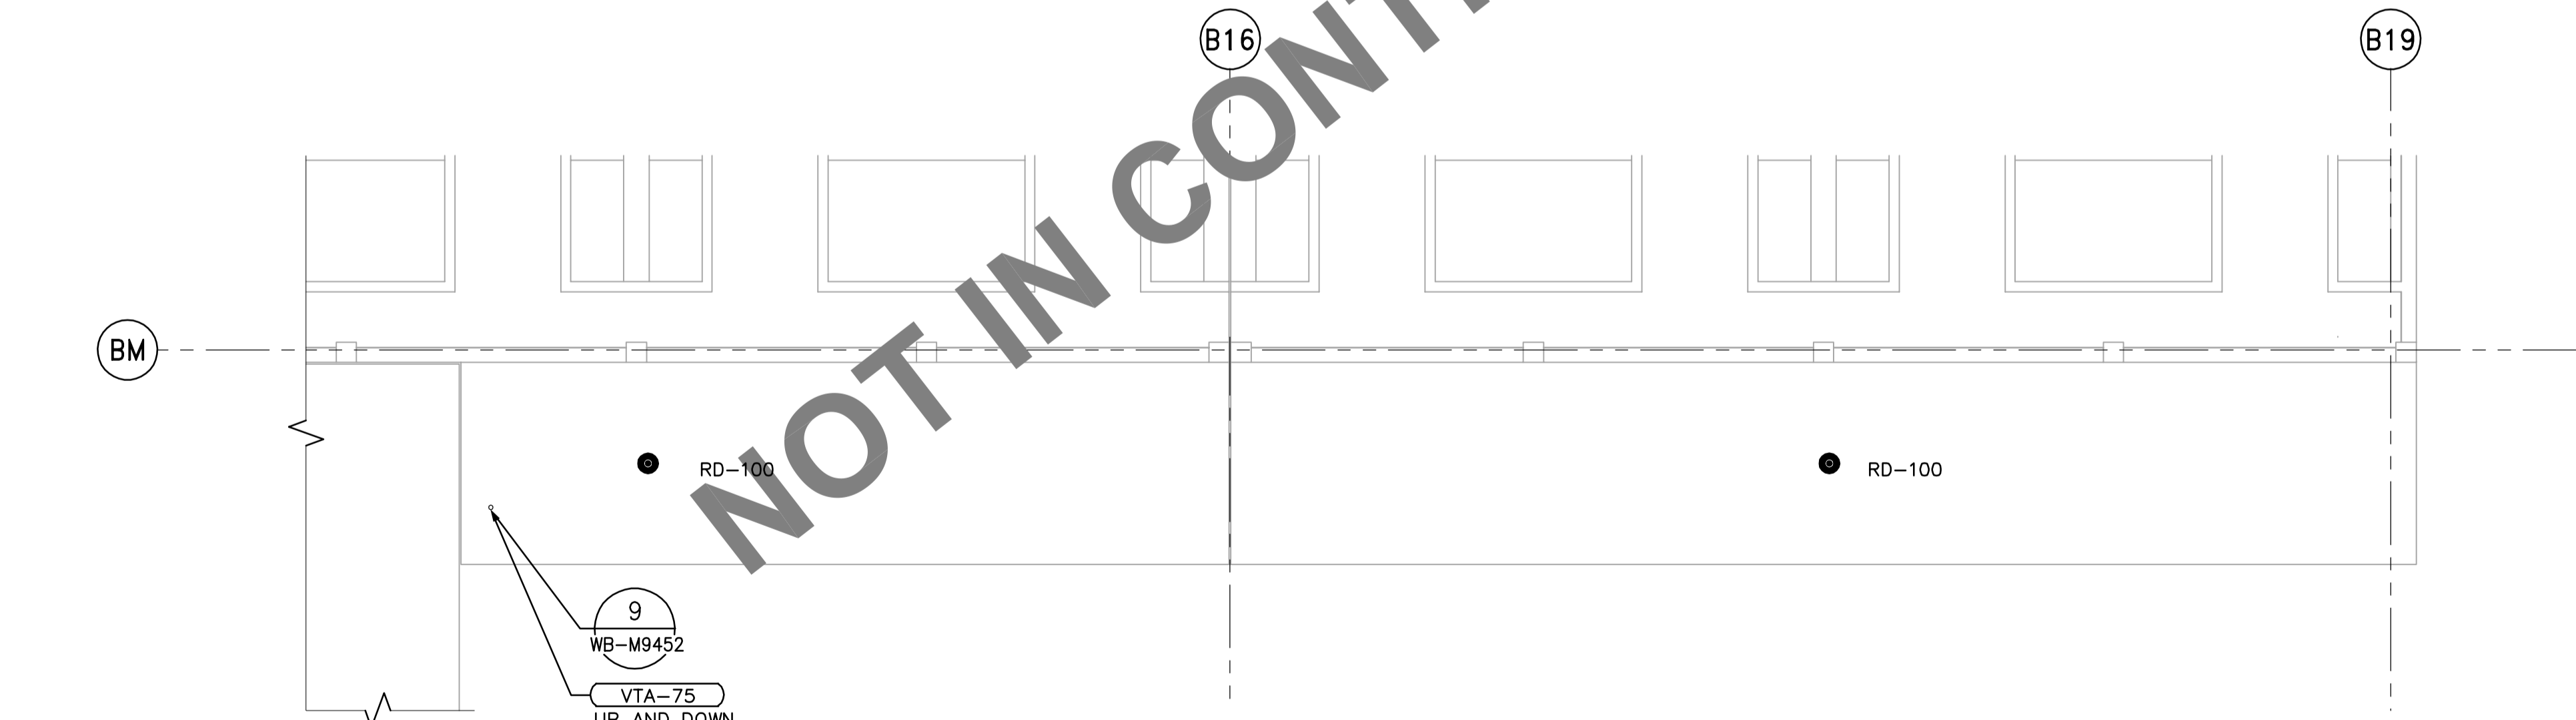


THIRD FLOOR PLAN  
1:100

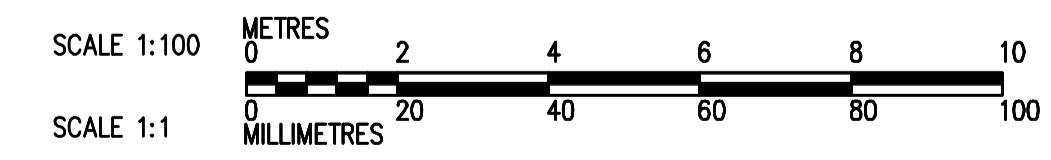

THIRD FLOOR PLAN (CONTINUATION)  
1:100

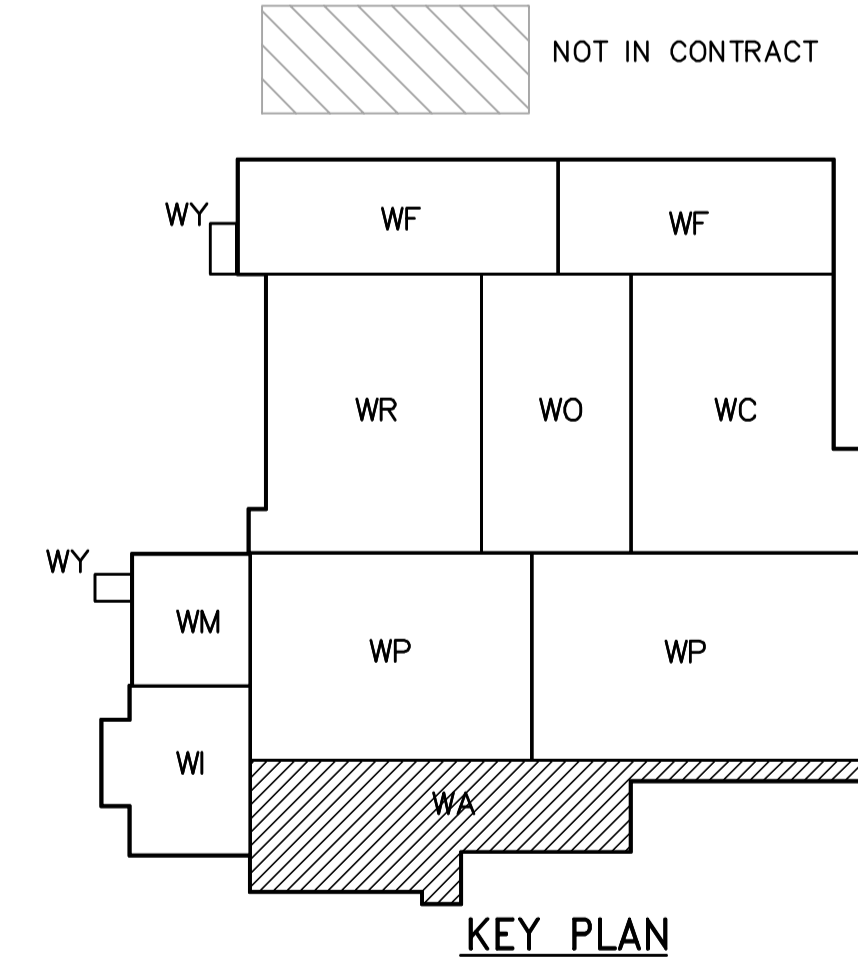

<p><b>APEGN</b> Certificate of Authorization CH2M HILL Canada Ltd. No. 1441 Expiry: April 30, 2006</p>	<p>Frederickson Cooper ARCHITECTS</p>	<p>EarthTech A Tyco International Ltd. Company</p>	ENGINEER'S SEAL	<p><b>THE CITY OF WINNIPEG</b> WATER AND WASTE DEPARTMENT ENGINEERING DIVISION</p>		
			DESIGNED BY: JZ		CHECKED BY: DL	ORIGINAL SIGNED BY: D.K. CUDDINGTON
			DRAWN BY: JMcP		APPROVED BY: DJT	DATE: 2006/02/06
			SCALE: 1:100		RELEASED FOR CONSTRUCTION BY: R. SOROKOWSKI	CONSULTANT DRAWING NO. WA-H9132
00 ISSUED FOR TENDER	2006/02/03	JZ	DATE: 2005/07/15	DATE: 2006/02/08	<p>WATER TREATMENT PLANT ADMINISTRATION FOUNDATIONS AND CONCRETE STRUCTURES</p> <p>PLUMBING PIPE EMBEDS ADMINISTRATION AREA THIRD FLOOR PLAN</p>	<p>CITY FILE NUMBER</p> <p>SHEET OF</p> <p>CITY DRAWING NUMBER</p> <p><b>1-0601A-A-H9132-001-00D</b></p>