


--- LIMIT OF MECHANICAL AND ELECTRICAL CONTRACT 742-2005

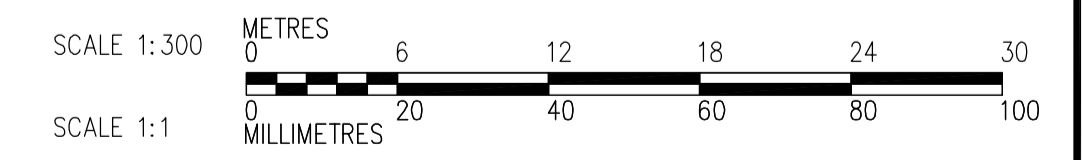

<p>Certificate of Authorization CH2M HILL Canada Ltd. No. 1441 Expiry: April 30, 2006</p>	<p>Frederickson Cooper ARCHITECTS</p>		<p>A You International Ltd. Company</p>		ENGINEER'S SEAL ORIGINAL SIGNED BY L.D. LLEWELLYN 2006/03/29	<p>THE CITY OF WINNIPEG WATER AND WASTE DEPARTMENT ENGINEERING DIVISION</p> <p>WATER TREATMENT PLANT MAIN BUILDING MECHANICAL AND ELECTRICAL</p> <p>ELECTRICAL OVERALL BUILDING FIRST FLOOR PLAN</p>	CITY FILE NUMBER SHEET OF
	DESIGNED BY: JT CHECKED BY: ND		DRAWN BY: KJ APPROVED BY: AHL		CONSULTANT DRAWING NO. WB-E0110		CITY DRAWING NUMBER 1-0601B-A-E0110-001-000
	SCALE: 1:300 RELEASED FOR CONSTRUCTION BY: R. SOROKOWSKI		DATE: 2005/06/29 DATE: 2006/03/29				
	B.M. ELEV.						
00 ISSUED FOR TENDER 06/03/29 LL		INO. REVISIONS DATE BY					