


**ROOF PLAN**  
1:300

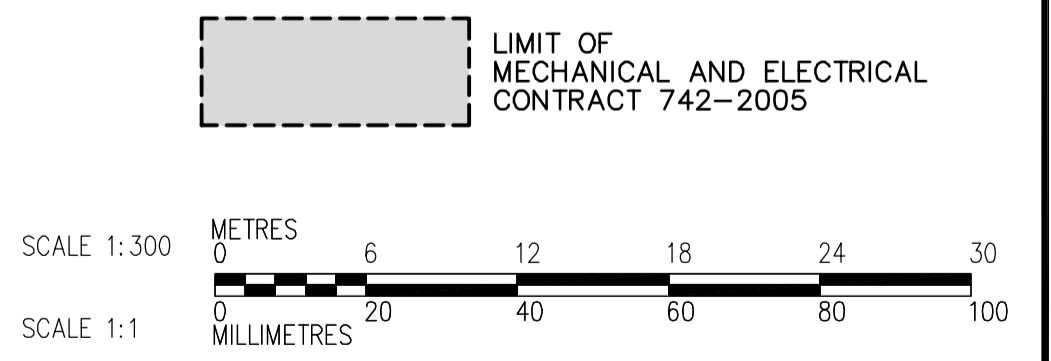

 <b>APEGN</b> Certificate of Authorization CH2M HILL Canada Ltd. No. 1441 Expiry: April 30, 2006	B.M. ELEV.	 Frederickson Cooper ARCHITECTS	 A Terra International Ltd. Company	ENGINEER'S SEAL  ORIGINAL SIGNED BY L.D. LLEWELLYN 2006/03/29	 <b>THE CITY OF WINNIPEG</b> WATER AND WASTE DEPARTMENT ENGINEERING DIVISION																
	<table border="1" style="width:100%; border-collapse: collapse;"> <tr> <td style="width:50%;">00 ISSUED FOR TENDER</td> <td style="width:10%;">06/03/29</td> <td style="width:5%;">LL</td> <td style="width:5%;">DATE</td> <td style="width:5%;">BY</td> <td style="width:5%;">DATE</td> <td style="width:5%;">DATE</td> <td style="width:5%;">DATE</td> </tr> <tr> <td>NO. REVISIONS</td> <td></td> <td></td> <td></td> <td></td> <td>2005/06/29</td> <td></td> <td>2006/03/29</td> </tr> </table>	00 ISSUED FOR TENDER	06/03/29	LL	DATE	BY	DATE	DATE	DATE	NO. REVISIONS					2005/06/29		2006/03/29	DESIGNED BY: LL CHECKED BY: ND DRAWN BY: TLL APPROVED BY: AHL SCALE: 1:300 RELEASED FOR CONSTRUCTION BY: R. SOROKOWSKI	CONSULTANT DRAWING NO. WB-E0145	WATER TREATMENT PLANT MAIN BUILDING MECHANICAL AND ELECTRICAL	CITY FILE NUMBER SHEET OF CITY DRAWING NUMBER 1-0601B-A-E0145-001-000
	00 ISSUED FOR TENDER	06/03/29	LL	DATE	BY	DATE	DATE	DATE													
NO. REVISIONS					2005/06/29		2006/03/29														
ELECTRICAL OVERALL BUILDING ROOF PLAN																					