


- NOTES:
1. REFER TO DWG WM-E0011 AND WM-H0001 FOR SYMBOL LEGENDS.
 2. REFER TO HVAC DRAWINGS FOR DUCT MOUNTED SMOKE DETECTOR LOCATIONS.

- F. EXT-2 (TYP. OF 2)
- FIRE ALARM PANEL
- FIRE DEPARTMENT CONNECTION
- FIRE PUMP ROOM SEE WM-H0113
- F. EXT-1 (TYP.)

FIRST FLOOR PLAN
1:300

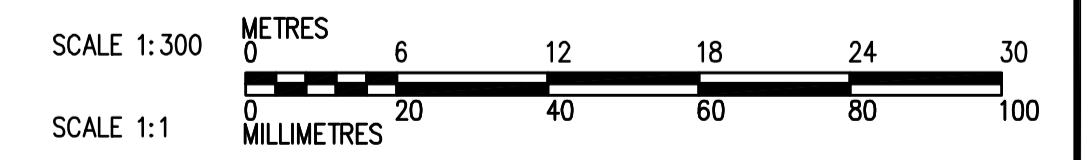

 APEGN Certificate of Authorization CH2M HILL Canada Ltd. No. 1441 Expiry: April 30, 2006	 Frederickson Cooper ARCHITECTS	 A Terra International Ltd. Company	ENGINEER'S SEAL ORIGINAL SIGNED BY D.K. CUDDINGTON 2006/03/29	 THE CITY OF WINNIPEG WATER AND WASTE DEPARTMENT ENGINEERING DIVISION	CITY FILE NUMBER SHEET OF
	DESIGNED BY DKC CHECKED BY SW DRAWN BY VPS APPROVED BY AHL			WATER TREATMENT PLANT MAIN BUILDING MECHANICAL AND ELECTRICAL	
	SCALE: 1:300 RELEASED FOR CONSTRUCTION BY: R. SOROKOWSKI			FIRE PROTECTION OVERALL BUILDING FIRST FLOOR PLAN	
00 ISSUED FOR TENDER 06/03/29 DKC NO. REVISIONS DATE BY		DATE 2006/01/06 DATE 2006/03/29		CONSULTANT DRAWING NO. WB-H0112	
			CITY DRAWING NUMBER 1-0601B-A-H0112-001-000		