


SLUDGE PUMP (P-R100C)

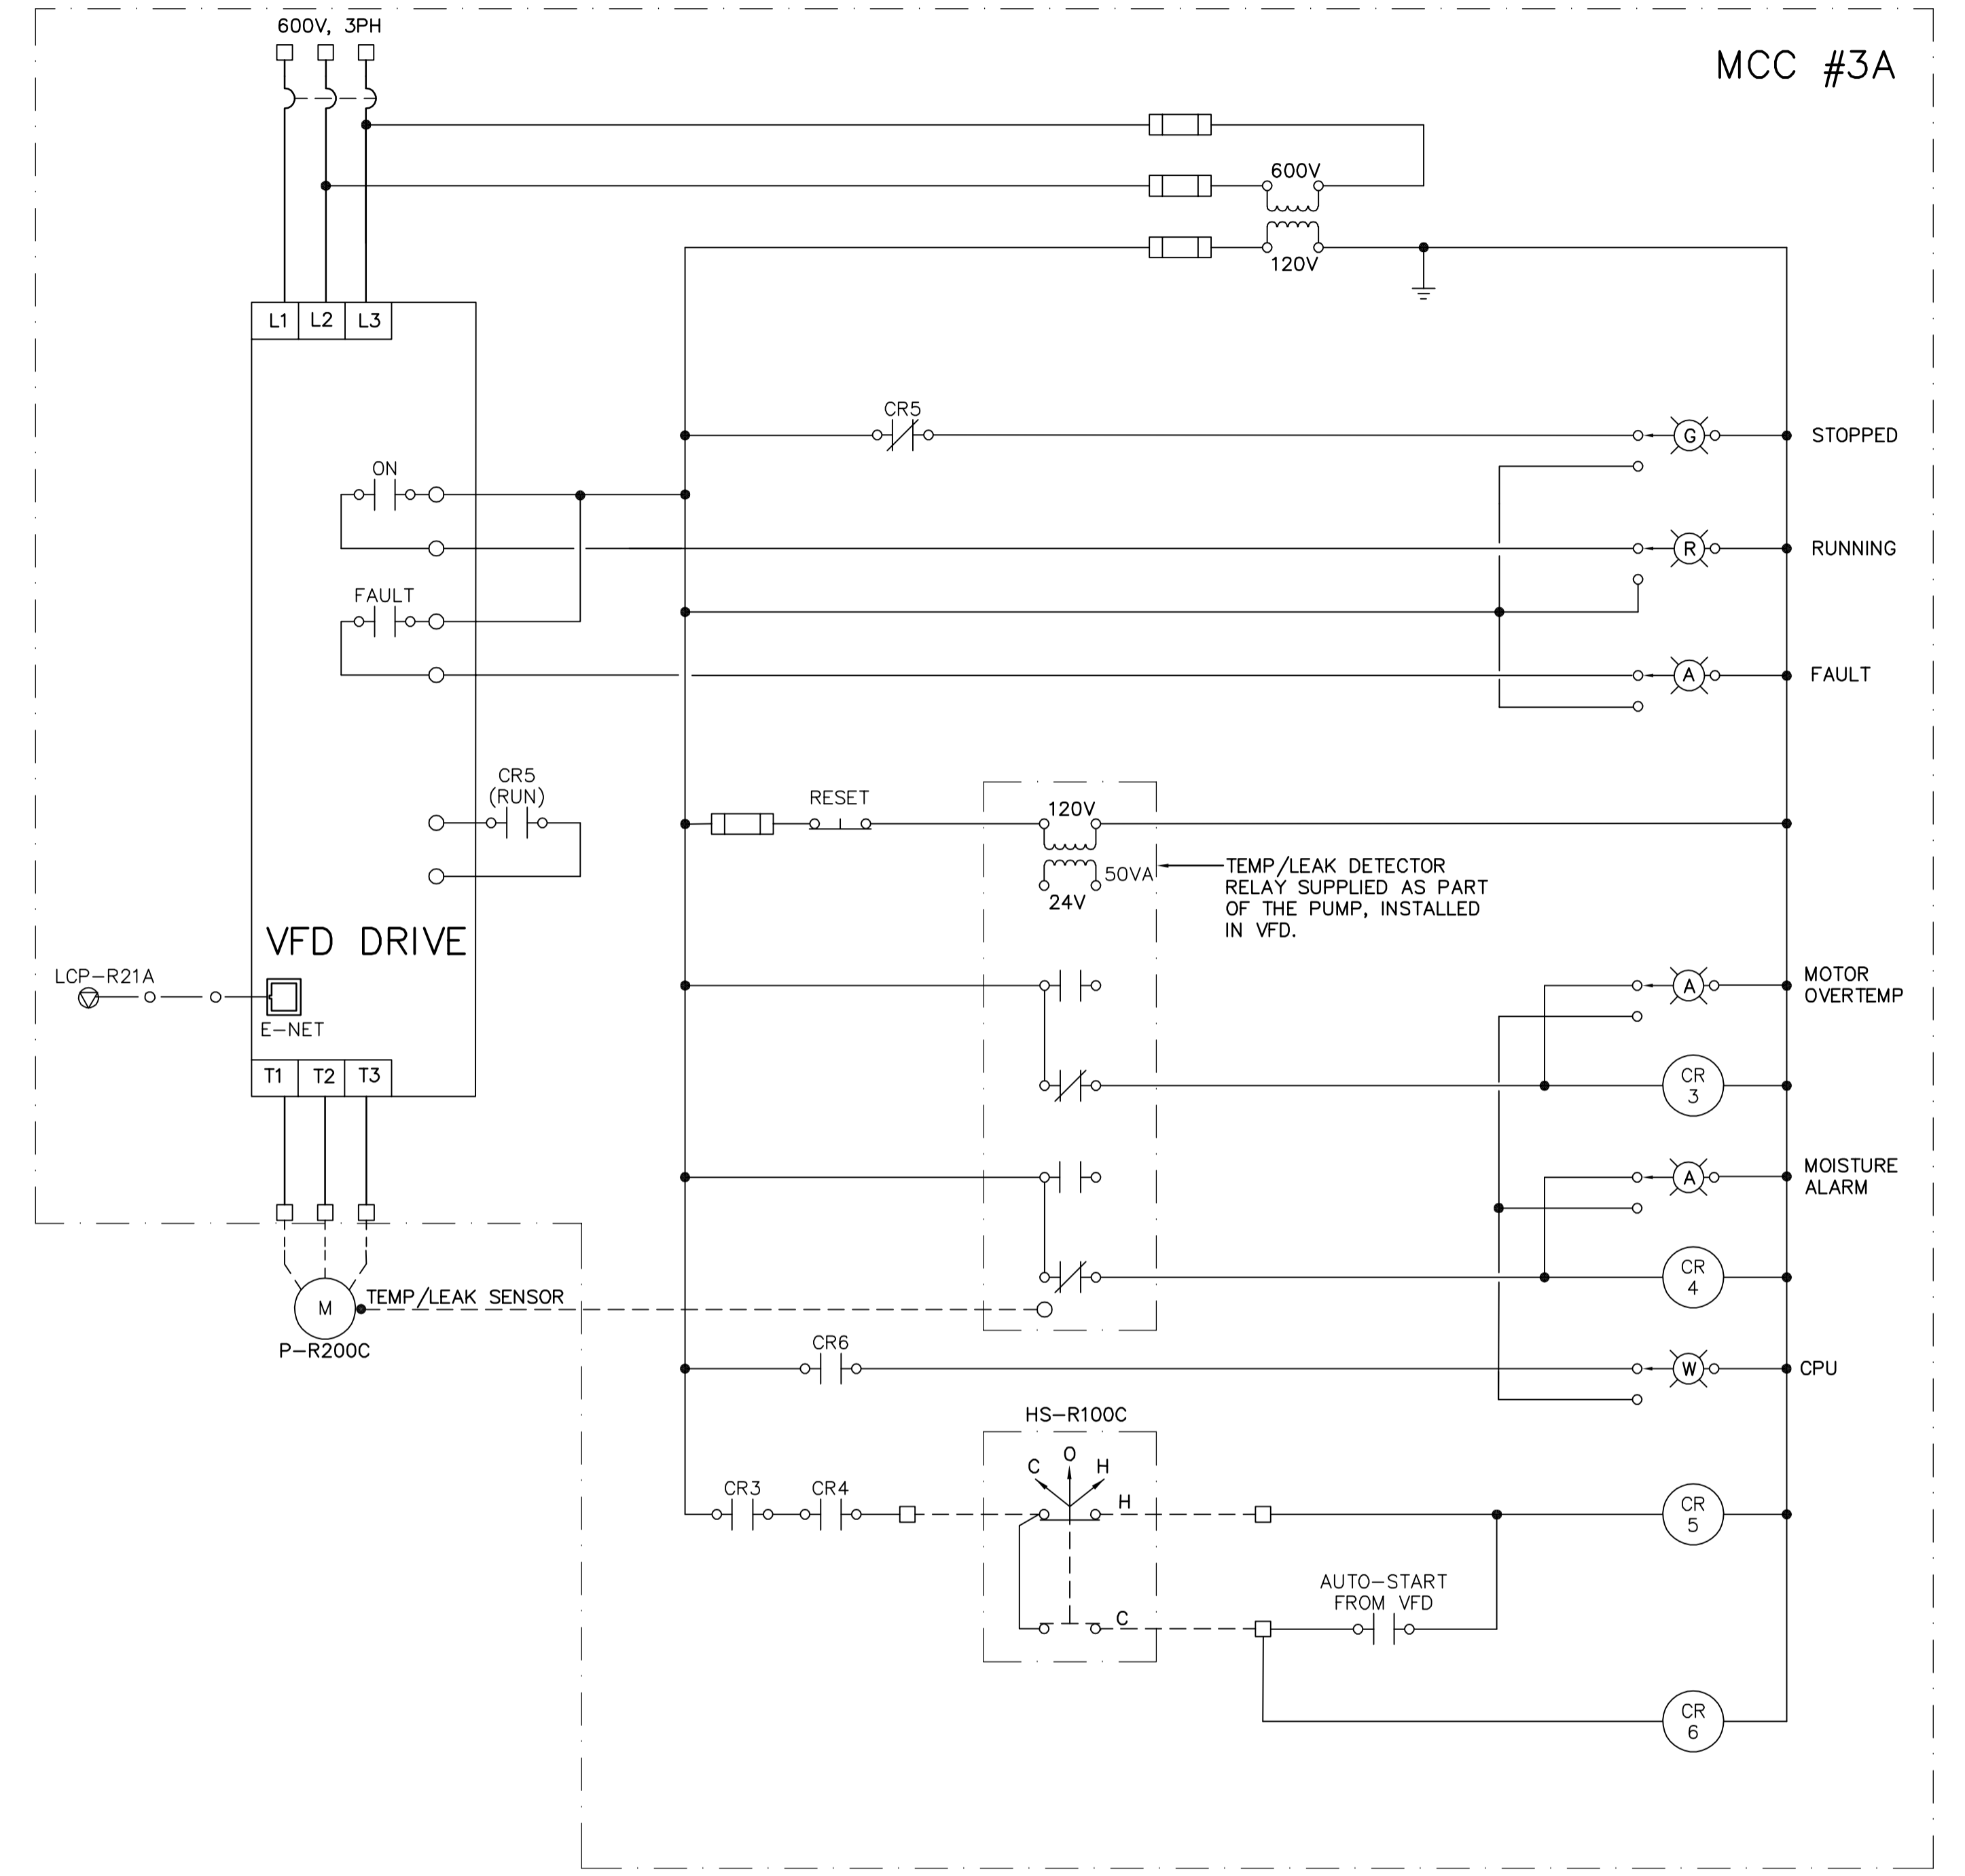

SLUDGE PUMP (P-R200C)

 APEGN Certificate of Authorization CH2M HILL Canada Ltd. No. 1441 Expiry: April 30, 2006	B.M. ELEV.	 Frederickson Cooper ARCHITECTS	 A Geo International Ltd. Company	ENGINEER'S SEAL ORIGINAL SIGNED BY L.D. LLEWELLYN 2006/03/29	 THE CITY OF WINNIPEG WATER AND WASTE DEPARTMENT ENGINEERING DIVISION
	DESIGNED BY: JT CHECKED BY: ND DRAWN BY: KJ APPROVED BY: AHL SCALE: NTS RELEASED FOR CONSTRUCTION BY: R. SOROKOWSKI DATE: 2005/11/08 DATE: 2006/03/29	CONSULTANT DRAWING NO. WB-E0556	WATER TREATMENT PLANT MAIN BUILDING MECHANICAL AND ELECTRICAL ELECTRICAL CONTROL DIAGRAM	CITY FILE NUMBER SHEET OF CITY DRAWING NUMBER 1-0601B-H-E0556-001-000	